


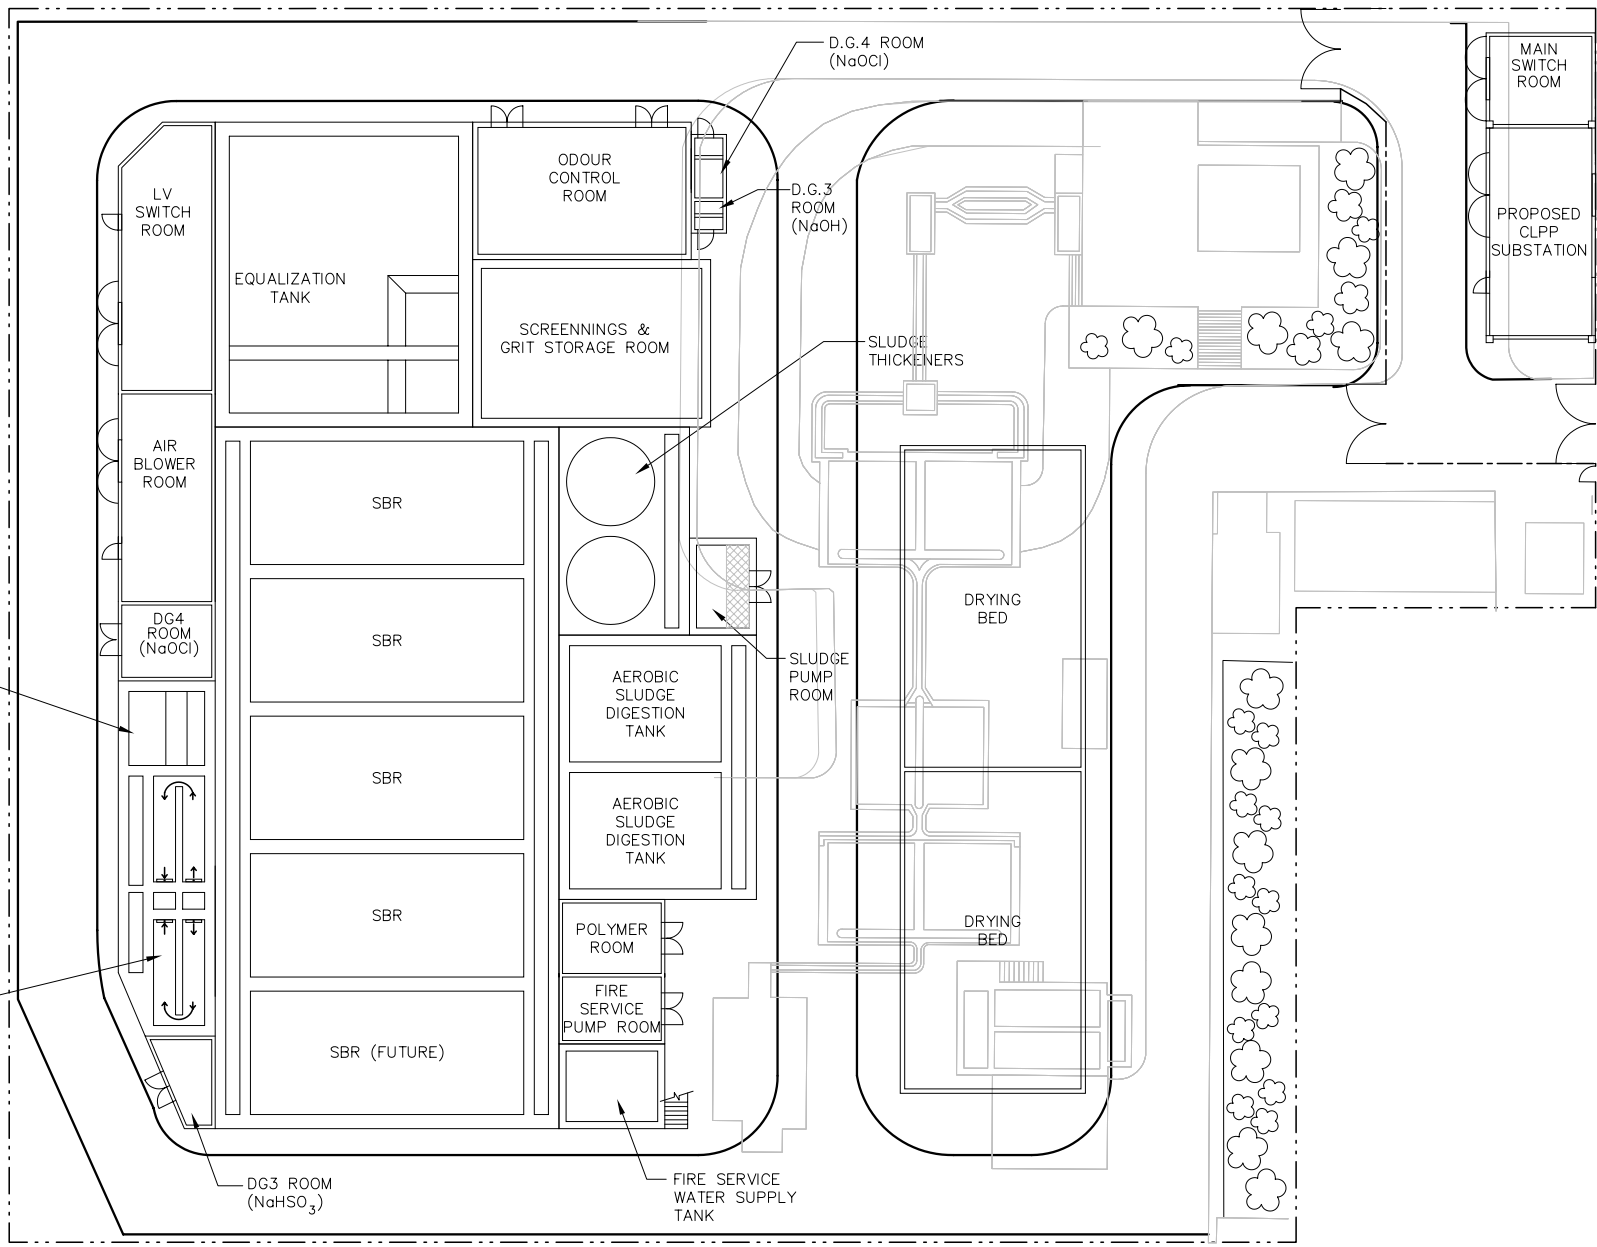

EFFLUENT PUMPING STATION

CHLORINE CONTACT TANK



LEGEND:
 - - - - SITE BOUNDARY
 - - - - FENCING

2 0 2 4 Meter
 Scale 1 : 300
 for A3-size



Figure 2-4a
General Layout for Proposed Peng Chau STW Upgrade
- Ground Floor Plan

