



**NOTE:**


1. REFER TO FIGURE 2.3 FOR LOCATION OF FLOODWATER PUMPING STATION AT TAI PO MARKET.

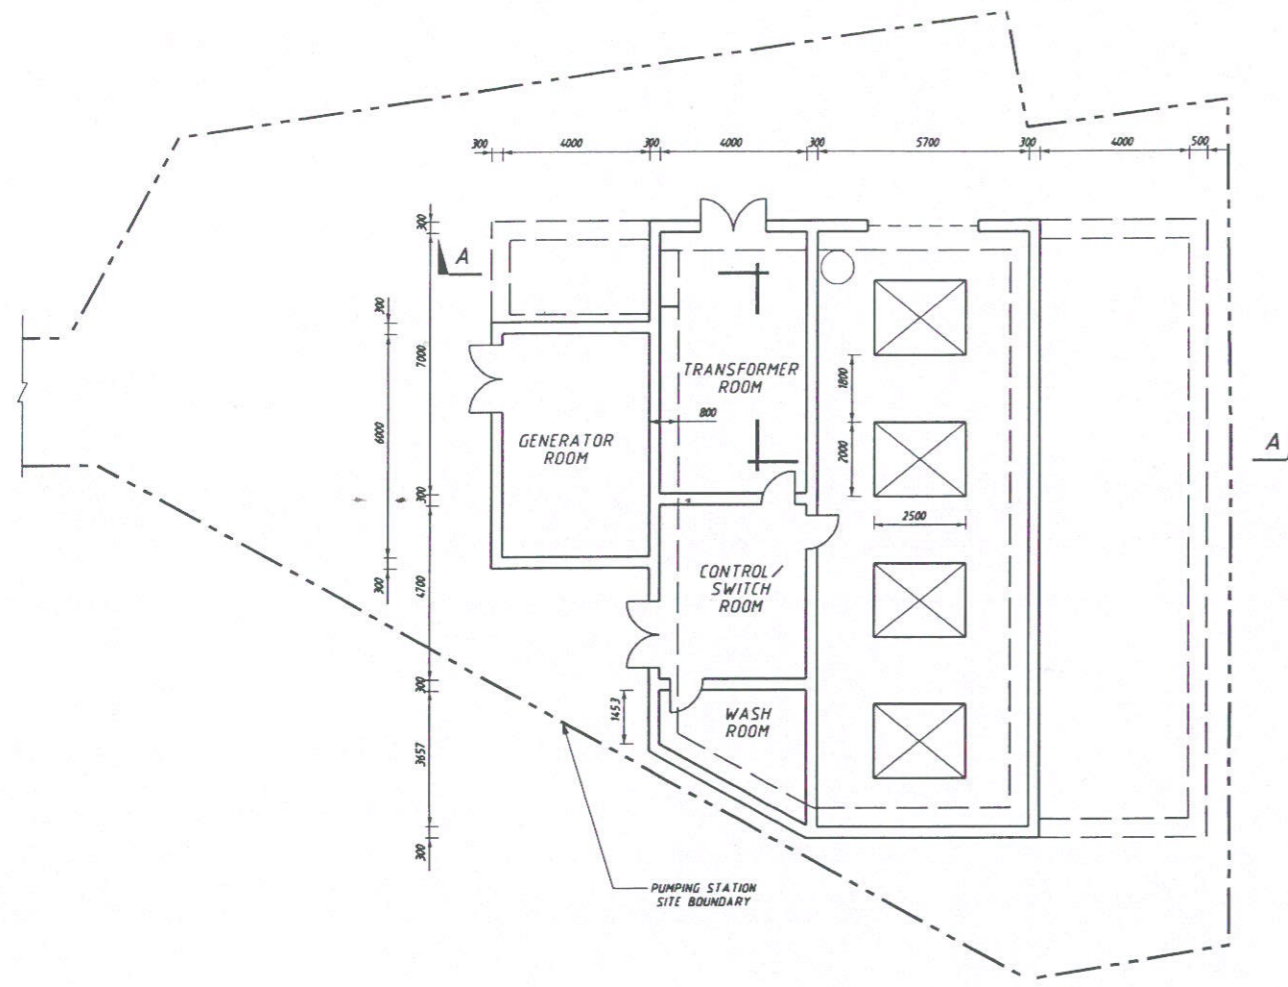

GROUND FLOOR PLAN

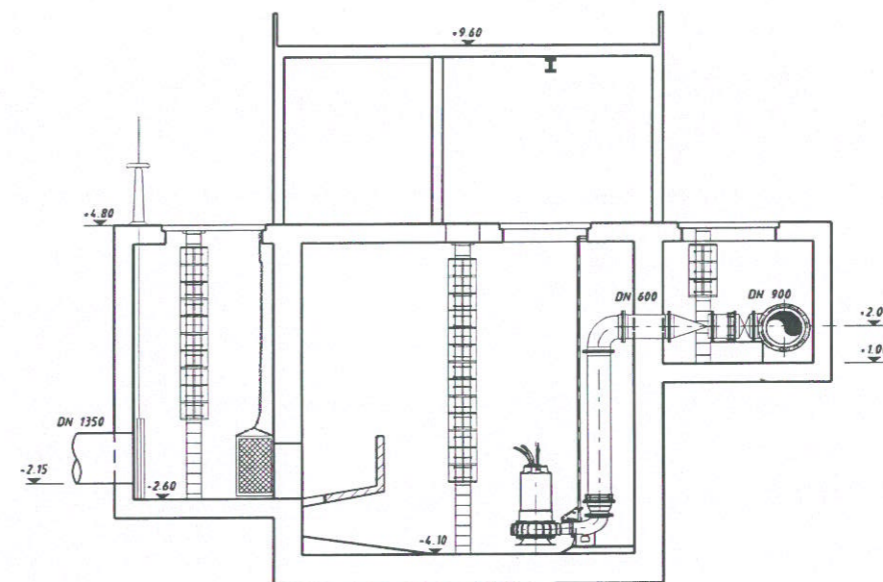

SECTION A-A

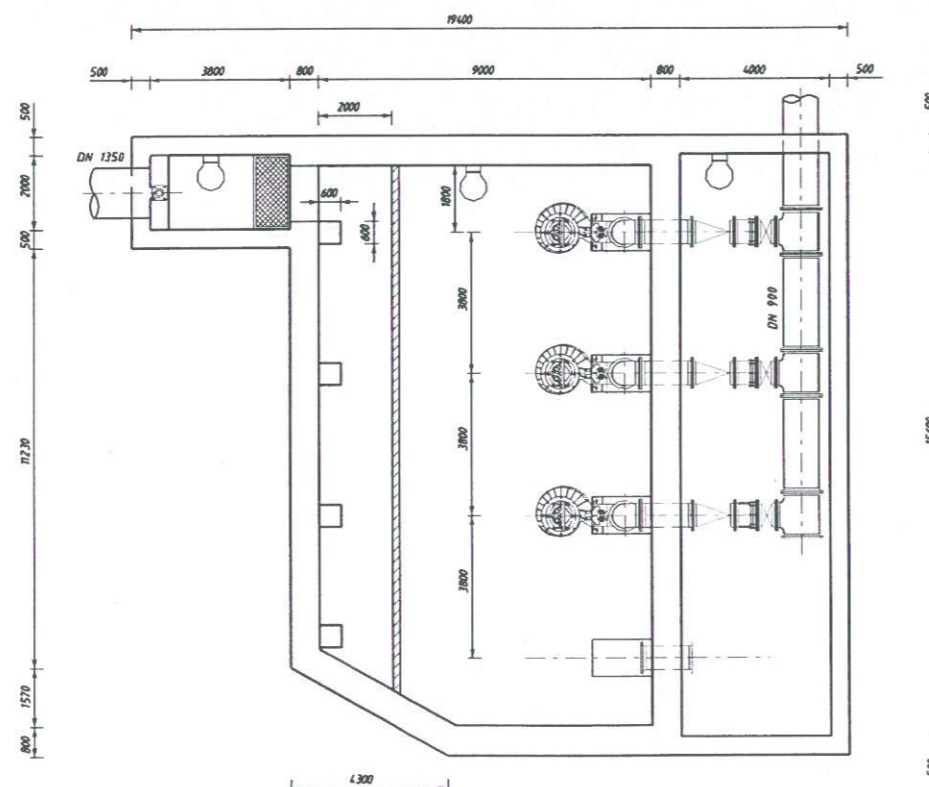

BASEMENT PLAN

REV. NO.	DESCRIPTION	DATE	BY	APPROVED	SCALE
001	PROPOSED				

**DRAINAGE SERVICES DEPARTMENT,  
THE GOVERNMENT OF THE HONG KONG  
SPECIAL ADMINISTRATIVE REGION**

AGREEMENT No. CE 50/2001 (DS)  
DRAINAGE IMPROVEMENT IN SHIA TIN AND TAI PO  
DESIGN AND CONSTRUCTION

**CONSTRUCTION OF FLOODWATER  
PUMPING STATION AT  
TAI PO MARKET**

MAUNSELL CONSULTANTS ASIA LTD.  
茂盛(亞洲)工程顧問有限公司

DRG. NO. **FIGURE 1.6J**

DESIGNED BY SHT	CONTRACT NO. CPWU	DATE OF ISSUE 2001
DRAWN BY XXL	STATUS PRELIMINARY	
SCALE AS SHOWN	COPYRIGHT RESERVED © 茂盛 謹啟	

**Maunsell**