


ENSR  
 MAUNSELL  
 ENSR Asia (HK) Ltd.

AECOM

WEST ISLAND LINE ENVIRONMENTAL IMPACT ASSESSMENT  
 SITE PLAN - KENNEDY TOWN STATION

SCALE	A3 1:2000	DATE	DEC. 2007
CHECK	-	DRAWN	LL
JOB NO.	60017115	DRAWING NO.	FIG 2.3
		REV	

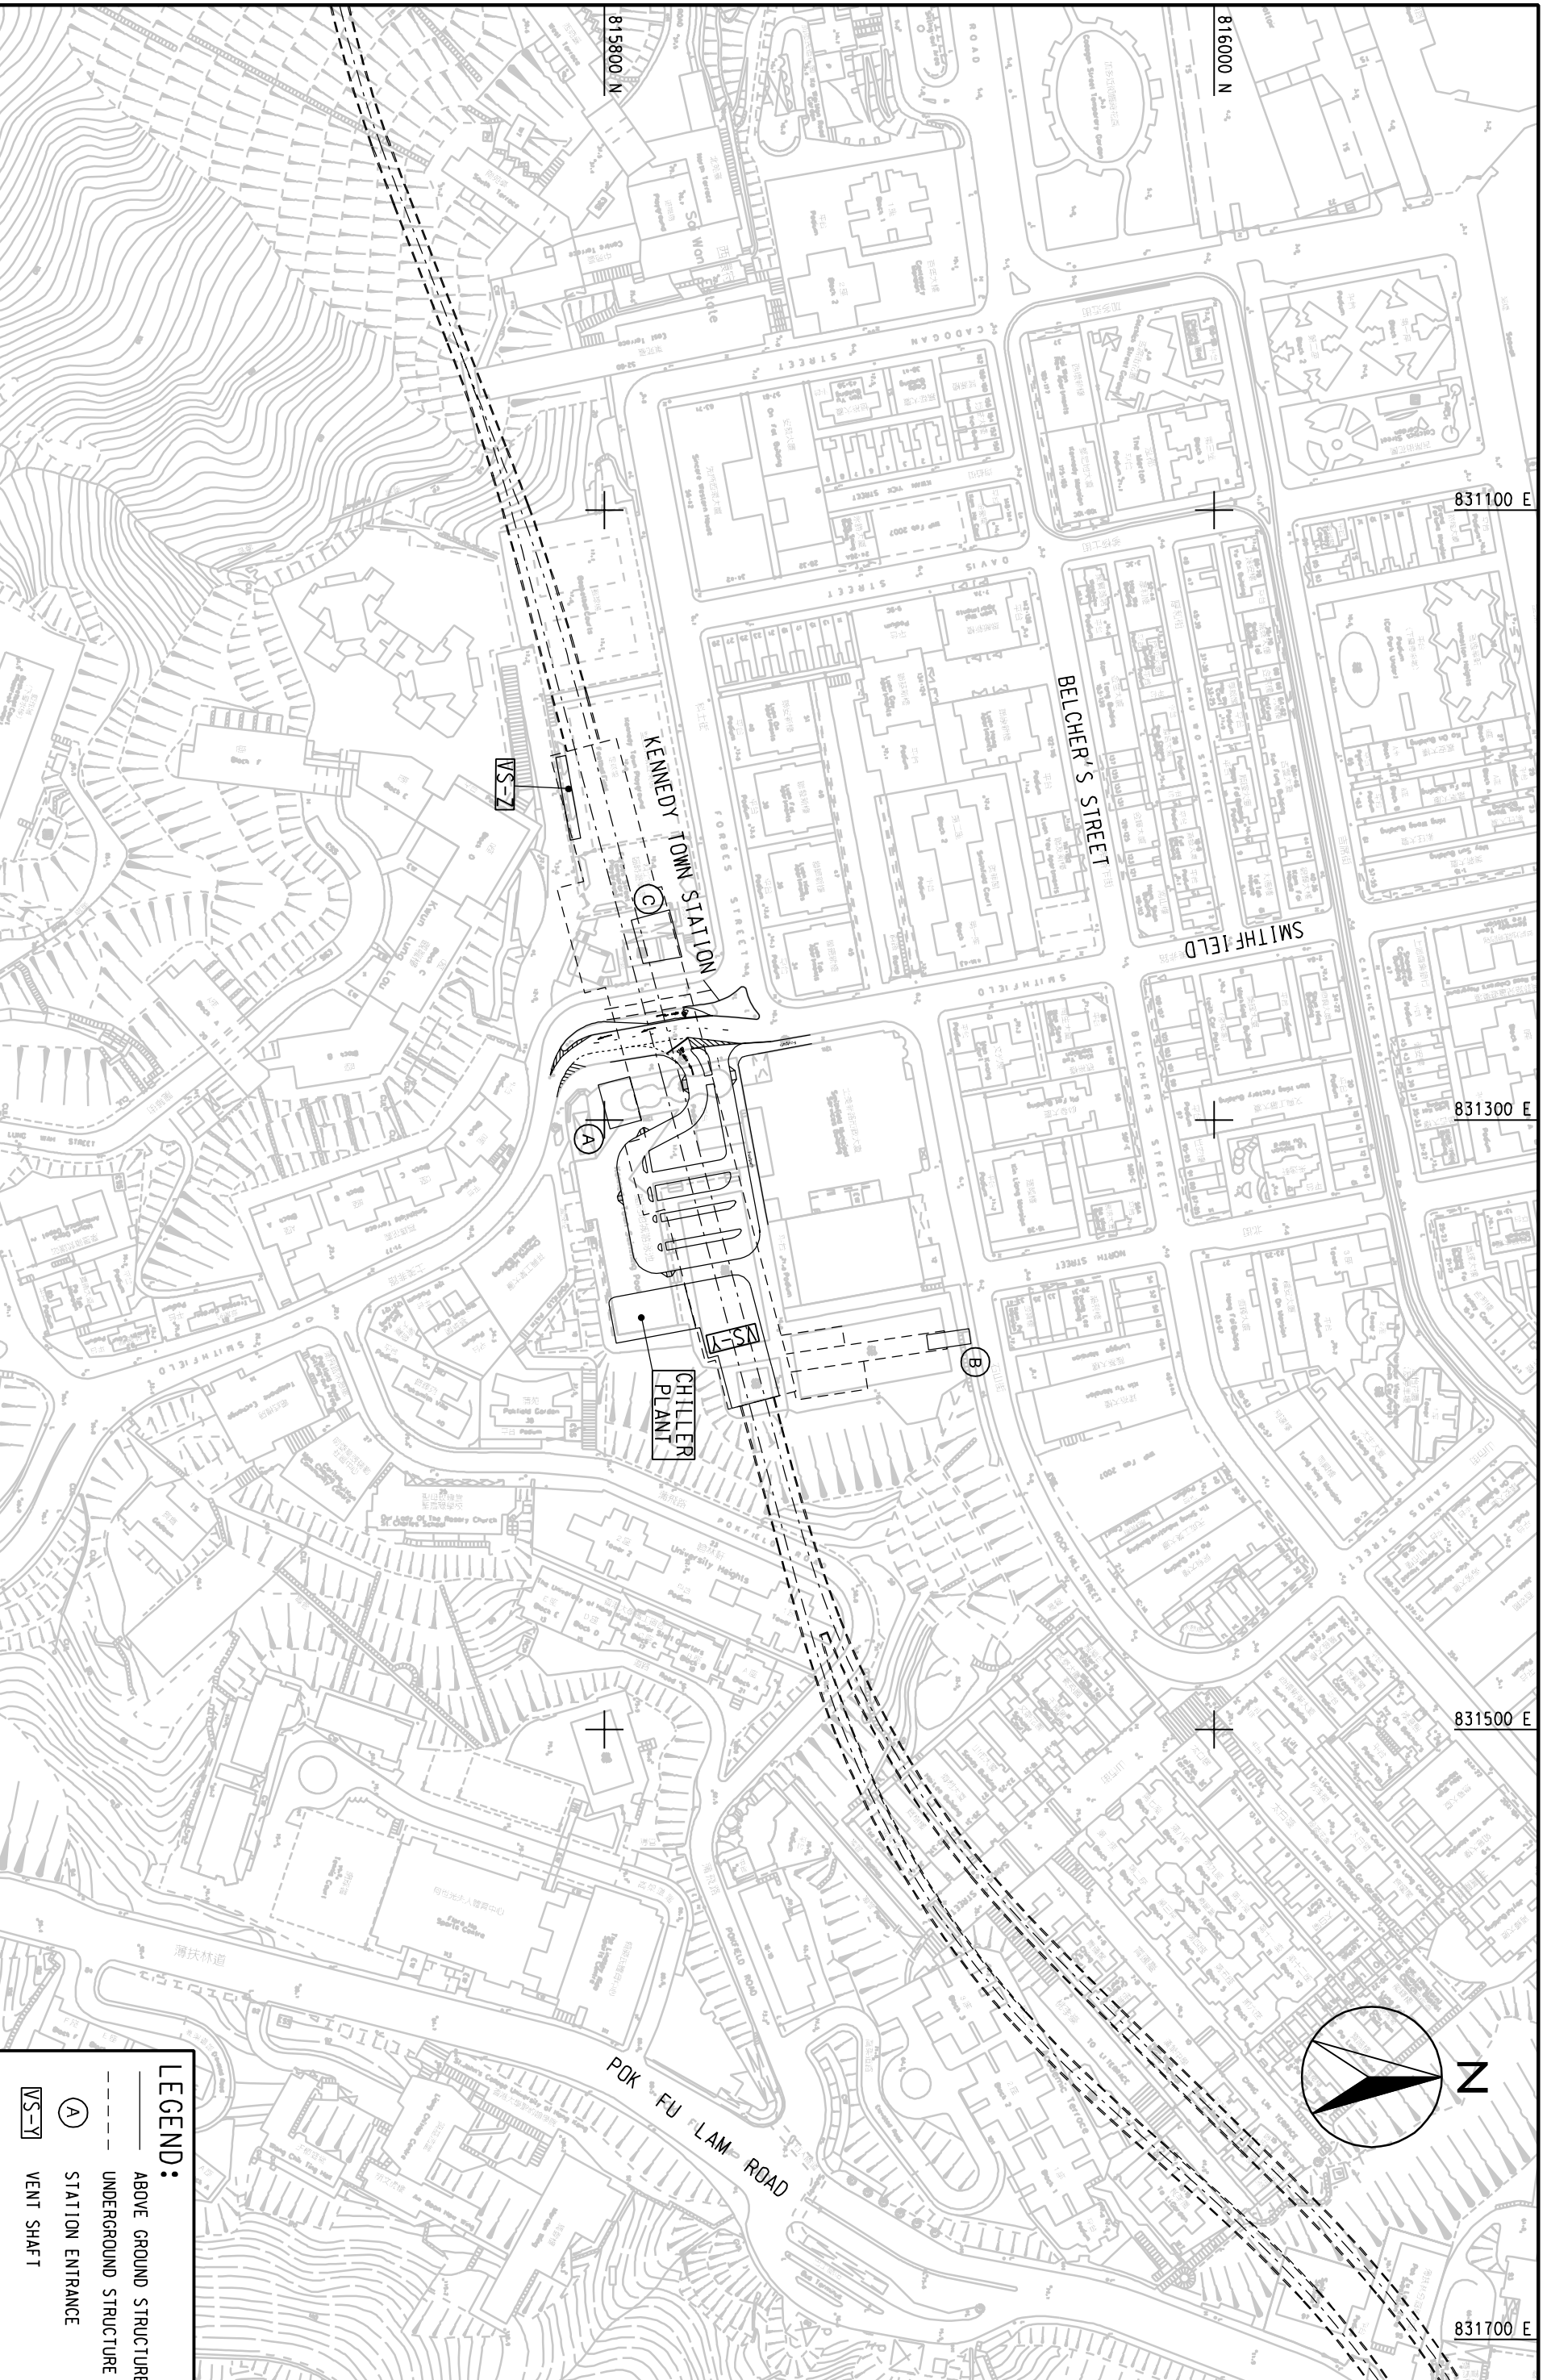

**LEGEND:**

- ABOVE GROUND STRUCTURE
- - - UNDERGROUND STRUCTURE
- (A) STATION ENTRANCE
- NS-7 VENT SHAFT