


- LEGEND:
- SURFACE CHANNEL
 - WEEPHOLE LOCATION AT EVERY 2M C/C
 - DIRECTION OF WATER FLOW
 - SUMP
 - PLANTING AREA
 - BRIDGE COLUMN

DRAINAGE PLAN
(SCALE 1 : 400)

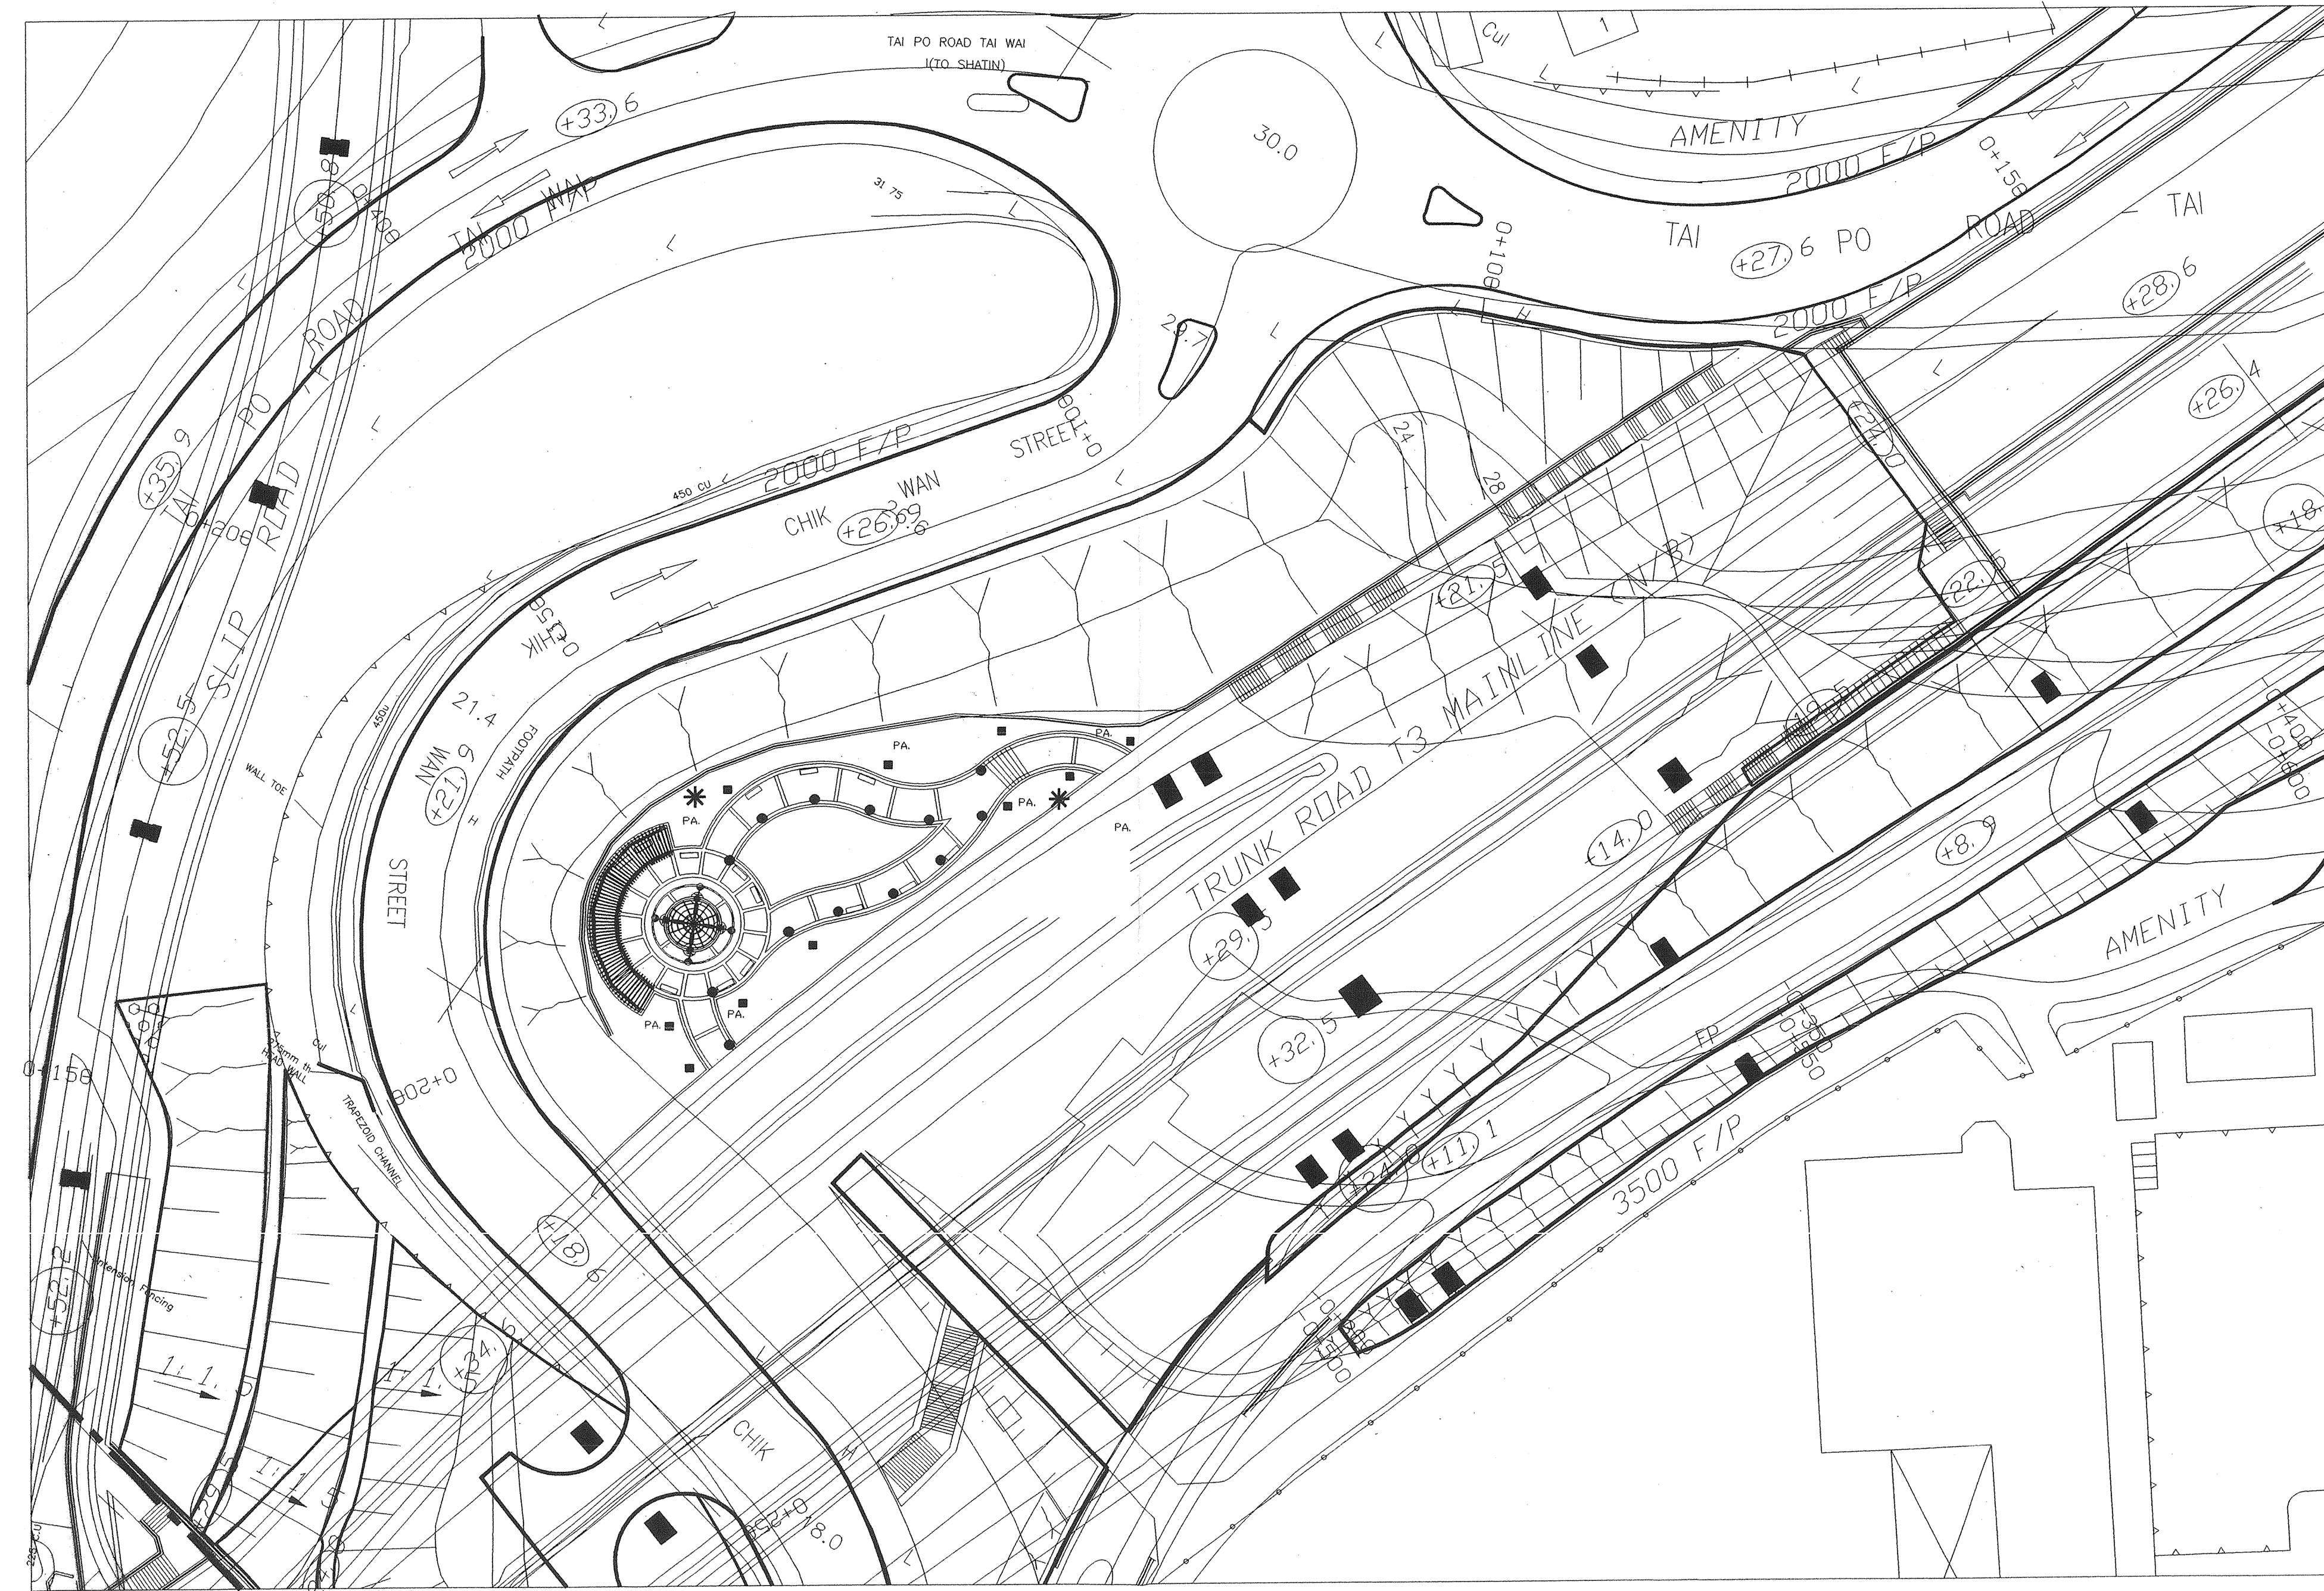

- LEGEND:
- BOLLARD LIGHT
 - POLE LIGHT
 - WALL MOUNTED LIGHT
 - WATER POINT @ 40 M O.C.
 - BRIDGE COLUMN
 - PLANTING AREA

LIGHTING PLAN
(SCALE 1 : 400)

A GENERAL REVISION		T73-RNG	OCT 02
- FIRST ISSUE		T73-PCA	RJG 9.2000
REV. 修改	DESCRIPTION 內容摘要	CHK. 校核	APPROVED 審定人
Territory Development Department 拓展署			
NT EAST DEVELOPMENT OFFICE 新界東拓展處			
SHA TIN NEW TOWN, STAGE II			
ROAD T3 AND ASSOCIATED ROADWORKS			
CHIK WAN STREET REST GARDEN LIGHTING AND DRAINAGE PLAN			
地制 TEAM 73 HK LANDSCAPE ARCHITECTS & ENVIRONMENTAL PLANNERS 地制環境顧問事務所			
MAUNSELL CONSULTANTS ASIA LTD. 茂盛亞洲工程顧問有限公司			
DWG. NO. 圖紙編號 PR63494/2103 ^A			
DESIGNED BY 設計	TEAM 73 HK	CONTRACT NO. 合約編號	DATE OF ISSUE 發出日期
DRAWN BY 繪圖	CS	STATUS 階段	ST79/02
SCALE 比例	AS SHOWN	Preliminary Drawing 初步圖樣	
DIMENSIONS ARE IN 尺寸單位 MILLIMETER 毫米			
© COPYRIGHT RESERVED 版權所有			

Maunsell