



Appendix III

Compensatory Tree Planting & Transplanting Plans & Mitigation Measures



Drawing List

Potential Sites of Compensatory Tree Planting and Transplanting

Drawing	Revision	Title
C8001/T/XRL/URB/C04/151	A4	Compensatory Tree Proposal Key Plan for Sham Shui Po District
C8001/T/XRL/URB/C04/152	A4	Compensatory Tree Proposal for Sham Shui Po District (Sheet 1 of 5)
C8001/T/XRL/URB/C04/153	A4	Compensatory Tree Proposal for Sham Shui Po District (Sheet 2 of 5)
C8001/T/XRL/URB/C04/154	A4	Compensatory Tree Proposal for Sham Shui Po District (Sheet 3 of 5)
C8001/T/XRL/URB/C04/155	A4	Compensatory Tree Proposal for Sham Shui Po District (Sheet 4 of 5)
C8001/T/XRL/URB/C04/156	A4	Compensatory Tree Proposal for Sham Shui Po District (Sheet 5 of 5)

Planting Plan for Sham Shui Po District

Drawing	Revision	Title
820/T/380/ATK/A58/852	B	Landscape Plan (Sheet 1 of 12)
820/T/380/ATK/A58/853	B	Landscape Plan (Sheet 2 of 12)
820/T/380/ATK/A58/854	B	Landscape Plan (Sheet 3 of 12)
820/T/380/ATK/A58/855	B	Landscape Plan (Sheet 4 of 12)
820/T/380/ATK/A58/856	B	Landscape Plan (Sheet 5 of 12)
820/T/380/ATK/A58/857	B	Landscape Plan (Sheet 6 of 12)
820/T/380/ATK/A58/858	B	Landscape Plan (Sheet 7 of 12)
820/T/380/ATK/A58/859	B	Landscape Plan (Sheet 8 of 12)
820/T/380/ATK/A58/860	B	Landscape Plan (Sheet 9 of 12)
820/T/380/ATK/A58/861	B	Landscape Plan (Sheet 10 of 12)
820/T/380/ATK/A58/862	B	Landscape Plan (Sheet 11 of 12)
820/T/380/ATK/A58/863	B	Landscape Plan (Sheet 12 of 12)
820/T/380/ATK/A58/864	A	Soiling Plan (Sheet 1 of 9)
820/T/380/ATK/A58/865	A	Soiling Plan (Sheet 2 of 9)
820/T/380/ATK/A58/866	A	Soiling Plan (Sheet 3 of 9)
820/T/380/ATK/A58/867	A	Soiling Plan (Sheet 4 of 9)
820/T/380/ATK/A58/868	A	Soiling Plan (Sheet 5 of 9)
820/T/380/ATK/A58/869	A	Soiling Plan (Sheet 6 of 9)
820/T/380/ATK/A58/870	A	Soiling Plan (Sheet 7 of 9)
820/T/380/ATK/A58/871	A	Soiling Plan (Sheet 8 of 9)
820/T/380/ATK/A58/872	A	Soiling Plan (Sheet 9 of 9)
820/T/380/ATK/A58/880	A	Planting Plan (Sheet 1 of 11)
820/T/380/ATK/A58/881	A	Planting Plan (Sheet 2 of 11)
820/T/380/ATK/A58/882	A	Planting Plan (Sheet 3 of 11)
820/T/380/ATK/A58/883	A	Planting Plan (Sheet 4 of 11)
820/T/380/ATK/A58/884	A	Planting Plan (Sheet 5 of 11)
820/T/380/ATK/A58/885	A	Planting Plan (Sheet 6 of 11)
820/T/380/ATK/A58/886	A	Planting Plan (Sheet 7 of 11)

820/T/380/ATK/A58/887	A	Planting Plan (Sheet 8 of 11)
820/T/380/ATK/A58/888	A	Planting Plan (Sheet 9 of 11)
820/T/380/ATK/A58/889	A	Planting Plan (Sheet 10 of 11)
820/T/380/ATK/A58/890	A	Planting Plan (Sheet 11 of 11)
820/T/380/ATK/A58/829	C	Planting Plan - DSD Culvert YC2 Works Area
820/T/380/ATK/A58/830	B	Landscape Plan - Sham Mong Road / Yuet Lun Street Works Area
820/T/380/ATK/A58/831	B	Landscape Plan - Near Aqua Marine
820/T/380/ATK/A58/833	C	Landscape Plan - at Shum Mong Road / Hing Wah Street West

Planting Plan for Nam Cheong Ventilation Building (VB7)

Drawing	Revision	Title
820/T/NCV/ATK/A58/800	B	General Notes and Abbreviations
820/T/NCV/ATK/A58/801	C	General Legend
* 820/W/NCV/ATK/A58/843	B1	Landscape Planting Plan
* 820/W/NCV/ATK/A58/844	B1	Landscape Soiling Plan
820/T/NCV/ATK/A58/845	B	Landscape Plan - Upper Roof
820/T/NCV/ATK/A58/846	C1	Utility Plan - Upper Floor
820/T/NCV/ATK/A58/847	C1	Soiling Plan - Upper Roof
820/T/NCV/NCV/A58/856	B1	Landscape Detail - Upper Roof Details

*Remark: Drawings with * are addendum page.*



Landscape Plan for Nam Cheong Park (Portion affected previously by Kowloon South Link Project) endorsed by LCSD




KDB400/LA/08001	0	Plant Schedule
KDB400/LA/08010	0	Landscape General Arrangement Plan (1 of 1)
KDB400/LA/08011	0	Landscape General Arrangement Plan (1 of 2)
KDB400/LA/08020	0	Level Plan
KDB400/LA/08021	0	Level Plan
KDB400/LA/08030	0	Lighting Plan
KDB400/LA/08031	0	Lighting Plan
KDB400/LA/08040	0	Material Plan
KDB400/LA/08041	0	Material Plan
KDB400/LA/08042	0	Material Schedule
KDB400/LA/08080	0	Planting Plan - Trees
KDB400/LA/08081	0	Planting Plan - Trees
KDB400/LA/08090	0	Planting Plan - Shurbs
KDB400/LA/08091	0	Planting Plan - Shurbs
KDB400/LA/08100	0	Sections through Tunnel
KDB400/LA/08101	0	Sections through Tunnel
KDB400/LA/08102	0	Detailed Sections
KDB400/LA/08103	2	Detailed Sections
KDB400/LA/08104	0	Febbe Walking Trail Signage
KDB400/LA/08106	0	Pergola Detail
KDB400/LA/08111	1	Landscape Details - Softworks
KDB400/LA/08130	0	Lighting Detail
KDB400/LA/08140	0	Landscape Details - Hardworks
KDB400/LA/08141	0	Landscape Details - Hardworks
KDB400/LA/08484	0	Yau Ma Tei Ventilation Building to Hoi Fai Road Tree Protection Plan
KDB400/SB/02831	0	Pergola Footing Plan - Reinforcement and Stell Work Details
KDB400/SB/02832	0	Planting Retaining Wall General Layout Plan and Reinforcement Details

# 820/T/380/ATK/A58/862	B	Landscape Plan (Sheet 11 of 12)
# 820/T/380/ATK/A58/863	B	Landscape Plan (Sheet 12 of 12)
# 820/T/380/ATK/A58/864	A	Soiling Plan (Sheet 1 of 9)

Remark: Drawings with # are provided in other section under the Appendix III.

Landscape Plan for Nam Cheong Park (Portion to be affected by XRL project)

Drawing	Revision	Title
# C8001/T/XRL/URB/C04/152	A4	Compensatory Tree Proposal for Sham Shui Po District (Sheet 1 of 5)
820/T/380/ATK/A58/824	B	Planting Plan
# 820/T/380/ATK/A58/852	B	Landscape Plan (Sheet 2 of 12)
# 820/T/380/ATK/A58/853	B	Landscape Plan (Sheet 3 of 12)

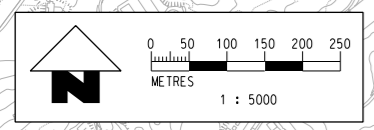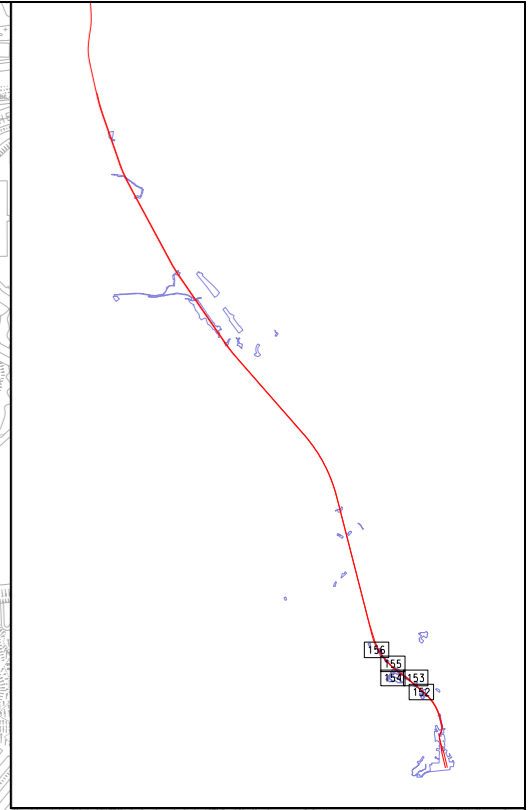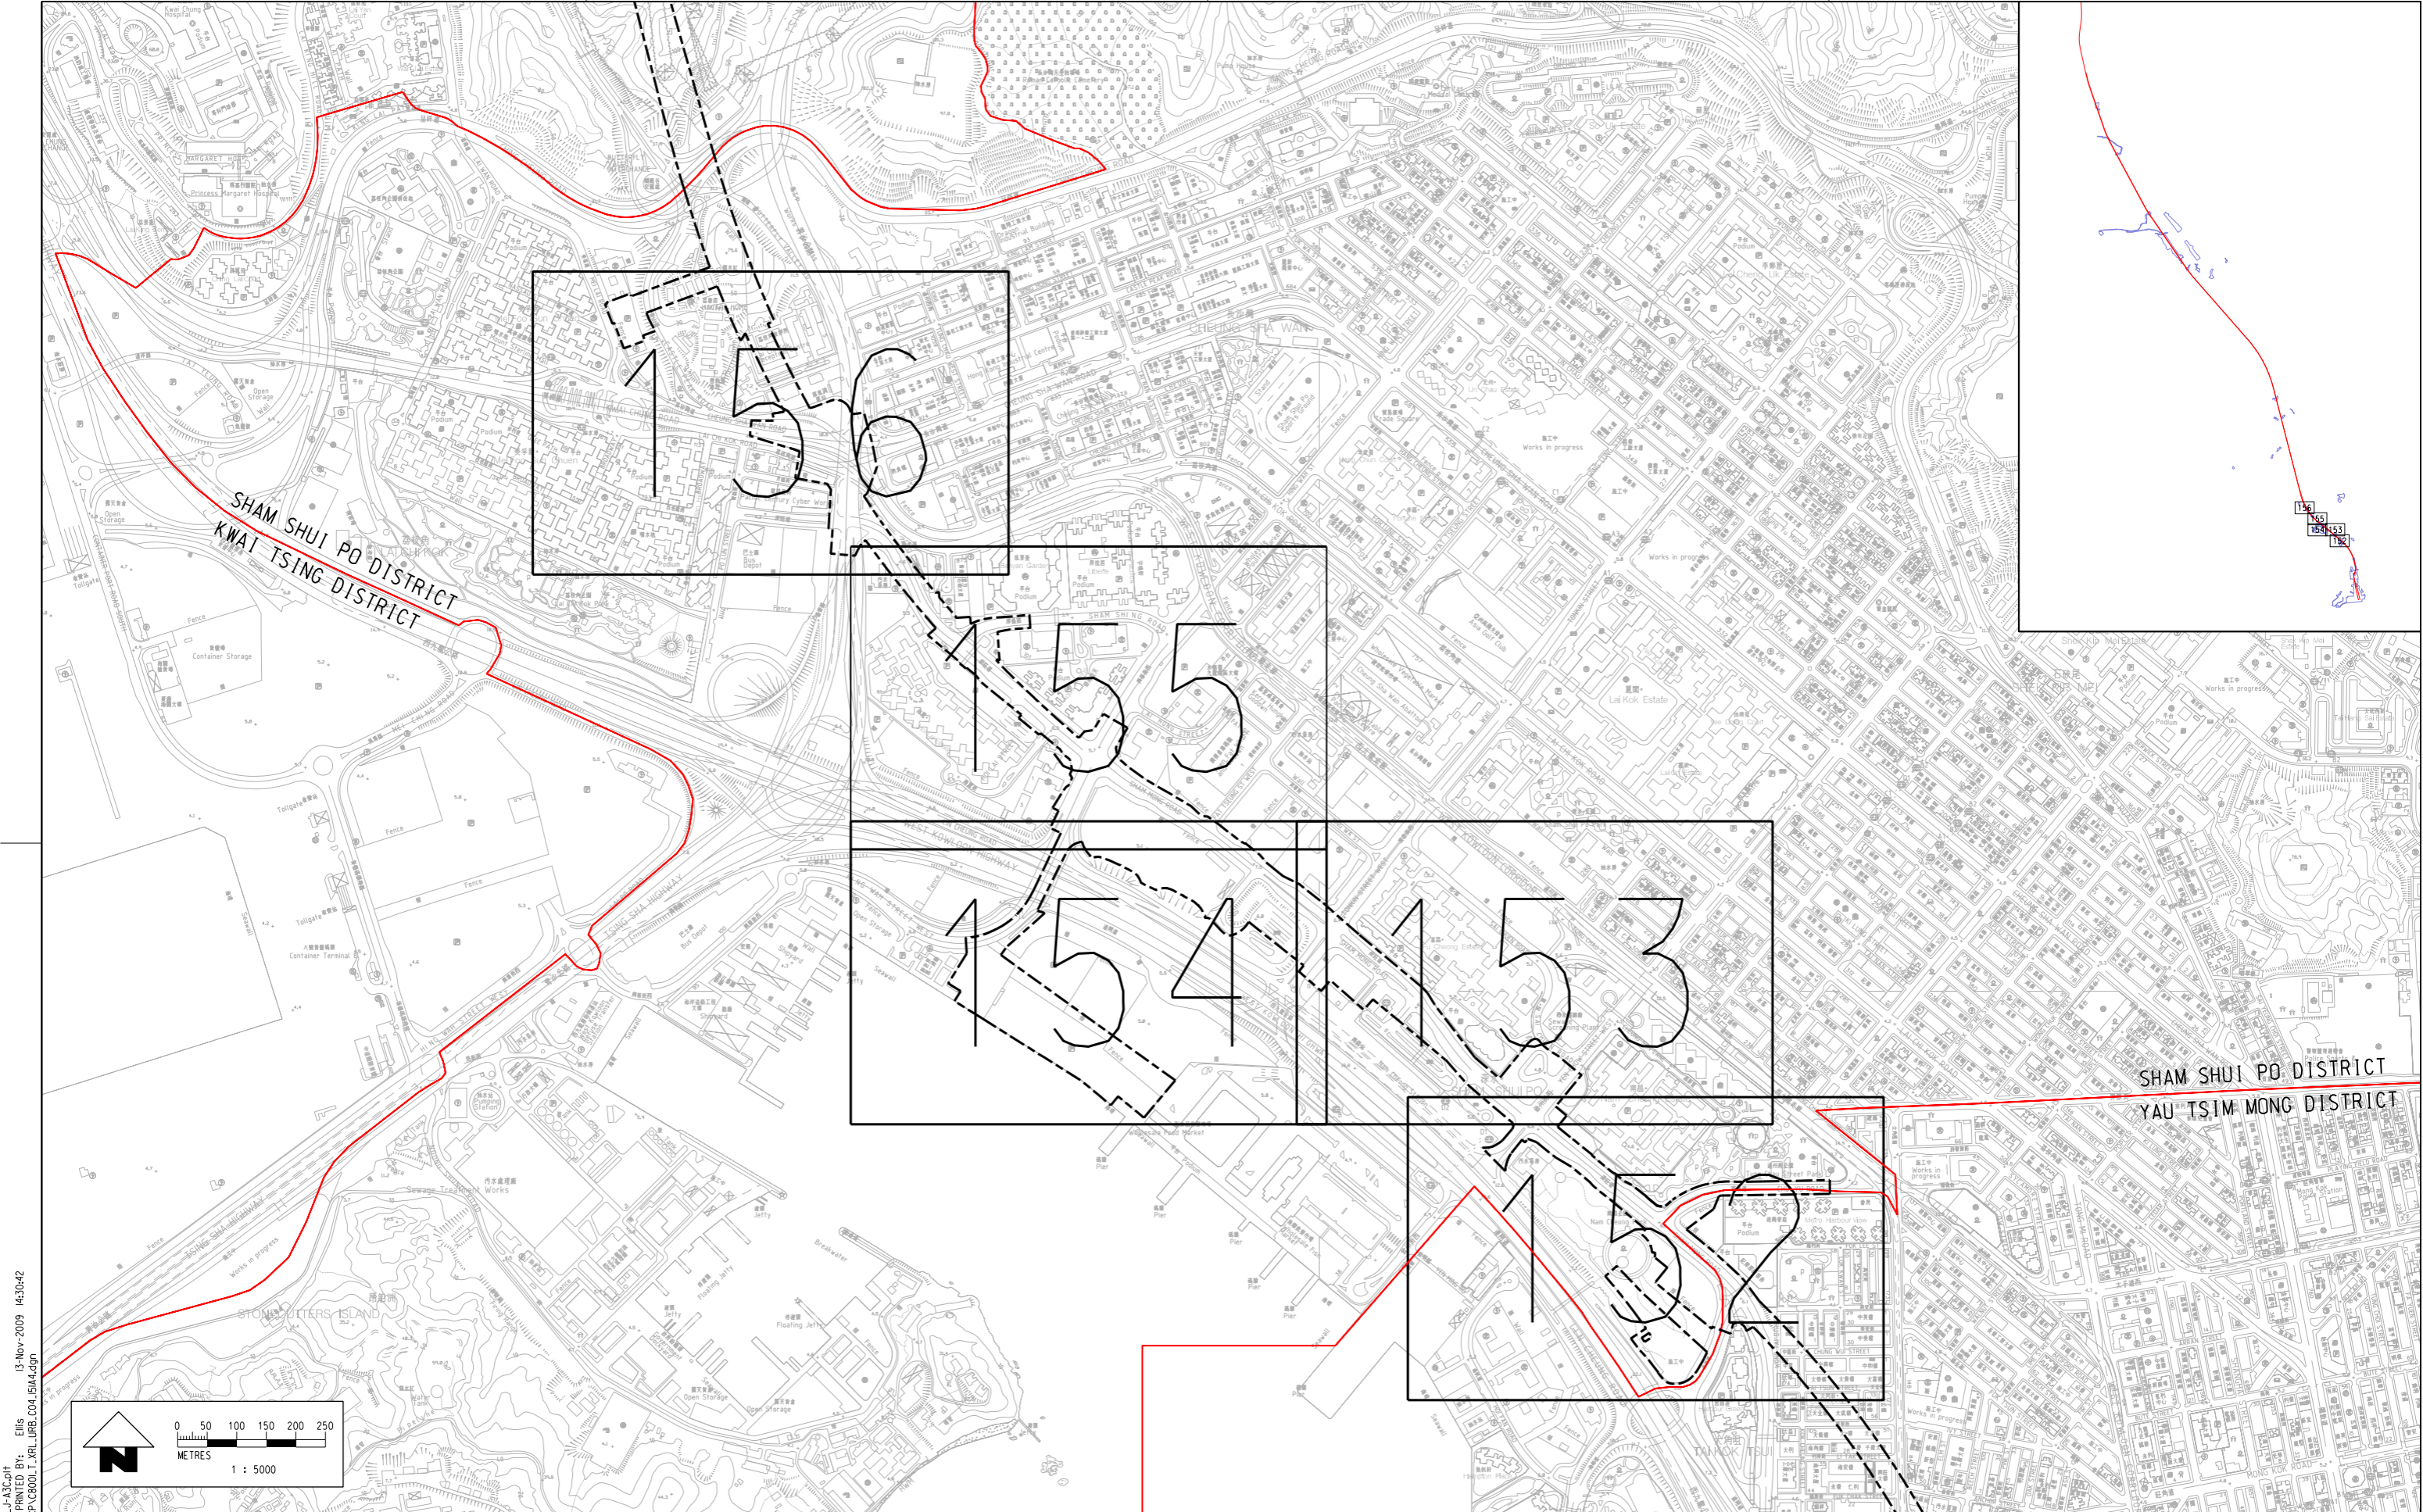



PLOT DRW: J:\ASCL\PL01\DRY\HPLU-A3C.dwg
 MODELNAME: Defouit
 FILENAME: I:\MTR\23\DON-GA-CP\C8001_XRL_URB_C04_15A4.dgn
 13-Nov-2009 14:30:42
 ELLS

REV	DESCRIPTION	BY	DATE	APPROVED
A4	FOURTH ISSUE	SAN	13NOV09	AD
A3	THIRD ISSUE	SAN	27OCT09	AD
A2	SECOND ISSUE	SAN	09JUN09	AD
A1	FIRST ISSUE	SAN	30APR09	AD

REV	DESCRIPTION	BY	DATE	APPROVED
A4	FOURTH ISSUE	SAN	13NOV09	AD
A3	THIRD ISSUE	SAN	27OCT09	AD
A2	SECOND ISSUE	SAN	09JUN09	AD
A1	FIRST ISSUE	SAN	30APR09	AD

DRAWN	SAN
DESIGNED	JP
CHECKED	TO
APPROVED	AD
DATE	30. APR. 2009


EXPRESS RAIL LINK (XRL)
 ORIGINATOR
 Planning, Urban Design, Landscape, Golf & Environmental Consultants
 Urbis Limited, 11/F Siu On Centre, 188 Lockhart Road, Wan Chai, Hong Kong.
 Tel 2802 3333 Fax 2802 8662


TITLE
 CONSULTANCY AGREEMENT NO. C8001
 TREE TRANSPLANTING / FELLING
 COMPENSATORY TREE PROPOSAL KEY PLAN
 FOR SHAM SHUI PO DISTRICT

SCALE: 1 : 5000 @ A1
 DRAWING NO.: C8001/T/XRL/URB/C04/151
 REV. A4

DO NOT SCALE DRAWINGS. ALL DIMENSIONS SHALL BE VERIFIED ON SITE.
 © MTR CORPORATION LIMITED 2008. COPYRIGHT IN RESPECT OF THIS DRAWING / DOCUMENT IS OWNED BY THE MTR CORPORATION LIMITED OF HONG KONG. NO REPRODUCTION OF THIS DRAWING / DOCUMENT OR ANY PART BY WHATEVER MEANS IS PERMITTED WITHOUT THE PRIOR WRITTEN CONSENT OF THE MTR CORPORATION LIMITED.

CADD REF. C8001_T_XRL_URB_C04_151A4.dgn

MATCH LINE

3 NOS. TRANSPLANTED TREES (5m SPACING)
3 NOS. CRA.UNI. (T8648, T8649 & T8650)

1 NO. TRANSPLANTED TREES
1 NO. DEL.REG. (T8654)

5 NOS. TRANSPLANTED TREES (5m SPACING)
5 NOS. ALE.MOL. (T8681, T8682, T8683, T8684 & T8685)

3 NOS. TRANSPLANTED TREES (5m SPACING)
3 NOS. MEI.OUI. (103/U0004, 103/U0005 & 103/U0007)

5 NOS. TRANSPLANTED TREES (5m SPACING)
3 NOS. MEI.OUI. (103/U0003, 103/U0006 & 103/U0008)
2 NOS. ROY.REG. (103/U0009 & 103/U0010)

69 NOS. TRANSPLANTED TREES (MIN. 2m SPACING)
1 NO. AIL.FOR. (T10012)
3 NOS. ALB.LEB. (T9851, T9897 & T9948)
2 NOS. ALE.MOL. (T9882 & T9891)
8 NOS. BAU.VAR. (T9845, T9846, T9847, T9848, T9894, T9911, T9912, T9913)
2 NOS. BOM.CEI. (T10003 & 103/U0002) 南昌公園
1 NO. CEL.SIN. (T9888)
1 NO. ITE.CHI. (T9924)
3 NOS. LIT.GLU. (T9996, T9998 & T10000)
10 NOS. GRE.ROB. (T9853, T9854, T9856, T9857, T9860, T9862, T9859, T10001, T10002 & 103/U0001)
3 NOS. PEL.PTE. (T9896, T9906 & T9908)
25 NOS. PON.PIN. (T9855, T9865, T9867, T9869, T9872, T9892, T9893, T9895, T9904, T9905, T9907, T9923, T9927, T9928, T9930, T9933, T9934, T9937, T9938, T9940, T9941, T9944, T9950, T10007 & T10011)
1 NO. SPA.CAM. (T9863)
3 NOS. LOP.CON. (T9844, T9866 & T9875)
1 NO. ACA.AUR. (T9868)
5 NOS. ACA.MAN. (T9870, T9889, T9898, T9931 & T9945)

4 NOS. TRANSPLANTED TREES (5m SPACING)
4 NOS. PEL.PTE. (T8838, T8841, T8843 & T8844)

6 NOS. TRANSPLANTED TREES (5m SPACING)
2 NOS. MEL.OUI. (T8836 & T8839)
3 NOS. CIN.CAM. (T8837, T8840 & T8842)
1 NO. SPA.CAM. (T8845)

 
2 NOS. TRANSPLANTED TREES (5m SPACING)
1 NO. CIN.CAM. (T8846)
1 NO. MEI.OUI. (T8847)

4 NOS. TRANSPLANTED TREES (MIN. 4m SPACING)
2 NOS. FIC.MIC. (T8873 & T8874)
2 NOS. PEL.PTE. (T8875 & T8876)

3 NOS. TRANSPLANTED TREES (5m SPACING)
2 NOS. PEL.PTE. (T8870 & T8871)
1 NO. CIN.CAM. (T8877)

- LEGEND**
- DISTRICT BOUNDARY
 - GAZETTL BOUNDARY
 - EXISTING TREES RETAINED
 - TREES OUTSIDE GAZETTL BOUNDARY
 - PROPOSED AREAS FOR COMPENSATORY TREE PLANTING AT THE END OF WORKS CONTRACT
 - PROPOSED AREAS FOR TRANSPLANTING RECEPTOR SITES AT THE END OF WORKS CONTRACT


- NOTE:**
1. TONE AND TREE SYMBOLS ARE INDICATIVE ONLY.
 2. FINAL LOCATIONS OF TRANSPLANTED TREES SUBJECT TO DETAILED DESIGN.
 3. FOR TOTAL NUMBERS OF COMPENSATORY TREE PLANTING REQUIRED WITHIN SUM SHUI PO DISTRICT, REFER TO TABLE 3.4



DRAWN		SAN		<p>EXPRESS RAIL LINK (XRL)</p> <p>ORIGINATOR Planning, Urban Design, Landscape, Golf & Environmental Consultants Urbis Limited, 11/F Siu On Centre, 188 Lockhart Road, Wan Chai, Hong Kong. Tel 2802 3333 Fax 2802 8662</p> <p>CADD REF. C8001_T_XRL_URB_C04_152A4.dgn</p>
DESIGNED		JP		
CHECKED		TO		
APPROVED		AD		
DATE		30. APR. 2009		
A4	FOURTH ISSUE	SAN	13NOV09	AD
A3	THIRD ISSUE	SAN	27OCT09	AD
A2	SECOND ISSUE	SAN	09JUN09	AD
A1	FIRST ISSUE	SAN	30APR09	AD


TITLE		CONSULTANCY AGREEMENT NO. C8001	
		TREE TRANSPLANTING / FELLING	
		COMPENSATORY TREE PROPOSAL FOR SHAM SHUI PO DISTRICT	
		(SHEET 1 OF 5)	
SCALE	DRAWING NO.	REV.	
1 : 1000 @ A1	C8001/T/XRL/URB/C04/152	A4	

PLOT DRW: J:\ASCL\PL01\DRW\HPLU-A3C.dwg
MODELNAME: Defouit
FILENAME: I:\MTR\23\DON-GA\CP\C8001_T_XRL\URB_C04_152A4.dgn
16-Nov-2009 12:58:08
EHS

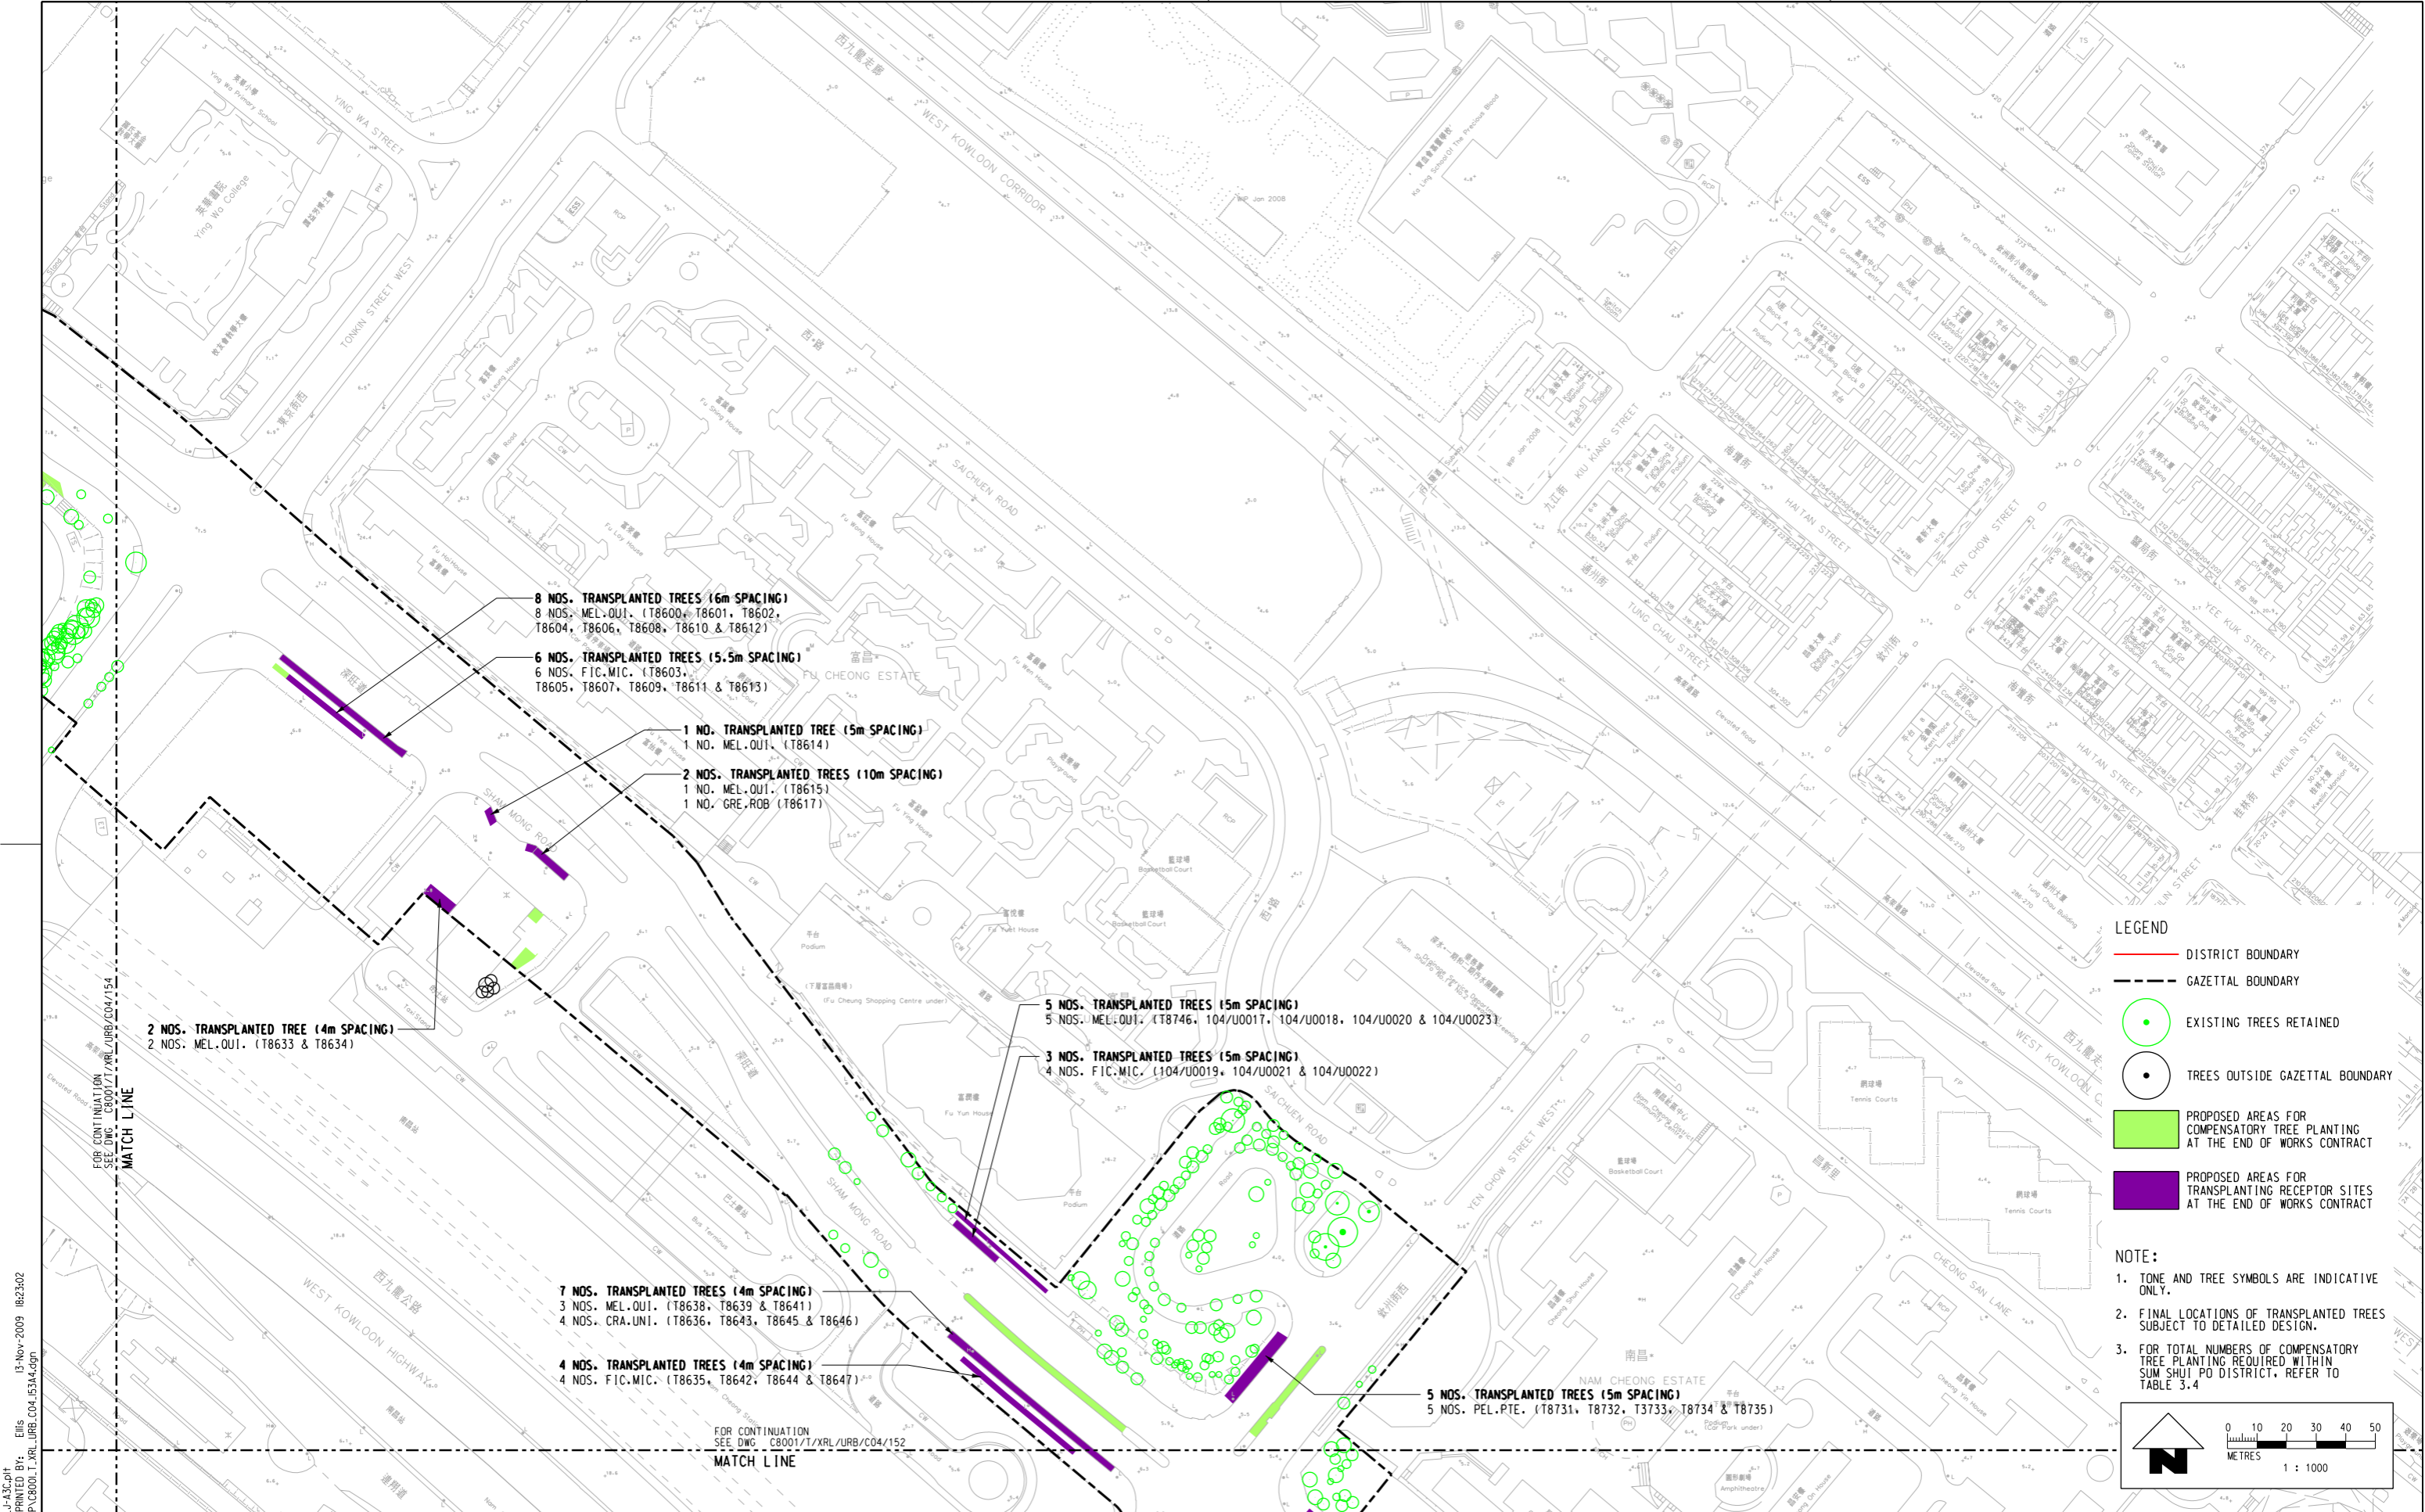

- LEGEND**
- DISTRICT BOUNDARY
 - GAZETTAL BOUNDARY
 - EXISTING TREES RETAINED
 - TREES OUTSIDE GAZETTAL BOUNDARY
 - PROPOSED AREAS FOR COMPENSATORY TREE PLANTING AT THE END OF WORKS CONTRACT
 - PROPOSED AREAS FOR TRANSPLANTING RECEPTOR SITES AT THE END OF WORKS CONTRACT

 - NOTE:**
1. TONE AND TREE SYMBOLS ARE INDICATIVE ONLY.
 2. FINAL LOCATIONS OF TRANSPLANTED TREES SUBJECT TO DETAILED DESIGN.
 3. FOR TOTAL NUMBERS OF COMPENSATORY TREE PLANTING REQUIRED WITHIN SUM SHUI PO DISTRICT, REFER TO TABLE 3.4



PLOT DRY: J:\ASCL\PL01\DRY\HPLU-A3C.dwg
 MODELNAME: Defoult
 FILENAME: I:\MTR\23\DON-GA\CP\C8001.T.XRL\URB.C04.153A4.dgn
 13-Nov-2009 18:23:02
 EHS

REV	DESCRIPTION	BY	DATE	APPROVED	REV	DESCRIPTION	BY	DATE	APPROVED
A4	FOURTH ISSUE	SAN	13NOV09	AD					
A3	THIRD ISSUE	SAN	27OCT09	AD					
A2	SECOND ISSUE	SAN	09JUN09	AD					
A1	FIRST ISSUE	SAN	30APR09	AD					

DRAWN	SAN
DESIGNED	JP
CHECKED	TO
APPROVED	AD
DATE	30.APR.2009
MTR	
EXPRESS RAIL LINK (XRL)	
ORIGINATOR	
Planning, Urban Design, Landscape, Golf & Environmental Consultants	
Urbis Limited, 11/F Siu On Centre, 188 Lockhart Road, Wan Chai, Hong Kong.	
Tel 2802 3333 Fax 2802 8662	
CADD REF.	C8001.T.XRL_URB.C04.153A4.dgn

TITLE	
CONSULTANCY AGREEMENT NO. C8001	
TREE TRANSPLANTING / FELLING	
COMPENSATORY TREE PROPOSAL FOR SHAM SHUI PO DISTRICT	
(SHEET 2 OF 5)	
SCALE	DRAWING NO.
1 : 1000 @ A1	C8001/T/XRL/URB/C04/153
REV.	A4

FOR CONTINUATION
SEE DWG. C8001/T/XRL/URB/C04/155
MATCH LINE







REFER TO APPENDIX 3
FOR PLANTING TO VB7

2 NOS. TRANSPLANTED TREES (4m SPACING)
2 NOS. MEL.OUI. (T10919, & T10920)

1 NO. TRANSPLANTED TREES
1 NO. CEL.SIN. (T19147)

 
FOR CONTINUATION
SEE DWG. C8001/T/XRL/URB/C04/153
MATCH LINE

LEGEND

-  DISTRICT BOUNDARY
-  GAZETTED BOUNDARY
-  EXISTING TREES RETAINED
-  TREES OUTSIDE GAZETTED BOUNDARY
-  PROPOSED AREAS FOR COMPENSATORY TREE PLANTING AT THE END OF WORKS CONTRACT
-  PROPOSED AREAS FOR TRANSPLANTING RECEPTOR SITES AT THE END OF WORKS CONTRACT

NOTE:

1. TONE AND TREE SYMBOLS ARE INDICATIVE ONLY.
2. FINAL LOCATIONS OF TRANSPLANTED TREES SUBJECT TO DETAILED DESIGN.
3. FOR TOTAL NUMBERS OF COMPENSATORY TREE PLANTING REQUIRED WITHIN SUM SHUI PO DISTRICT, REFER TO TABLE 3.4



PLOT DRW: J:\ASCL\PL01\DRY\HPLU-A3C.dwg
 MODELNAME: Defouit
 FILENAME: I:\MTR\23\DON-GA\CP\C8001_T_XRL_URB_C04_154A4.dgn
 13-Nov-2009 18:24:03

REV	DESCRIPTION	BY	DATE	APPROVED	REV	DESCRIPTION	BY	DATE	APPROVED
A4	FOURTH ISSUE	SAN	13NOV09	AD					
A3	THIRD ISSUE	SAN	27OCT09	AD					
A2	SECOND ISSUE	SAN	09JUN09	AD					
A1	FIRST ISSUE	SAN	30APR09	AD					

DRAWN	SAN
DESIGNED	JP
CHECKED	TO
APPROVED	AD
DATE	30.APR.2009

MTR

EXPRESS RAIL LINK (XRL)

ORIGINATOR
 Planning, Urban Design, Landscape, Golf & Environmental Consultants
 Urbis Limited, 11/F Siu On Centre, 188 Lockhart Road, Wan Chai, Hong Kong.
 Tel 2802 3333 Fax 2802 8662

CADD REF. C8001_T_XRL_URB_C04_154A4.dgn

TITLE

**CONSULTANCY AGREEMENT NO. C8001
 TREE TRANSPLANTING / FELLING
 COMPENSATORY TREE PROPOSAL FOR SHAM SHUI PO DISTRICT
 (SHEET 3 OF 5)**

SCALE 1 : 1000 @ A1

DRAWING NO. C8001/T/XRL/URB/C04/154

REV. A4

DO NOT SCALE DRAWINGS. ALL DIMENSIONS SHALL BE VERIFIED ON SITE.
 © MTR CORPORATION LIMITED 2008. COPYRIGHT IN RESPECT OF THIS DRAWING / DOCUMENT IS OWNED BY THE MTR CORPORATION LIMITED OF HONG KONG. NO REPRODUCTION OF THE DRAWING / DOCUMENT OR ANY PART BY WHATEVER MEANS IS PERMITTED WITHOUT THE PRIOR WRITTEN CONSENT OF THE MTR CORPORATION LIMITED.

PLOT DRW: J:\ASCL\PL\OTDR\HPLU-A3C.dwg
 MODELNAME: DefOut
 FILENAME: I:\MTR\23\DON-GA-CP\C8001.T.XRL\URB_C04_155A4.dgn
 13-Nov-2009 16:24:34
 EHS

FOR CONTINUATION
 SEE DWG. C8001/T/XRL/URB/C04/156
 MATCH LINE

- 8 NOS. TRANSPLANTED TREES (2m SPACING)**
 1 NO. CAM.SEM. (109/U0024)
 1 NO. CAM.OLE. (109/U0030)
 1 NO. CER.MAN. (109/U0029)
 1 NO. ELA.CHI. (109/U0027)
 1 NO. ELA.DEC. (109/U0028)
 1 NO. LIG.LUC. (109/U0025)
 1 NO. STE.LAN. (109/U0023)
 1 NO. TEM.GYM. (109/U0026)

- 5 NOS. TRANSPLANTED TREES (6m SPACING)**
 3 NOS. FIC.MIC. (T9428, T9441 & T9442)
 2 NOS. MIC.ALB. (T9429 & T9430)

- 2 NOS. TRANSPLANTED TREES (3m SPACING)**
 2 NOS. FIC.VAR.SUB (T9443 & T9444)

- 3 NOS. TRANSPLANTED TREES (5m SPACING)**
 3 NOS. MIC.ALB. (T9456, T6457 & T9458)

- 17 NOS. TRANSPLANTED TREES (4m SPACING)**
 2 NOS. BAU.VAR. (T9466 & T9467)
 3 NOS. MAG.GRA. (T10586, T10587 & T10591)
 4 NOS. PEL.PTE. (T9462, T9463, T9464 & T9465)
 6 NOS. PLU.RUB. (T10582, T10583, T10584, T10588, T10590, T10592)
 2 NOS. PTE.IND. (T10580 & T10585)

- 2 NOS. TRANSPLANTED TREES (6m SPACING)**
 2 NOS. MEL.OUI. (T9405 & T9406)

- 2 NOS. TRANSPLANTED TREES (5m SPACING)**
 2 NOS. PEL.PTE. (T9471 & T9474)

- 3 NOS. TRANSPLANTED TREES (6m SPACING)**
 3 NOS. MEL.OUI. (T9400, T9402 & T9404)

- 2 NOS. TRANSPLANTED TREES (6m SPACING)**
 2 NOS. MEL.OUI. (T9401 & T9403)

- 8 NOS. TRANSPLANTED TREES (5m SPACING)**
 3 NOS. CIN.CAM. (T9475, T9489 & T9493)
 5 NOS. MEL.OUI. (T9487, T9488, T9490, T9491 & T9492)

- 11 NOS. TRANSPLANTED TREES (5m SPACING)**
 8 NOS. FIC.MIC. (T9479, T9480, T9481, T9482, T9483, T9484, T9485 & T9486)
 3 NOS. PEL.PTE. (T9476, T9477 & T9478)

- 2 NOS. TRANSPLANTED TREES (6m SPACING)**
 2 NOS. PEL.PTE. (108/U0038 & 108/U0040)

- 3 NOS. TRANSPLANTED TREES (10m SPACING)**
 3 NOS. CIN.CAM. (108/U0001, 108/U0036 & 108/U0039)

- 9 NOS. TRANSPLANTED TREES (3m SPACING)**
 6 NOS. FIC.MIC. (T10950, T10976, T10977, T10978, T10979 & T10980)
 3 NOS. PEL.PTE. (T10981, T10982 & T10983)

- 2 NOS. TRANSPLANTED TREES (5m SPACING)**
 2 NOS. MEL.OUI. (T10984 & T10985)

- 5 NOS. TRANSPLANTED TREES (6m SPACING)**
 5 NOS. MEL.OUI. (T10950, T10952, T10964, T10974 & T10975)

- 4 NOS. TRANSPLANTED TREES (5m SPACING)**
 4 NOS. MEL.OUI. (T10900, T10943, T10944 & T10945)

REFER TO APPENDIX 3 FOR PLANTING TO VB7

- 6 NOS. TRANSPLANTED TREES (6m SPACING)**
 6 NOS. FIC.VAR.SUB. (108/U0029, 108/U0030, 108/U0031, 108/U0032, 108/U0033 & 108/U0034)

- 7 NOS. TRANSPLANTED TREES (6m SPACING)**
 2 NOS. FIC.VAR.SUB. (108/U0021 & 108/U0022)
 5 NOS. FIC.MIC. (108/U0023, 108/U0024, 108/U0025, 108/U0026 & 108/U0027)

- 6 NOS. TRANSPLANTED TREES (5m SPACING)**
 6 NOS. FIC.VAR.SUB. (108/U0002, 108/U0003, 108/U0004, 108/U0005, 108/U0006 & 108/U0007)

- 3 NOS. TRANSPLANTED TREES (5.5m SPACING)**
 3 NOS. FIC.MIC. (108/U0009, 108/U0010 & 108/U0011)

- 4 NOS. TRANSPLANTED TREES (5m SPACING)**
 3 NOS. FIC.VAR.SUB. (T9200, T9201 & T9202)
 1 NO. MEL.OUI. (T9204)

- 14 NOS. TRANSPLANTED TREES (6m SPACING)**
 12 NOS. FIC.MIC. (T9206, T9207, T9208, T9209, T9212, T9223, T9225, T9226, T9227, T9229, T9231 & T9233)
 2 NOS. PEL.PTE. (T9203 & T9205)

- 5 NOS. TRANSPLANTED TREES (8m SPACING)**
 1 NO. FIC.MIC. (T9225)
 1 NO. GRE.ROB. (T9222)
 3 NOS. MEL.OUI. (T9210, T9211 & T9224)

- 3 NOS. TRANSPLANTED TREES (4m SPACING)**
 3 NOS. PEL.PTE. (T10927, T10928 & T10929)

 
FOR CONTINUATION
 SEE DWG. C8001/T/XRL/URB/C04/154
 MATCH LINE

LEGEND

- DISTRICT BOUNDARY
- GAZETTL BOUNDARY
- EXISTING TREES RETAINED
- TREES OUTSIDE GAZETTL BOUNDARY
- PROPOSED AREAS FOR COMPENSATORY TREE PLANTING AT THE END OF WORKS CONTRACT
- PROPOSED AREAS FOR TRANSPLANTING RECEPTOR SITES AT THE END OF WORKS CONTRACT

NOTE:

1. TONE AND TREE SYMBOLS ARE INDICATIVE ONLY.
2. FINAL LOCATIONS OF TRANSPLANTED TREES SUBJECT TO DETAILED DESIGN.
3. FOR TOTAL NUMBERS OF COMPENSATORY TREE PLANTING REQUIRED WITHIN SUM SHUI PO DISTRICT, REFER TO TABLE 3.4



REV	DESCRIPTION	BY	DATE	APPROVED	REV	DESCRIPTION	BY	DATE	APPROVED
A4	FOURTH ISSUE	SAN	13NOV09	AD					
A3	THIRD ISSUE	SAN	27OCT09	AD					
A2	SECOND ISSUE	SAN	09JUN09	AD					
A1	FIRST ISSUE	SAN	30APR09	AD					

DRAWN: SAN
 DESIGNED: JP
 CHECKED: TO
 APPROVED: AD
 DATE: 30.APR.2009

MTR

EXPRESS RAIL LINK (XRL)


ORIGINATOR
 Planning, Urban Design, Landscape, Golf & Environmental Consultants
 Urbis Limited, 11/F Siu On Centre, 188 Lockhart Road, Wan Chai, Hong Kong.
 Tel 2802 3333 Fax 2802 8662

CADD REF. C8001.T.XRL.URB.C04.155A4.dgn

TITLE
**CONSULTANCY AGREEMENT NO. C8001
 TREE TRANSPLANTING / FELLING
 COMPENSATORY TREE PROPOSAL FOR SHAM SHUI PO DISTRICT
 (SHEET 4 OF 5)**

SCALE: 1 : 1000 @ A1
 DRAWING NO. C8001/T/XRL/URB/C04/155
 REV. A4

PLOT DRW: J:\ASCL\PL01\DRY\HPLU-A3C.dwg
 MODELNAME: Default
 FILENAME: I:\MTR\23\DON-GA-CP\C8001.T_XRL_URB_C04_156A4.dgn
 13-Nov-2009 18:24:54

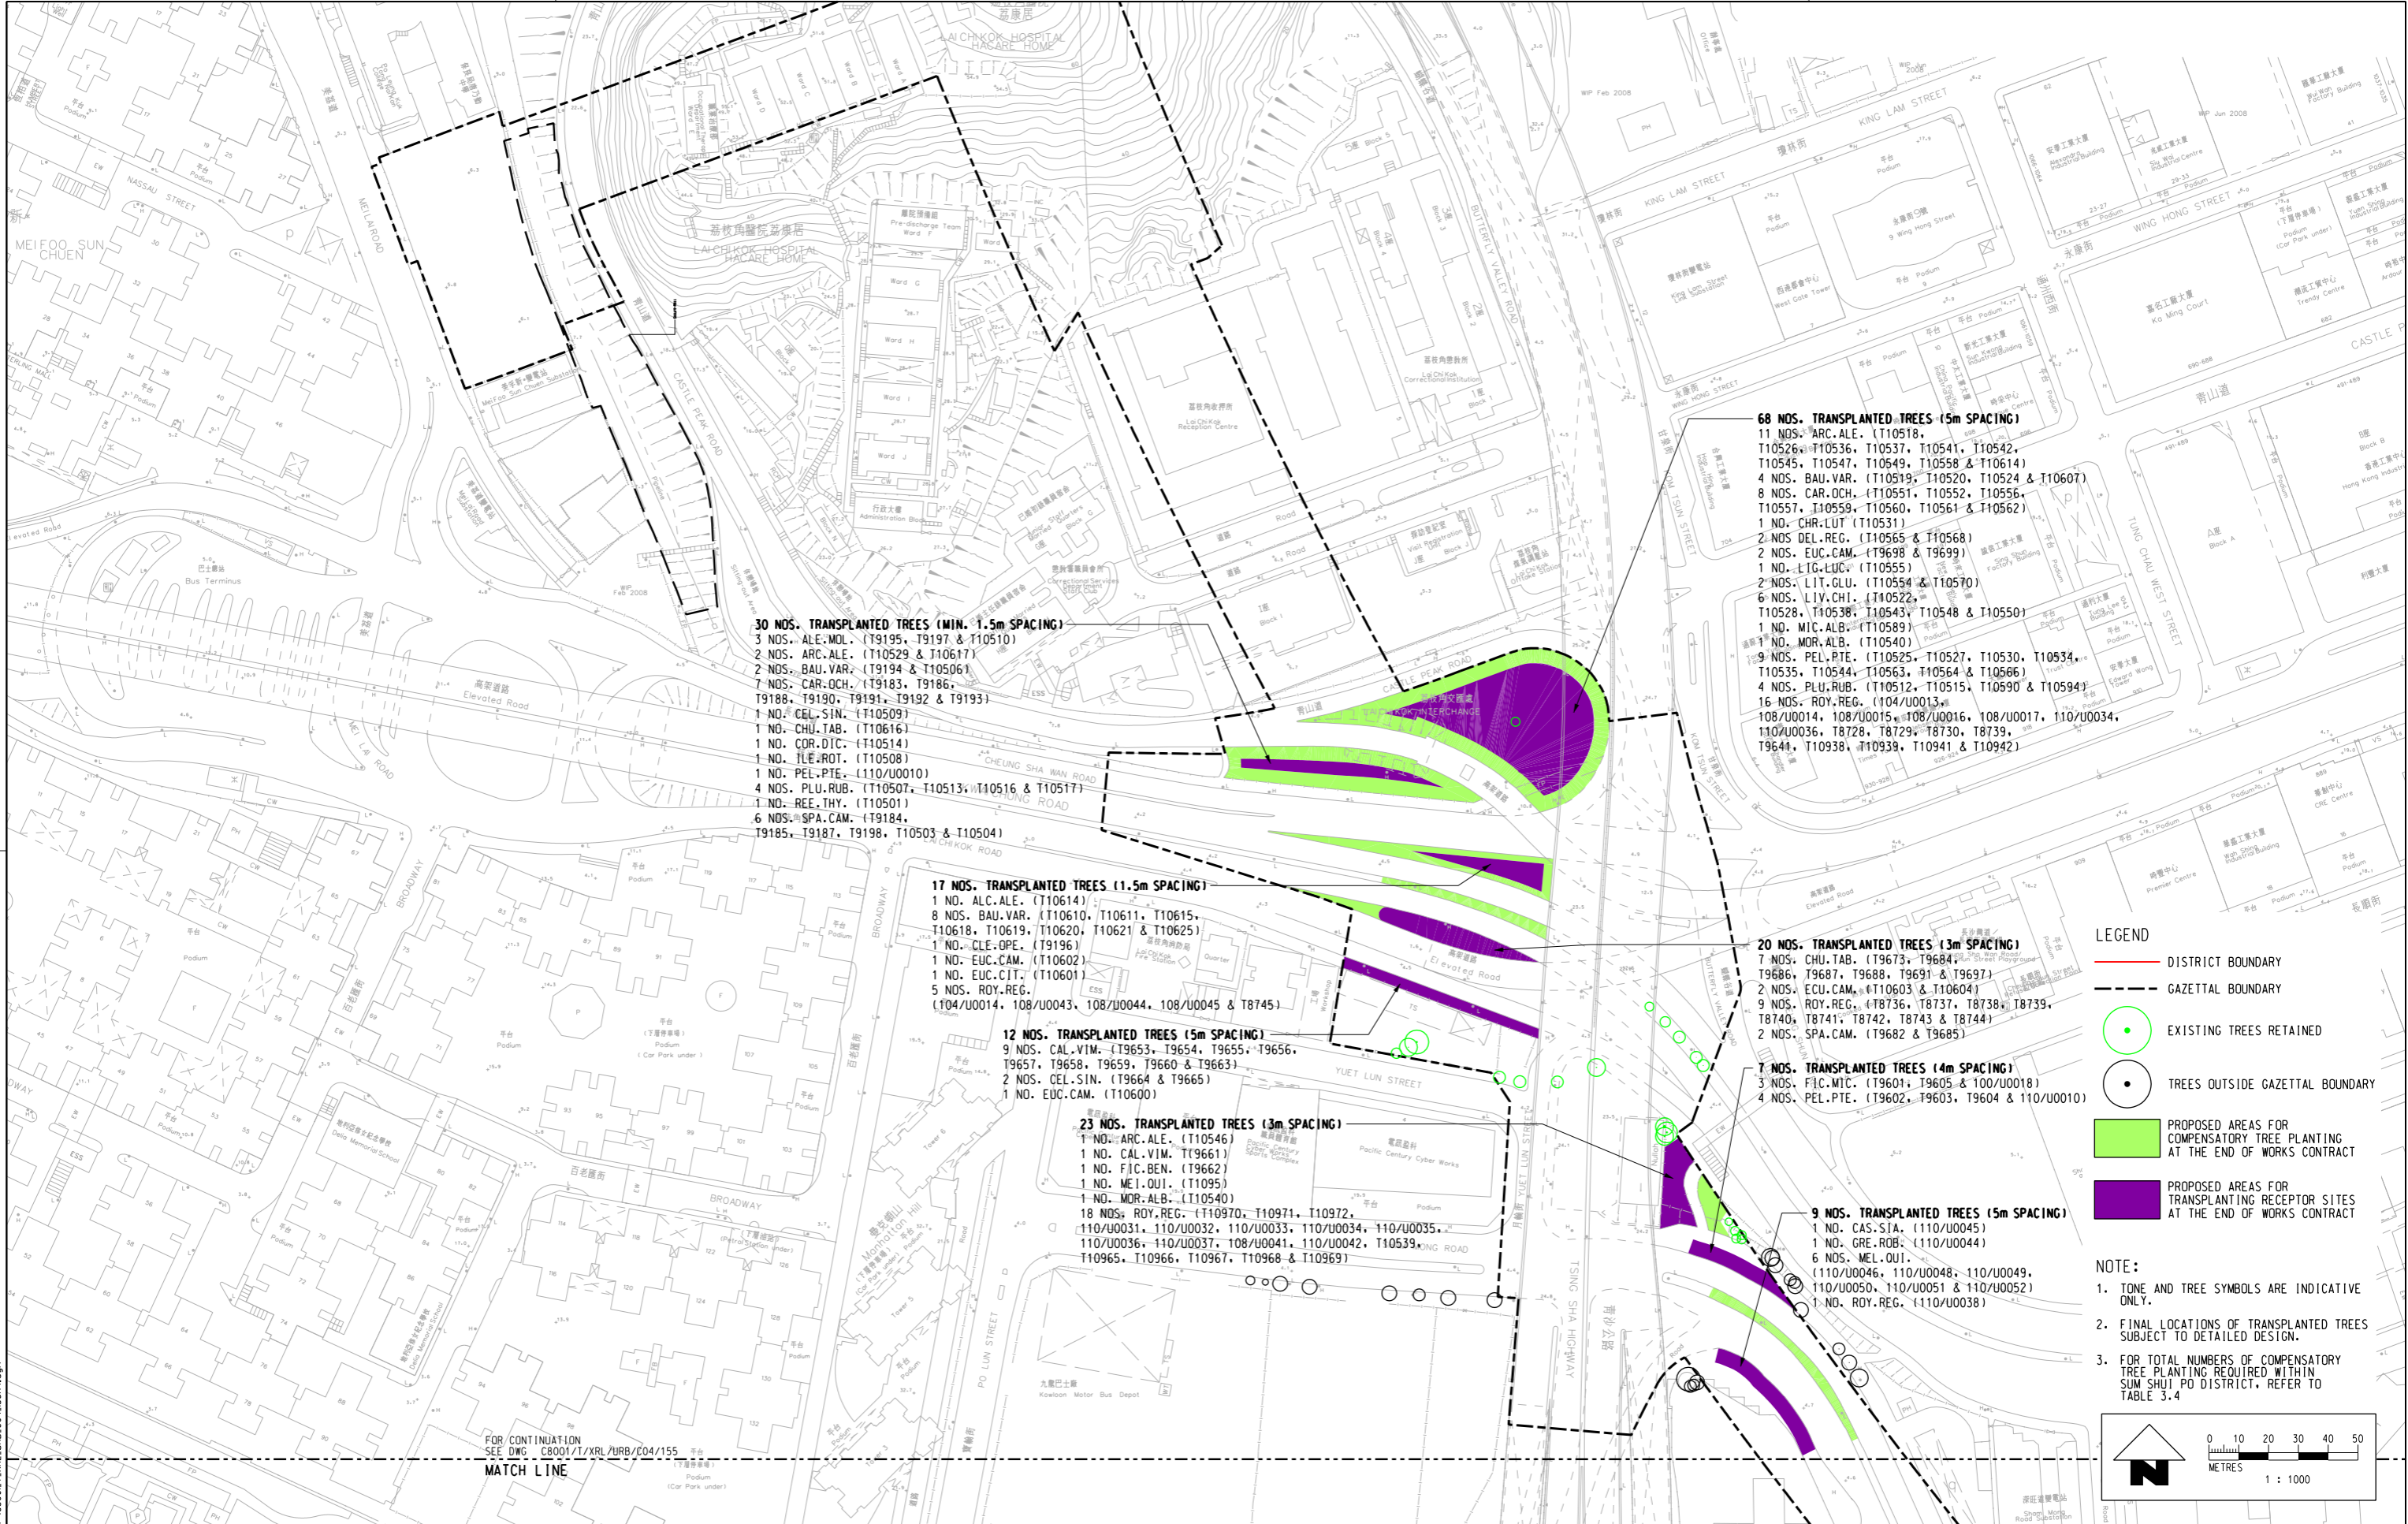

30 NOS. TRANSPLANTED TREES (MIN. 1.5m SPACING)
 3 NOS. ALC.MOL. (T9195, T9197 & T10510)
 2 NOS. ARC.ALE. (T10529 & T10617)
 2 NOS. BAU.VAR. (T9194 & T10506)
 7 NOS. CAR.OCH. (T9183, T9186, T9188, T9190, T9191, T9192 & T9193)
 1 NO. CEL.SIN. (T10509)
 1 NO. CHU.TAB. (T10616)
 1 NO. COR.DIC. (T10514)
 1 NO. ILE.ROT. (T10508)
 1 NO. PEL.PTE. (110/U0010)
 4 NOS. PLU.RUB. (T10507, T10513, T10516 & T10517)
 1 NO. REE.THY. (T10501)
 6 NOS. SPA.CAM. (T9184, T9185, T9187, T9198, T10503 & T10504)

17 NOS. TRANSPLANTED TREES (1.5m SPACING)
 1 NO. ALC.ALE. (T10614)
 8 NOS. BAU.VAR. (T10610, T10611, T10615, T10618, T10619, T10620, T10621 & T10625)
 1 NO. CLE.OPE. (T9196)
 1 NO. EUC.CAM. (T10602)
 1 NO. EUC.CIT. (T10601)
 5 NOS. ROY.REG. (T04/U0014, 108/U0043, 108/U0044, 108/U0045 & T8745)

12 NOS. TRANSPLANTED TREES (5m SPACING)
 9 NOS. CAL.VIM. (T9653, T9654, T9655, T9656, T9657, T9658, T9659, T9660 & T9663)
 2 NOS. CEL.SIN. (T9664 & T9665)
 1 NO. EUC.CAM. (T10600)

23 NOS. TRANSPLANTED TREES (3m SPACING)
 1 NO. ARC.ALE. (T10546)
 1 NO. CAL.VIM. (T9661)
 1 NO. FIC.BEN. (T9662)
 1 NO. MEI.OUI. (T1095)
 1 NO. MOR.ALB. (T10540)
 18 NOS. ROY.REG. (T10970, T10971, T10972, T10973, T10974, T10975, T10976, T10977, T10978, T10979, T10980, T10981, T10982, T10983, T10984, T10985, T10986, T10987, T10988 & T10989)

68 NOS. TRANSPLANTED TREES (5m SPACING)
 11 NOS. ARC.ALE. (T10518, T10526, T10536, T10537, T10541, T10542, T10545, T10547, T10549, T10558 & T10614)
 4 NOS. BAU.VAR. (T10519, T10520, T10524 & T10607)
 8 NOS. CAR.OCH. (T10551, T10552, T10556, T10557, T10559, T10560, T10561 & T10562)
 1 NO. CHR.LUT (T10531)
 2 NOS. DEL.REG. (T10565 & T10568)
 2 NOS. EUC.CAM. (T9698 & T9699)
 1 NO. LG.LUC. (T10555)
 2 NOS. LIT.GLU. (T10554 & T10570)
 6 NOS. LIV.CHI. (T10522, T10528, T10538, T10543, T10548 & T10550)
 1 NO. MIC.ALB. (T10589)
 1 NO. MOR.ALB. (T10540)
 9 NOS. PEL.PTE. (T10525, T10527, T10530, T10534, T10535, T10544, T10563, T10564 & T10566)
 4 NOS. PLU.RUB. (T10512, T10515, T10590 & T10594)
 16 NOS. ROY.REG. (T04/U0013, 108/U0014, 108/U0015, 108/U0016, 108/U0017, 110/U0034, 110/U0036, T8728, T8729, T8730, T8739, T9644, T10938, T10939, T10941 & T10942)

 
20 NOS. TRANSPLANTED TREES (3m SPACING)
 7 NOS. CHU.TAB. (T9673, T9684, T9686, T9687, T9688, T9691 & T9697)
 2 NOS. EUC.CAM. (T10603 & T10604)
 9 NOS. ROY.REG. (T8736, T8737, T8738, T8739, T8740, T8741, T8742, T8743 & T8744)
 2 NOS. SPA.CAM. (T9682 & T9685)

7 NOS. TRANSPLANTED TREES (4m SPACING)
 3 NOS. FIC.MIC. (T9601, T9605 & 110/U0018)
 4 NOS. PEL.PTE. (T9602, T9603, T9604 & 110/U0010)

9 NOS. TRANSPLANTED TREES (5m SPACING)
 1 NO. CAS.SIA. (110/U0045)
 1 NO. GRE.ROB. (110/U0044)
 6 NOS. MEL.OUI. (110/U0046, 110/U0048, 110/U0049, 110/U0050, 110/U0051 & 110/U0052)
 1 NO. ROY.REG. (110/U0038)

- LEGEND**
- DISTRICT BOUNDARY
 - GAZETTAL BOUNDARY
 - EXISTING TREES RETAINED
 - TREES OUTSIDE GAZETTAL BOUNDARY
 - PROPOSED AREAS FOR COMPENSATORY TREE PLANTING AT THE END OF WORKS CONTRACT
 - PROPOSED AREAS FOR TRANSPLANTING RECEPTOR SITES AT THE END OF WORKS CONTRACT

- NOTE:**
1. TONE AND TREE SYMBOLS ARE INDICATIVE ONLY.
 2. FINAL LOCATIONS OF TRANSPLANTED TREES SUBJECT TO DETAILED DESIGN.
 3. FOR TOTAL NUMBERS OF COMPENSATORY TREE PLANTING REQUIRED WITHIN SUM SHUI PO DISTRICT, REFER TO TABLE 3.4



FOR CONTINUATION
 SEE DWG C8001/T/XRL/URB/C04/155
MATCH LINE

REV	DESCRIPTION	BY	DATE	APPROVED	REV	DESCRIPTION	BY	DATE	APPROVED
A4	FOURTH ISSUE	SAN	13NOV09	AD					
A3	THIRD ISSUE	SAN	27OCT09	AD					
A2	SECOND ISSUE	SAN	09JUN09	AD					
A1	FIRST ISSUE	SAN	30APR09	AD					

DRAWN SAN
 DESIGNED JP
 CHECKED TO
 APPROVED AD
 DATE 30. APR. 2009

MTR


EXPRESS RAIL LINK (XRL)

ORIGINATOR
 Planning, Urban Design, Landscape, Golf & Environmental Consultants
 Urbis Limited, 11/F Siu On Centre, 188 Lockhart Road, Wan Chai, Hong Kong.
 Tel 2802 3333 Fax 2802 8662


CADD REF. C8001.T_XRL_URB_C04_156A4.dgn

TITLE
CONSULTANCY AGREEMENT NO. C8001
TREE TRANSPLANTING / FELLING
COMPENSATORY TREE PROPOSAL FOR SHAM SHUI PO DISTRICT
 (SHEET 5 OF 5)

SCALE 1 : 1000 @ A1
 DRAWING NO. C8001/T/XRL/URB/C04/156
 REV. A4

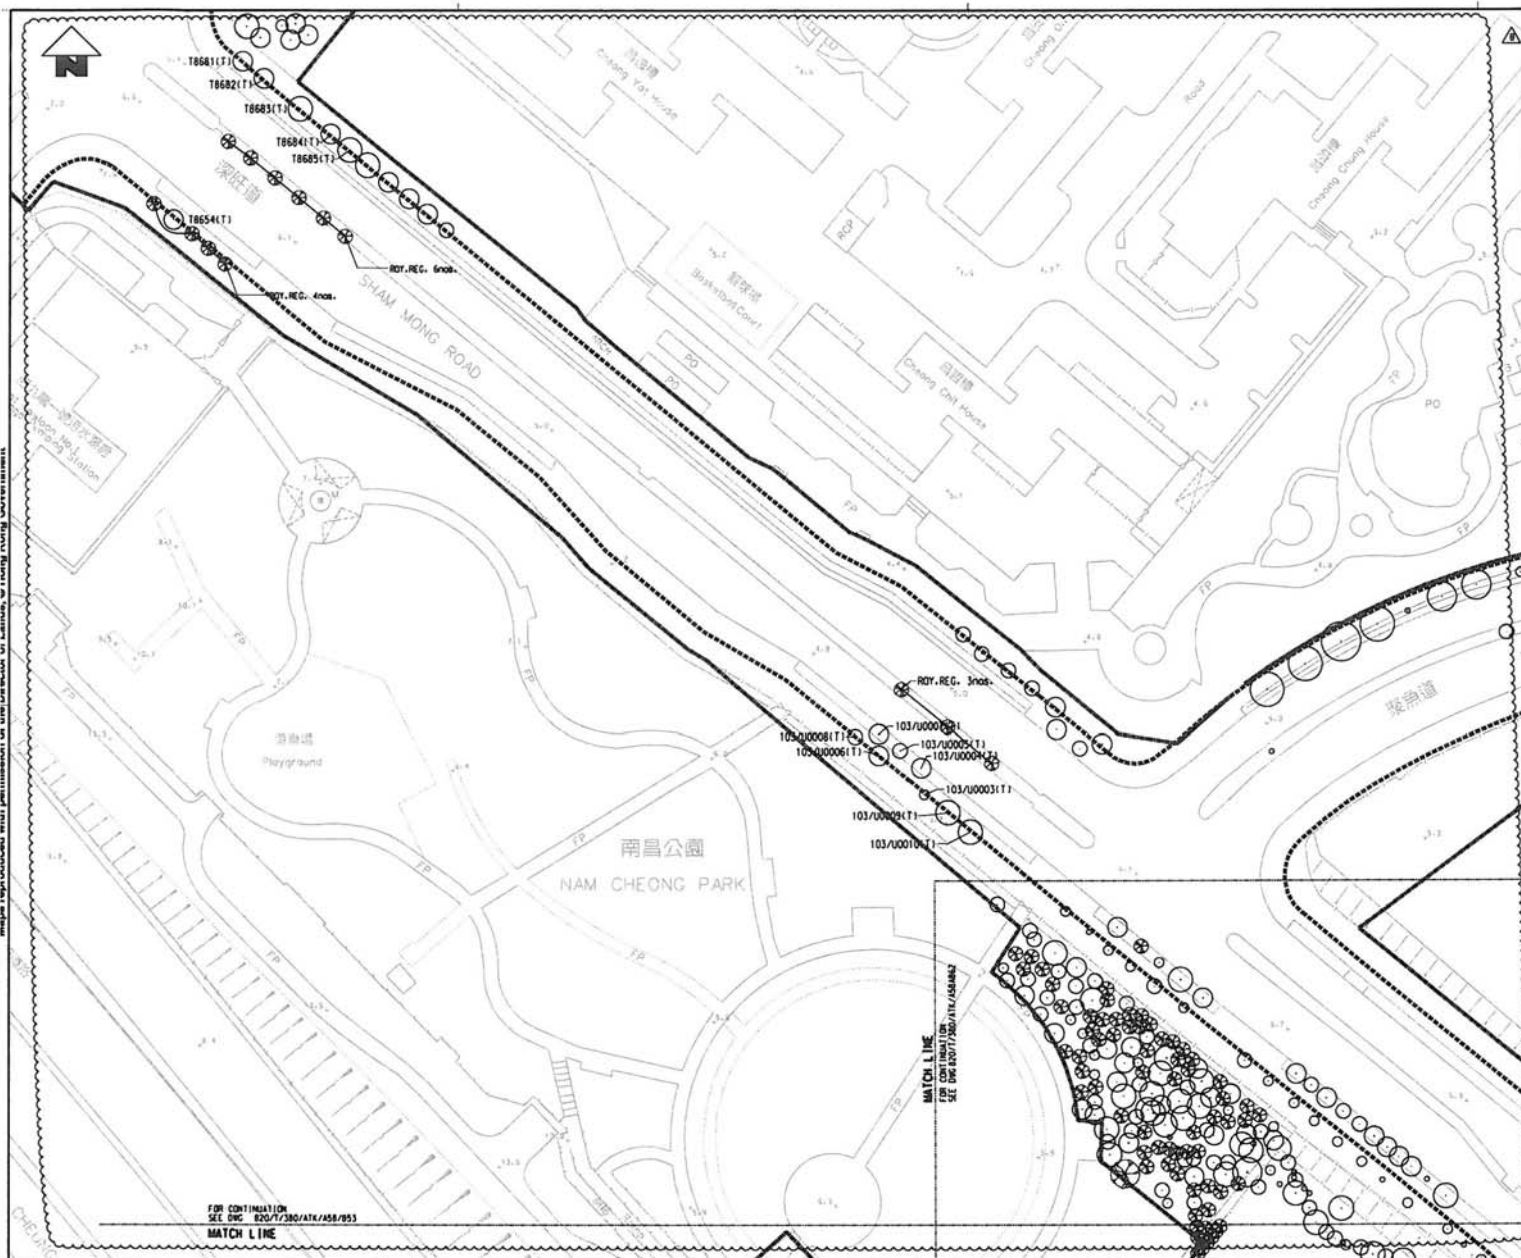

NOTES: FOR GENERAL LEGEND REFER TO DWG. NO. 820/T/HCY/ATK/A58/001

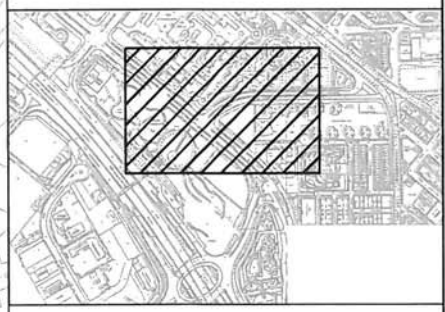


KEY PLAN SCALE 1:5000

LEGEND

- EXISTING TREE TRANSPLANTED TO FINAL LOCATION BY OTHERS
- EXISTING TREE TO BE RETAINED
- NEW TREE

Type	Botanical Name	Chinese Name	Standard	Spacing	Remarks	Quantity
樹種	樹名	樹名	樹種	樹種	備註	數量
ROY. REG.	ROYSTONIA REGA	紅仔	7000(H)X5000(S)X200mm TRUNK DIA.	AS SHOWN	CONTAINER GROWN	13

 

REV	DESCRIPTION	BY	DATE	APPROVED	DESCRIPTION	BY	DATE	APPROVED
B	TENDER ADDENDUM NO. 2	AC	30NOV09	TM				
A	TENDER ADDENDUM	AC	30OCT09	TM				

DRAWN	SK
DESIGNED	AC
CHECKED	KN
APPROVED	TM
DATE	30/OCT/09

MTR EXPRESS RAIL LINK

OPERATOR


ATKINS Supported by Arup, TFP, Farrells, DLS, Kenneth Ng

DRAWING NO. 820.T.380.ATK.A58.852B.dgn


TITLE	SCALE	DRAWING NO.	REV.
CONTRACT 820 MEI LAI ROAD TO HOI TING ROAD TUNNELS SHAM SHUI PO DISTRICT LANDSCAPE PLAN - TREE PLANTING (SHEET 1 OF 12)	1 : 500 (A1)	820/T/380/ATK/A58/852	B

1: CONTRACT NO. 820/T/380/ATK/A58/093
 2: CONTRACT NO. 820/T/380/ATK/A58/093
 3: CONTRACT NO. 820/T/380/ATK/A58/093
 100: CONTRACT NO. 820/T/380/ATK/A58/093

MADE REPRODUCED WITH PERMISSION OF THE DIRECTOR OF LANDS, © HONG KONG GOVERNMENT

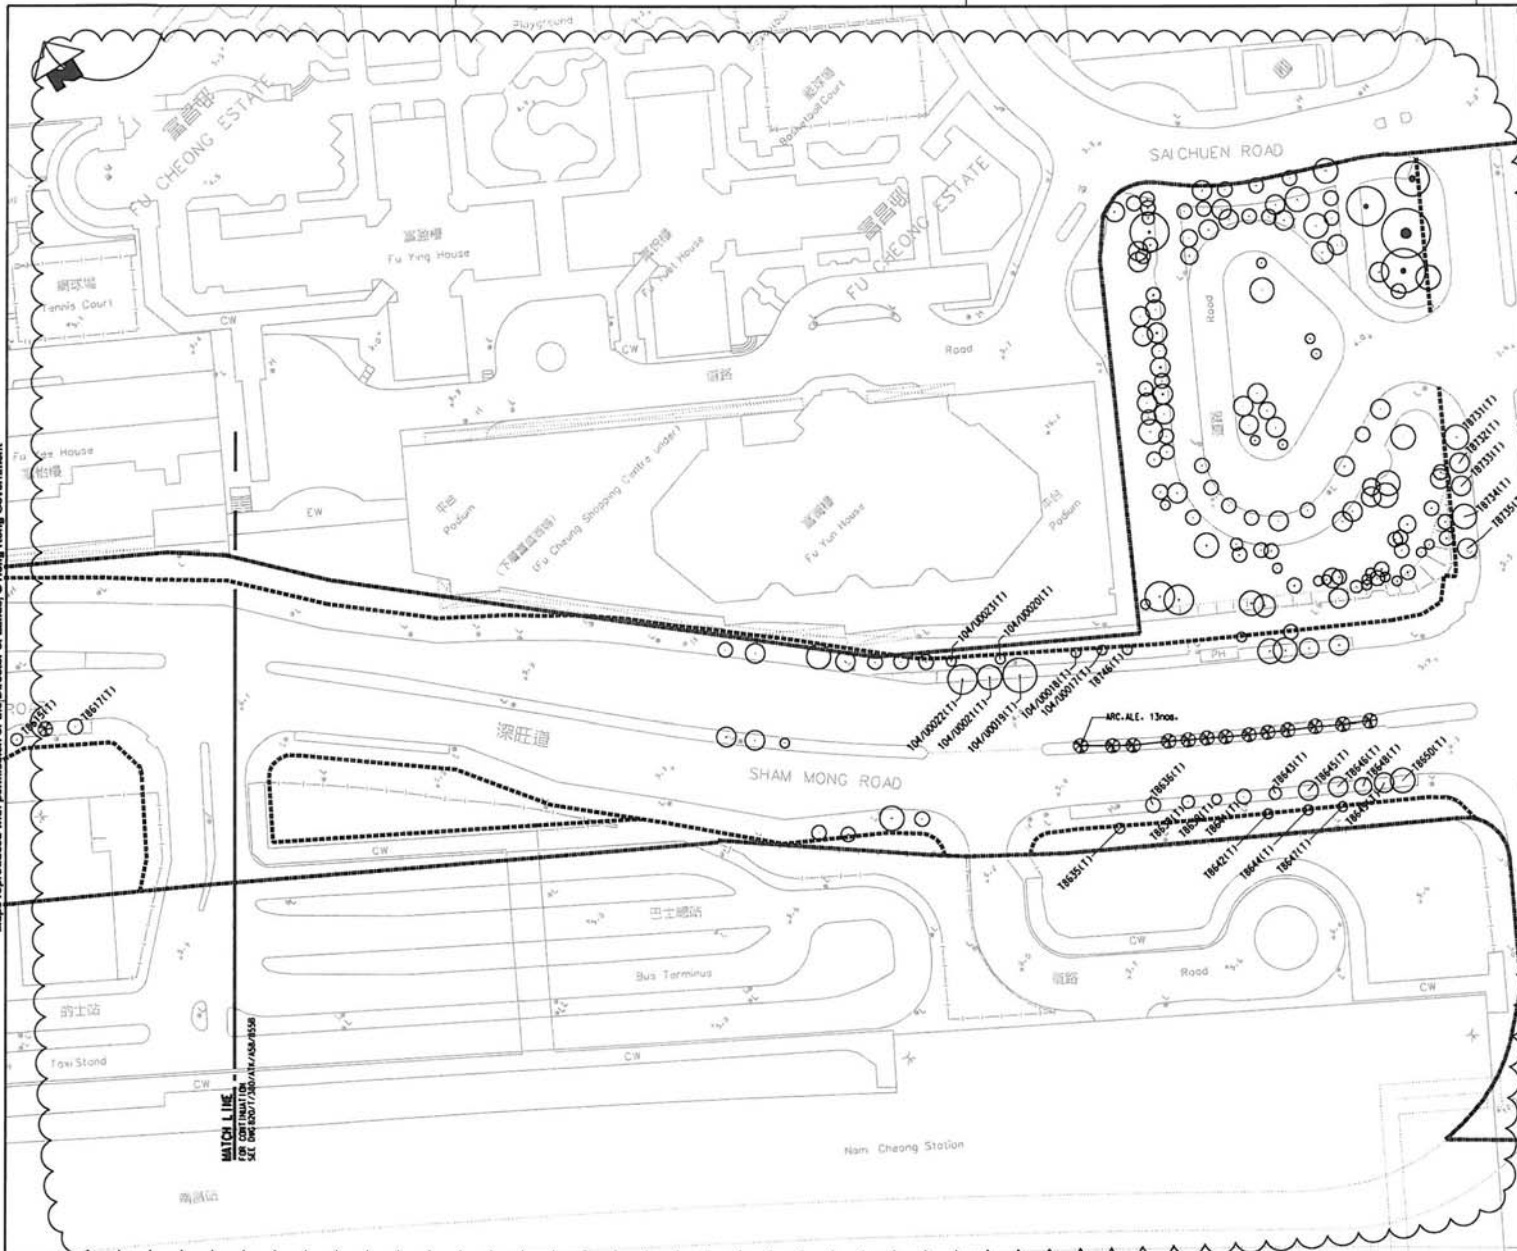

NOTES: FOR GENERAL LEGEND REFER TO DWG. NO. 820/T/MV/ATK/A58/801

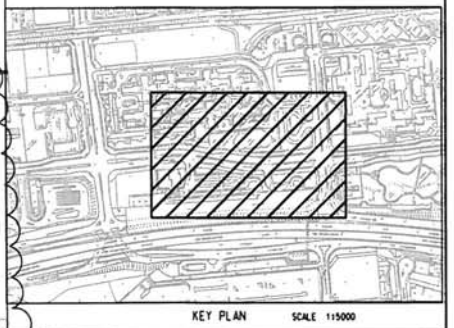

LEGEND

- EXISTING TREE TRANSPLANTED TO FINAL LOCATION BY OTHERS
- EXISTING TREE TO BE RETAINED
- NEW TREE

Type	Botanical Name	Chinese Name	Standard	Spacing	Remarks	Quantity
TREE	ARC.ALE	ARCHONDOXYDON ALEXANDRAE	8000(H)X3000(S)X150mm TRUNK DIALS SHOW	CONTAINER GROWN		13



SCALE: 1:500

REV	DESCRIPTION	BY	DATE	APPROVED	REV	DESCRIPTION	BY	DATE	APPROVED
B	TENDER ADDENDUM NO.2	AC	30NOV09	TM					
A	TENDER ADDENDUM	AC	30OCT09	TM					

DESIGNED	SK
CHECKED	KN
APPROVED	TM
DATE	30/OCT/09

MTR EXPRESS RAIL LINK

ATKINS Supported by Arup, TFP, Farrelis, DLS, Kenneth Ng

ORIGINATOR: MTR

CAAD REF: 820.T.380.ATK.A58.854B.dgn

TITLE: **CONTRACT 820**
MEI LAI ROAD TO HOI TING ROAD TUNNELS
SHAM SHUI PO DISTRICT
LANDSCAPE PLAN - TREE PLANTING
(SHEET 3 OF 12)

SCALE: 1:500 (A1)


DRAWING NO: 820/T/380/ATK/A58/854

REV: B


Map reproduced with permission of the Director of Lands, © Hong Kong Government

PRINTED BY: KESDEN 2008/01/14 3/4" x 1/4" 1:5525

DRAWN BY: MTR
DESIGNED BY: MTR
CHECKED BY: MTR
APPROVED BY: MTR

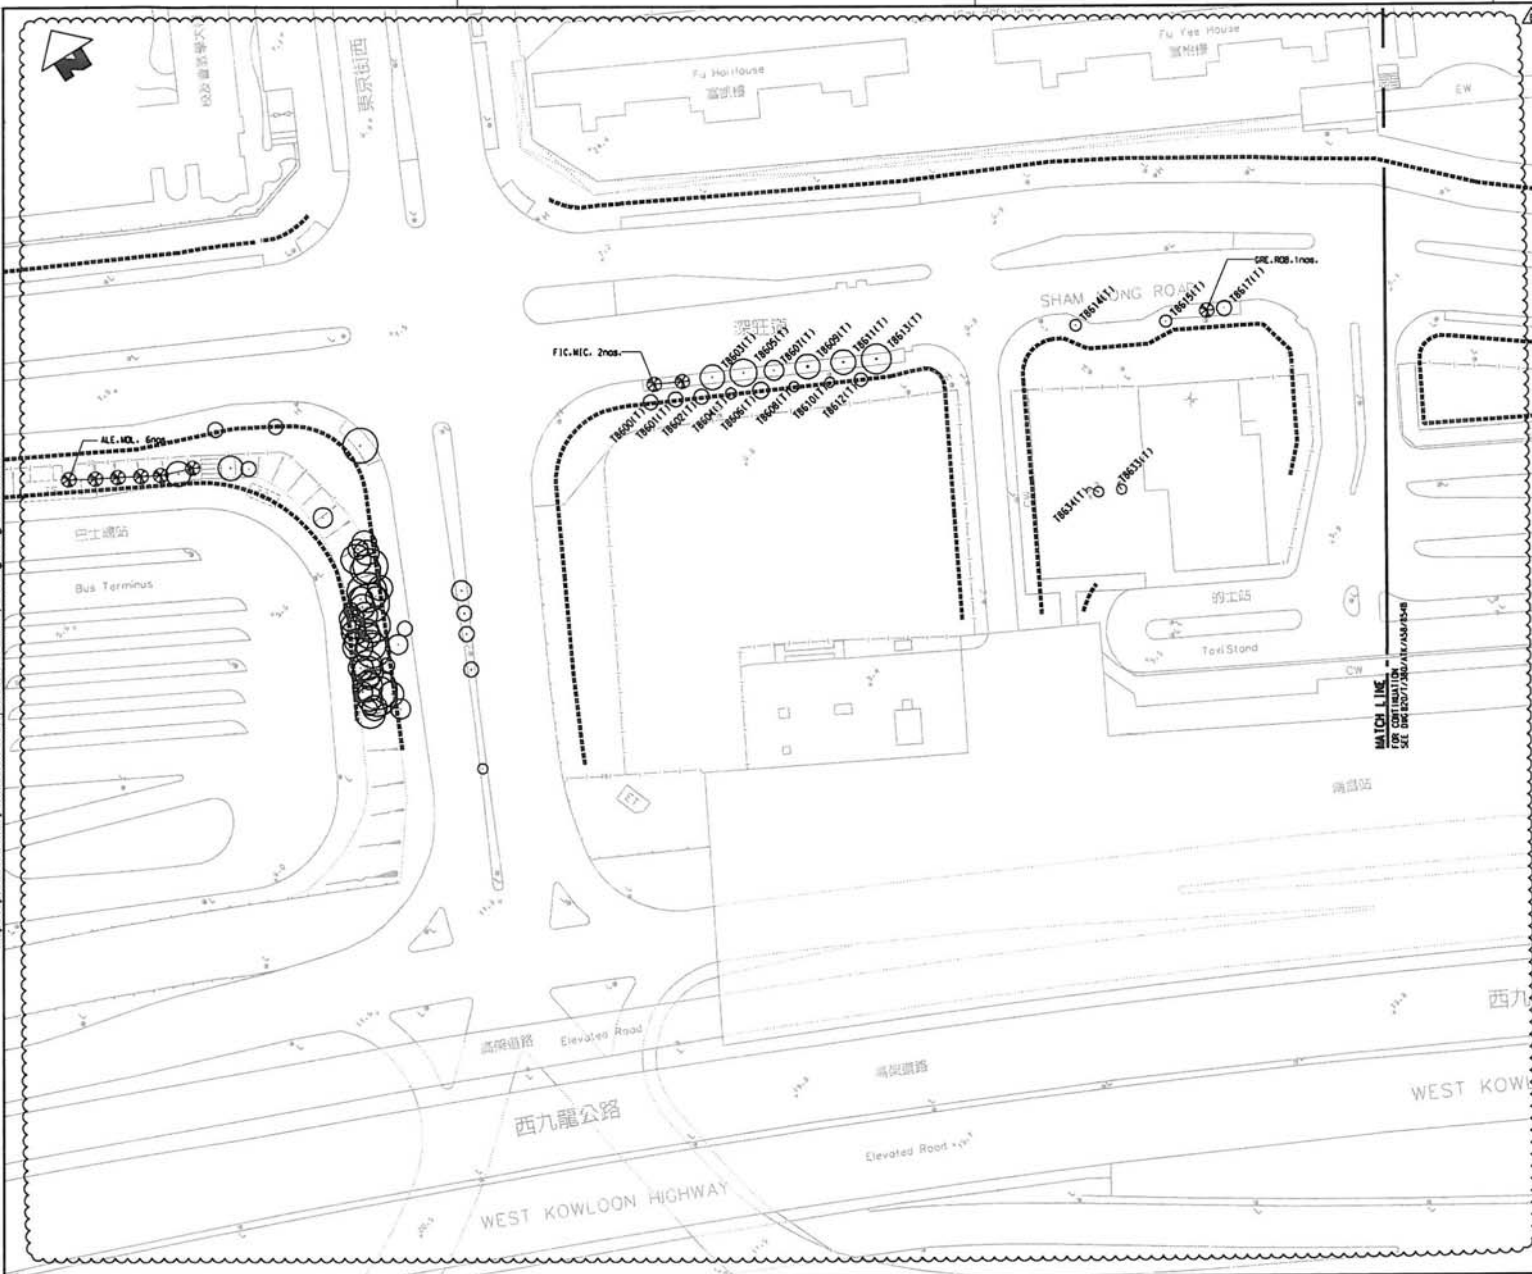

NOTES: FOR GENERAL LEGEND REFER TO DWG. NO. 820/T/MK/ATK/A58/B01

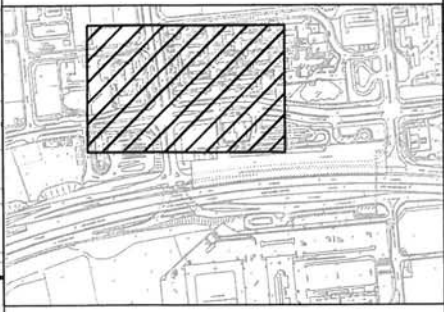

KEY PLAN SCALE 1:15000

LEGEND

- EXISTING TREE TRANSPLANTED TO FINAL LOCATION BY OTHERS
- EXISTING TREE TO BE RETAINED
- NEW TREE

Type	Botanical Name	Chinese Name	Standard	Specing	Remarks	Quantity
樹種	學名	中文名稱	標準	規格	備註	數量
TREE						
樹種	GREYLLIA ROBUSTA	銀葉樹	5000(H)x2000(S)x100mm TRUNK DIA. AS SHOWN	CONTAINER GROWN		1
樹種	FOCUS MICROCARPA	銀葉樹	4000(H)x3000(S)x100mm TRUNK DIA. AS SHOWN	CONTAINER GROWN		2
樹種	ALEURITES MOLUCCANA	銀葉樹	5000(H)x2500(S)x100mm TRUNK DIA. AS SHOWN	CONTAINER GROWN		5

REV	DESCRIPTION	BY	DATE	APPROVED	REV	DESCRIPTION	BY	DATE	APPROVED
B	TENDER ADDENDUM NO.2	AC	30NOV08	TM					
A	TENDER ADDENDUM	AC	30OCT08	TM					

DRAWN	SK
DESIGNED	AC
CHECKED	KN
APPROVED	TM
DATE	30/06/09

MTR
EXPRESS RAIL LINK

ORIGINATOR
ATKINS
Supported by Arup, TFP, Farrells, DLS, Kenneth Ng


CADD REF: 820_T_380_ATK_A58_855B.dgn

TITLE
CONTRACT 820
MEI LAI ROAD TO HOI TING ROAD TUNNELS
SHAM SHUI PO DISTRICT
LANDSCAPE PLAN - TREE PLANTING
(SHEET 4 OF 12)

SCALE: 1 : 500 (A1)
DRAWING NO.: 820/T/380/ATK/A58/855
REV: B



NOTES: FOR GENERAL LEGEND REFER TO DWG. NO. 820/T/MCV/ATK/A58/801

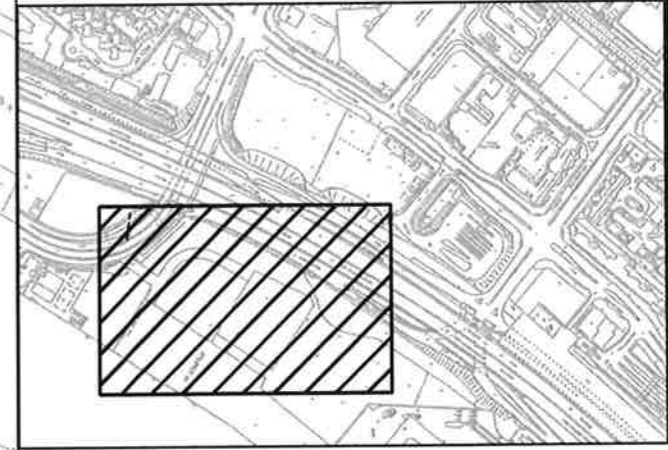


KEY PLAN SCALE 1:5000

LEGEND

	EXISTING TREE TRANSPLANTED TO FINAL LOCATION BY OTHERS
	EXISTING TREE TO BE RETAINED
	NEW TREE

Type	Botanical Name	Chinese Name	Standard	Spacing	Remarks	Quantity
樹種	學名	中文名	規格	間距	備註	數量
TREE						
ALE.MOL.	ALEURITES MOLUCCANA	椰風	3000(H)x2500(S)x100mm TRUNK DIA. AS SHOWN		CONTAINER GROWN	8

 

REV	DESCRIPTION	BY	DATE	APPROVED	REV	DESCRIPTION	BY	DATE	APPROVED
	B TENDER ADDENDUM NO.2	AC	30NOV09	TM					
	A TENDER ADDENDUM	AC	30OCT09	TM					

DRAWN	SK
DESIGNED	AC
CHECKED	KN
APPROVED	TM
DATE	30/OCT/09


ORIGINATOR	ATKINS	Supported by Arup, TFP, Farrelis, DLS Kenneth Ng
CAAD REF.	820_T_380_ATK_A58_8568.dgn	

TITLE	
CONTRACT 820 MEI LAI ROAD TO HOI TING ROAD TUNNELS SHAM SHUI PO DISTRICT LANDSCAPE PLAN (SHEET 5 OF 12)	
SCALE	DRAWING NO.
1 : 500 (A1)	820/T/380/ATK/A58/856
REV.	B


Maps reproduced with permission of the Director of Lands, © Hong Kong Government

PRINTED BY: MUSE# 2009/07 3/4 17/4 14/4 2

MODEL NAME: 4/1/4
ELEMENTS: 4/1/4

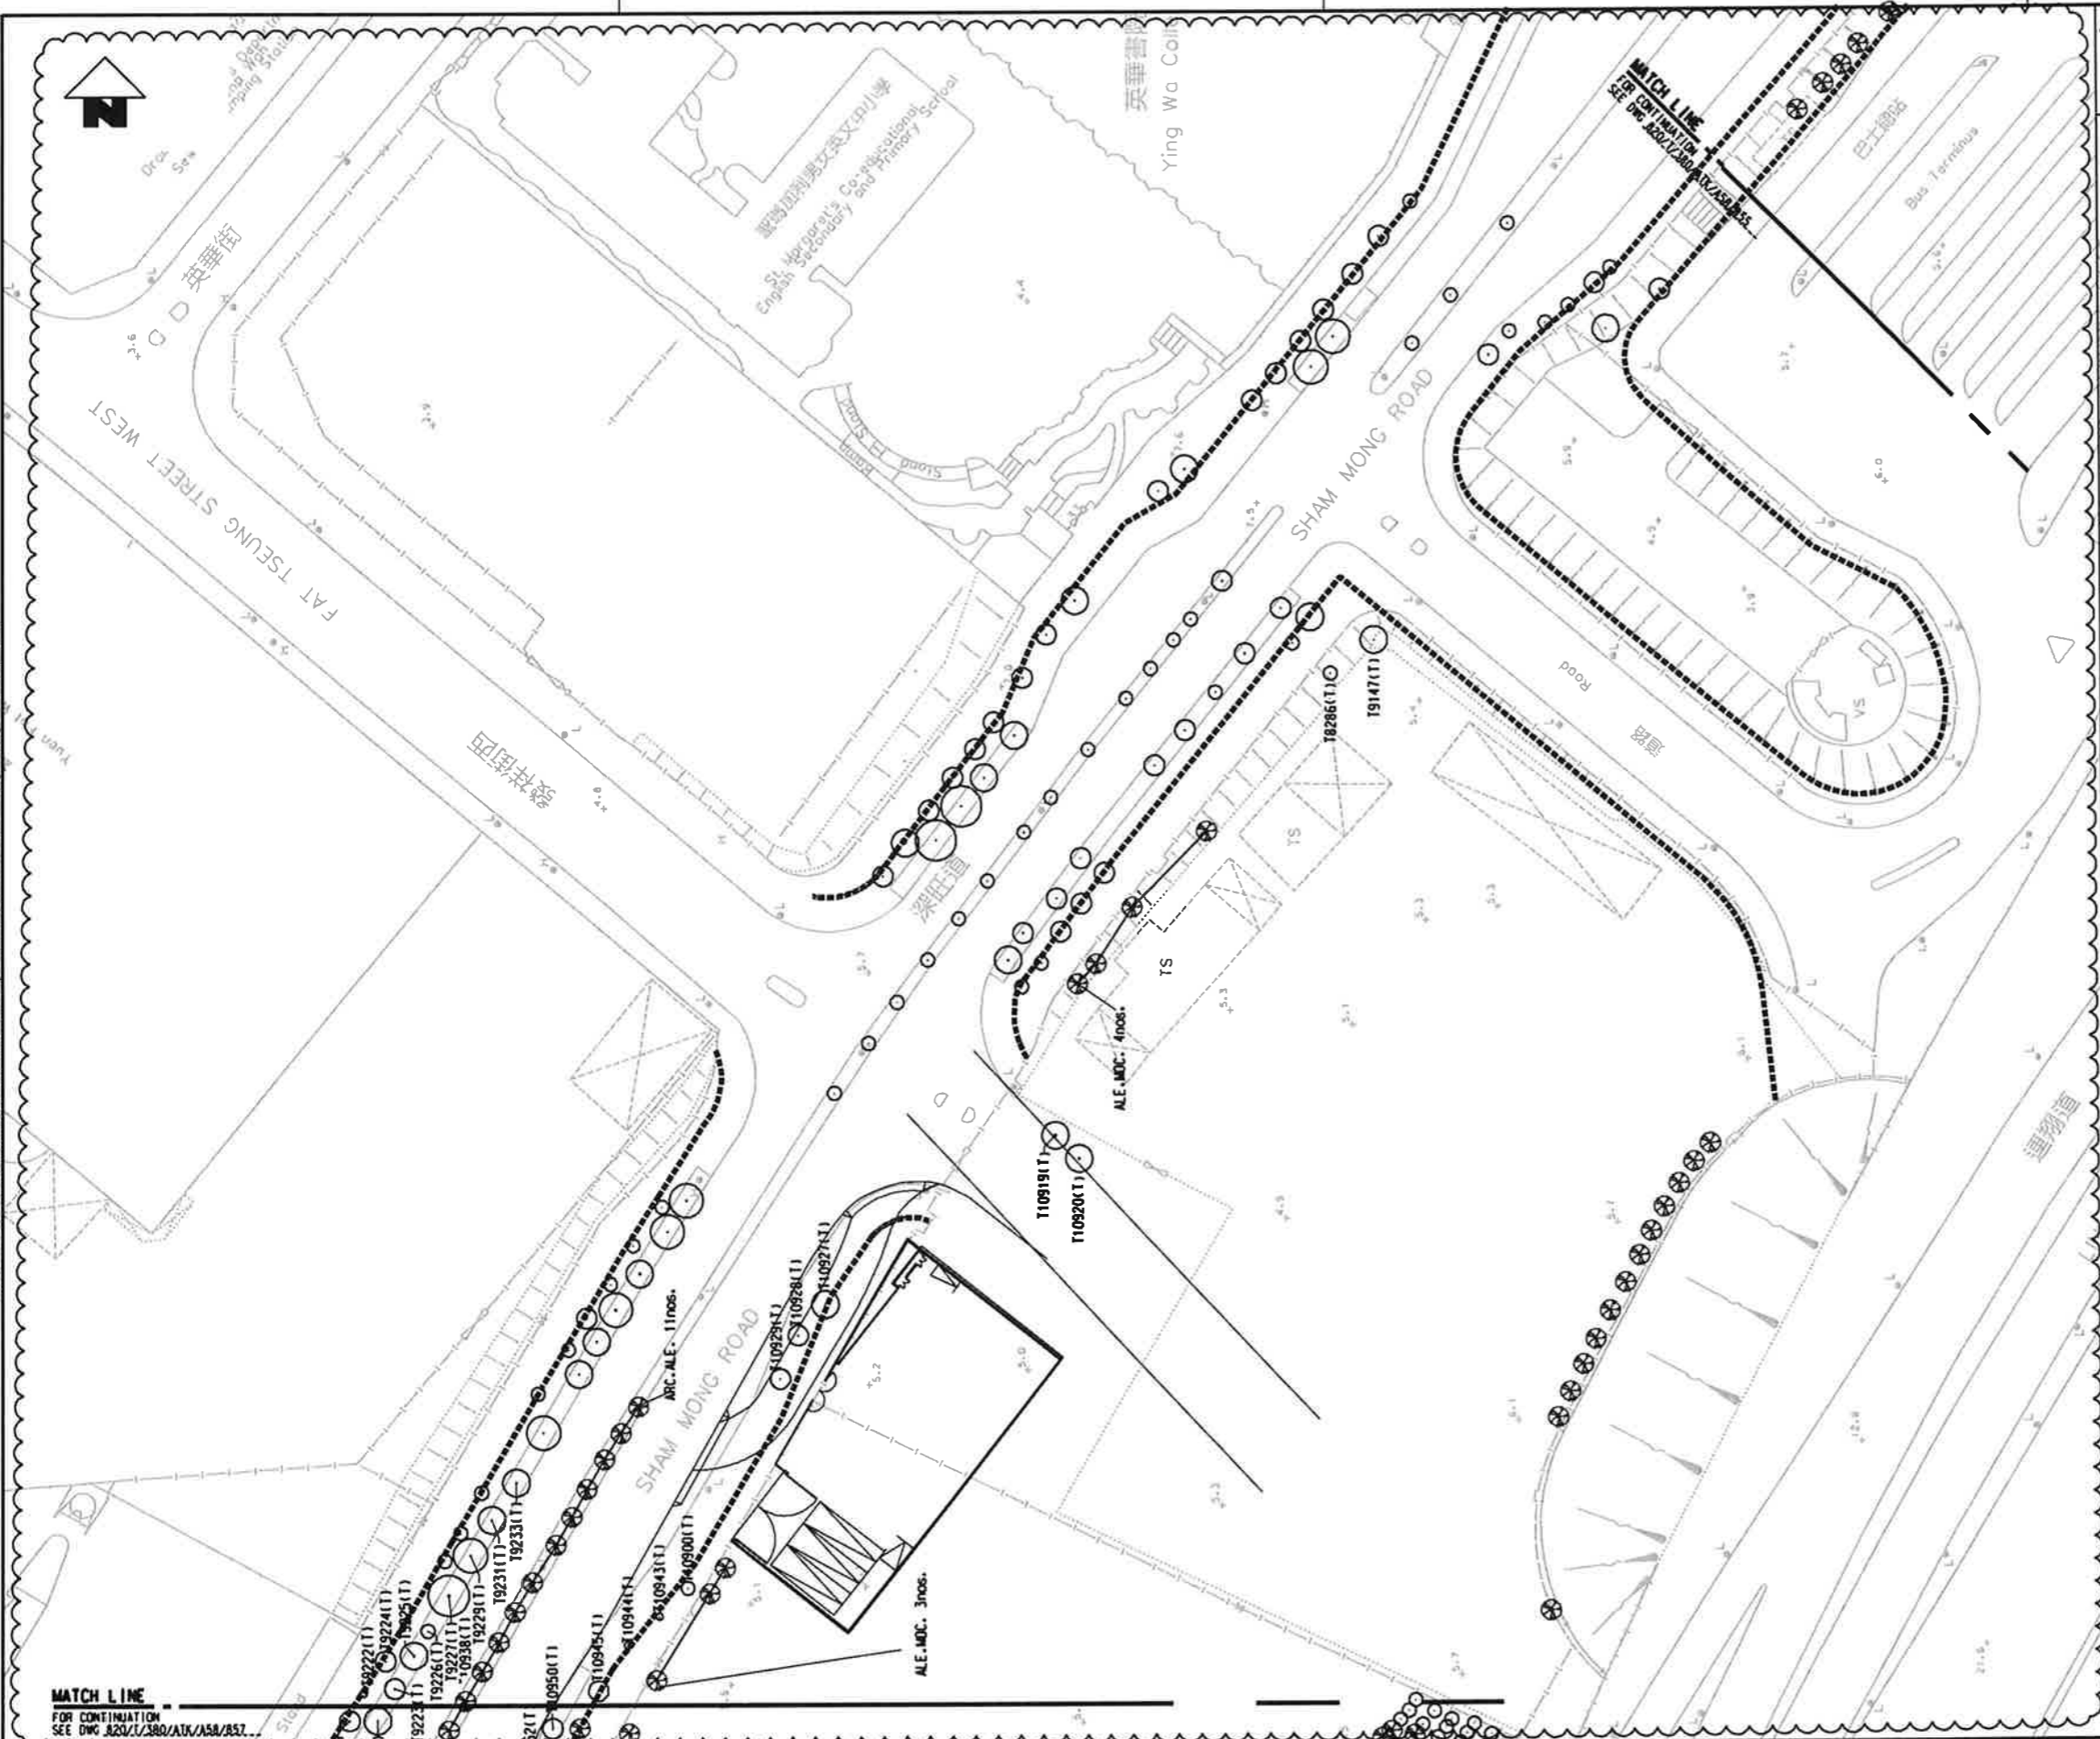

NOTES: FOR GENERAL LEGEND REFER TO DWG. NO. 820/T/NCV/ATK/A58/801

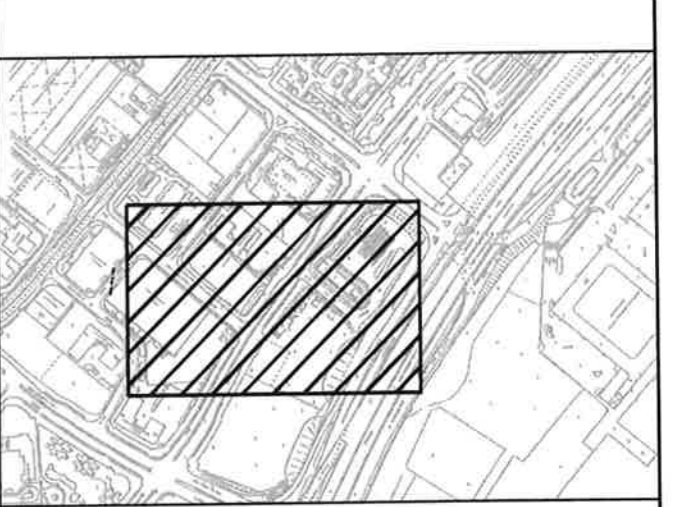


KEY PLAN SCALE 1:15000

LEGEND

- EXISTING TREE TRANSPLANTED TO FINAL LOCATION (BY OTHERS)
- EXISTING TREE TO BE RETAINED
- NEW TREE

Type	Botanical Name	Chinese Name	Standard	Spacing	Remarks	Quantity
ARC.ALE.	ARCHONTOPHOENIX ALEXANDRAE	銀葵	6000(H)X3000(S)X150mm TRUNK DIA. AS SHOWN	CONTAINER GROWN		11
ALE.MOC.	ALEURITES MOLUCCANA	洋槐	5000(H)X2000(S)X100mm TRUNK DIA. AS SHOWN	CONTAINER GROWN		7

 

MATCH LINE FOR CONTINUATION SEE DWG. 820/T/380/ATK/A58/A57

DRAWN	SK
DESIGNED	AC
CHECKED	KN
APPROVED	TM
DATE	30/OCT/09

MTR

EXPRESS RAIL LINK

ORIGINATOR

ATKINS Supported by Arup, TFP Farrells, DLS Kenneth Ng

CADD REF. 820.T.380.ATK.A58.857B.dgn

TITLE		CONTRACT 820 MEI LAI ROAD TO HOI TING ROAD TUNNELS SHAM SHUI PO DISTRICT LANDSCAPE PLAN - TREE PLANTING (SHEET 6 OF 12)	
SCALE	DRAWING NO.	REV.	
1:400 (A1)	820/T/380/ATK/A58/857	B	



REV	DESCRIPTION	BY	DATE	APPROVED	REV	DESCRIPTION	BY	DATE	APPROVED
B	TENDER ADDENDUM NO.2	AC	30NOV09	TM					
A	TENDER ADDENDUM NO.1	AC	30OCT09	TM					

DO NOT SCALE DRAWING. ALL DIMENSIONS SHALL BE KEPT AS SHOWN ON SET.
NO NEW COPYRIGHT OR LIMITED TERM COPYRIGHT IN RESPECT OF THIS DRAWING / DOCUMENT IS OWNED BY THE NEW CORPORATION LIMITED OF HONG KONG. NO REPRODUCTION OF THE DRAWING / DOCUMENT OR ANY PART BY WHATEVER MEANS IS PERMITTED WITHOUT THE PRIOR WRITTEN CONSENT OF THE NEW CORPORATION LIMITED.

Maps reproduced with permission of the Director of Lands, © Hong Kong Government

PRINTED BY: 405218 2009/1/17 7:41PM 4 153:102

MODULE FILE NAME: 820/T/380/ATK/A58/8588.dgn

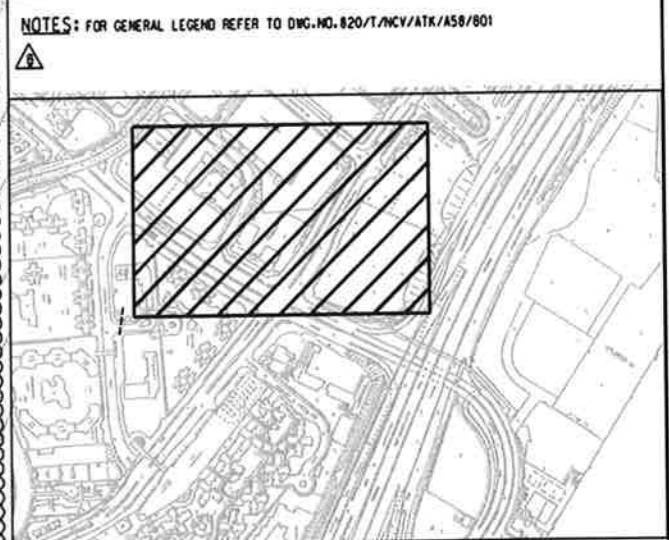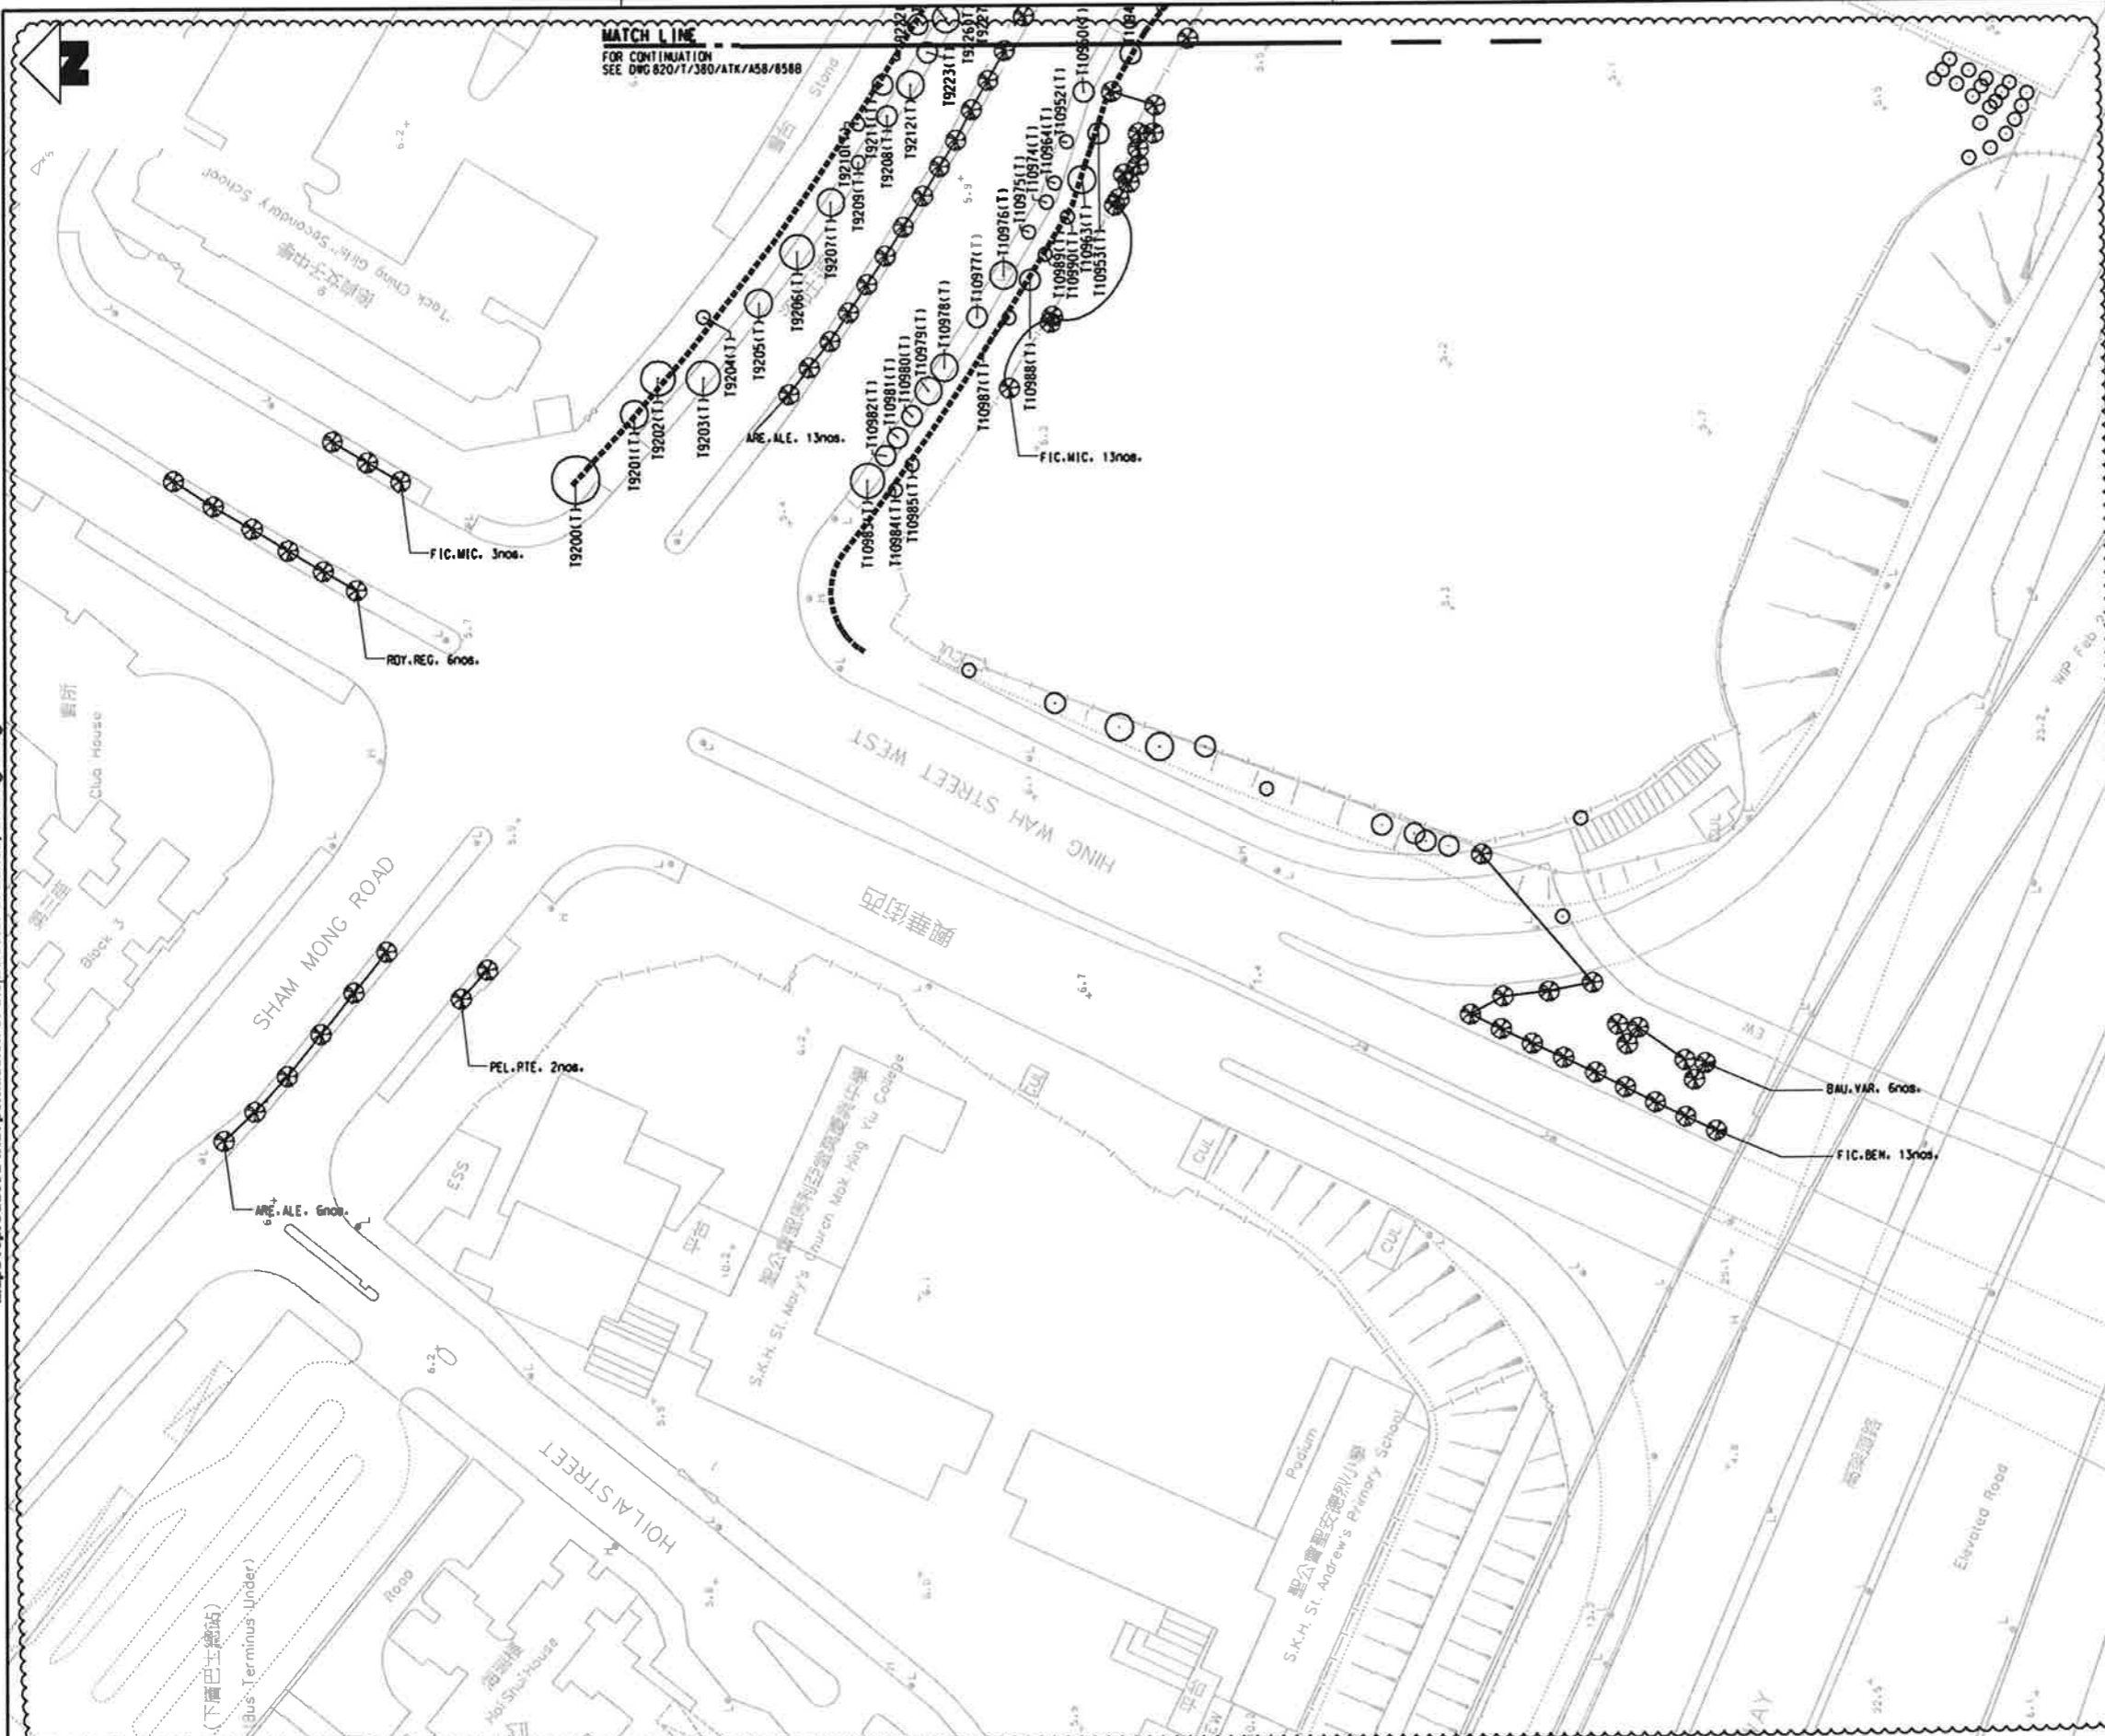


KEY PLAN SCALE 1:15000 2

LEGEND

- 10639(1T) EXISTING TREE TRANSPLANTED TO FINAL LOCATION (BY OTHERS)
- EXISTING TREE TO BE RETAINED
- NEW TREE


Type	Botanical Name	Chinese Name	Standard	Spacing	Remarks	Quantity
ARC.ALE.	ARCHONTOPHENIX ALEXANDRAE	銀葵	6000(H)X3000(S)X150mm TRUNK DIA.	AS SHOWN	CONTAINER GROWN	19
BAU.VAR.	BAUHINIA VARIEGATA	紅蝴蝶	5000(H)X4000(S)X100mm TRUNK DIA.	AS SHOWN	CONTAINER GROWN	6
FIC.BEN.	FICUS BENJAMINA	銀絲樹	4000(H)X4000(S)X150mm TRUNK DIA.	AS SHOWN	CONTAINER GROWN	13
ROY.REG.	ROYSTONIA REGIA	三球	7000(H)X5000(S)X200mm TRUNK DIA.	AS SHOWN	CONTAINER GROWN	6
FIC.MIC.	FICUS MICROCARPA	銀絲樹	4000(H)X3000(S)X100mm TRUNK DIA.	AS SHOWN	CONTAINER GROWN	16
PEL.PTE.	PELTOPHORUM PTEROCARPUM	銀斑	5000(H)X2500(S)X100mm TRUNK DIA.	AS SHOWN	CONTAINER GROWN	2

 


REV	DESCRIPTION	BY	DATE	APPROVED	REV	DESCRIPTION	BY	DATE	APPROVED
B	TENDER ADDENDUM NO.2	AC	30NOV09	TM					
A	TENDER ADDENDUM	AC	30OCT09	TM					

EXPRESS RAIL LINK
ATKINS Supported by Arup, TFP, Farrells, DLS, Kenneth Ng
 ORIGINATOR
 CADD REF. 820_T_380_ATK_A58_8588.dgn

CONTRACT 820
MEI LAI ROAD TO HOI TING ROAD TUNNELS
 SHAM SHUI PO DISTRICT
LANDSCAPE PLAN - TREE PLANTING
 (SHEET 7 OF 12)
 SCALE 1 : 500 (A11) DRAWING NO. 820/T/380/ATK/A58/858
 REV. B


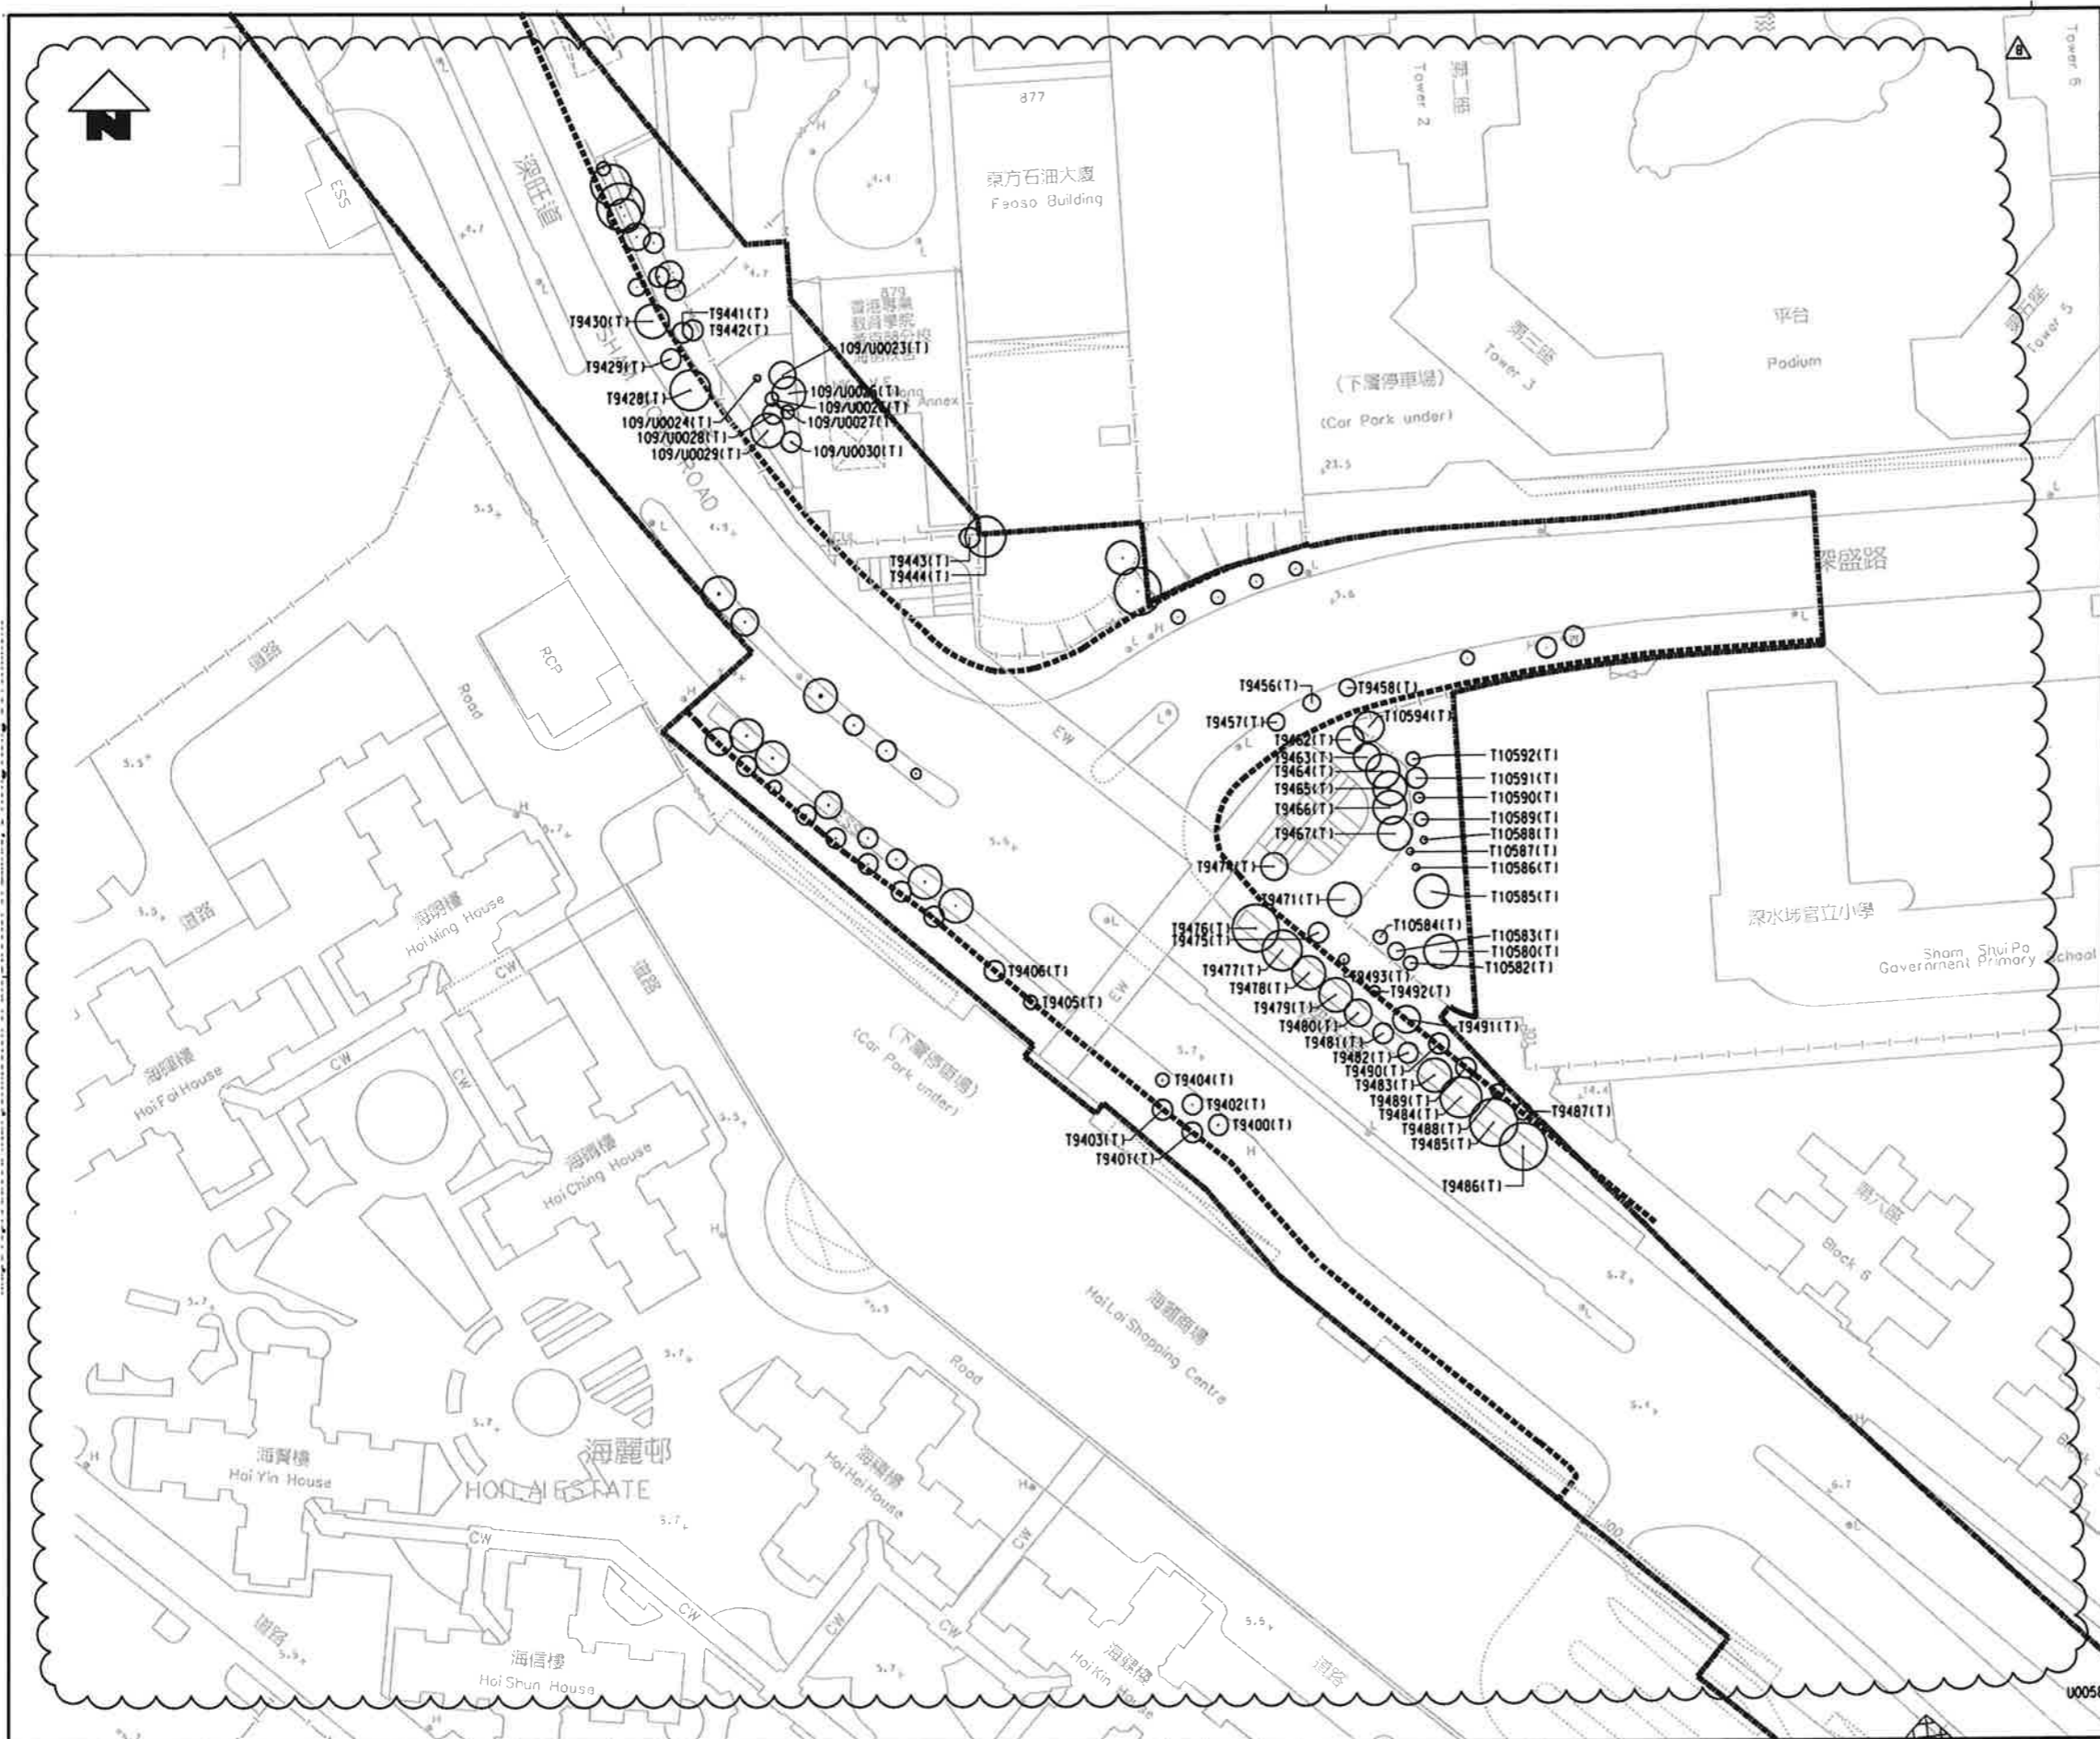



NOTES: FOR GENERAL LEGEND REFER TO DWG. NO. 820/T/NCV/ATK/A58/801

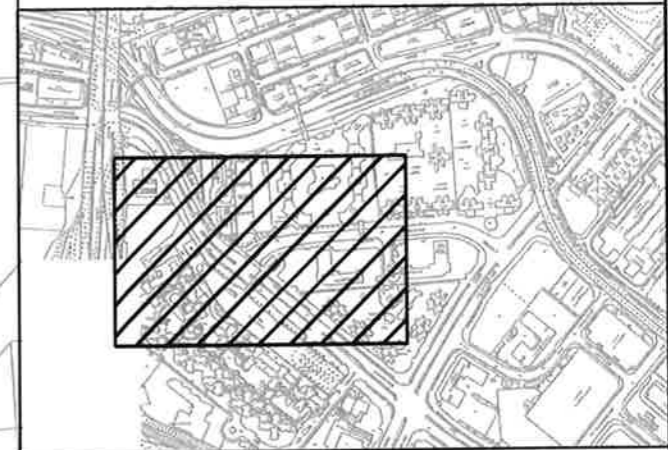


KEY PLAN SCALE 1:15000

  LEGEND


-  EXISTING TREE TRANSPLANTED TO FINAL LOCATION (BY OTHERS)
-  EXISTING TREE TO BE RETAINED
-  NEW TREE

Type	Botanical Name	Chinese Name	Standard	Spacing	Remarks	Quantity
TREE						
ALE.MOL.	ALEURITES MOLUCCANA	紅木	5000(H)x2500(S)x100mm TRUNK DIA. AS SHOWN		CONTAINER GROWN	4
ARC.ALE.	ARCHONTOPHOENIX ALEXANDRAE	紅棕	6000(H)x3000(S)x150mm TRUNK DIA. AS SHOWN		CONTAINER GROWN	11

 

REV	DESCRIPTION	BY	DATE	APPROVED	REV	DESCRIPTION	BY	DATE	APPROVED
	B TENDER ADDENDUM NO.2	AC	30NOV09	TM					
	A TENDER ADDENDUM	AC	30OCT09	TM					

DRAWN	SK
DESIGNED	AC
CHECKED	KN
APPROVED	TM
DATE	30/OCT/09




EXPRESS RAIL LINK

ATKINS Supported by Arup, TFP Farrelis, DLS Kenneth Ng



CADD REF. 820.T.380.ATK.A58.859B.dgn

TITLE		CONTRACT 820 MEI LAI ROAD TO HOI TING ROAD TUNNELS SHAM SHUI PO DISTRICT LANDSCAPE PLAN - TREE PLANTING (SHEET 8 OF 12)	
SCALE	DRAWING NO.	REV.	
1 : 500 (A1)	820/T/380/ATK/A58/859	B	


maps reproduced with permission of the Director of Land, Housing and Planning Department

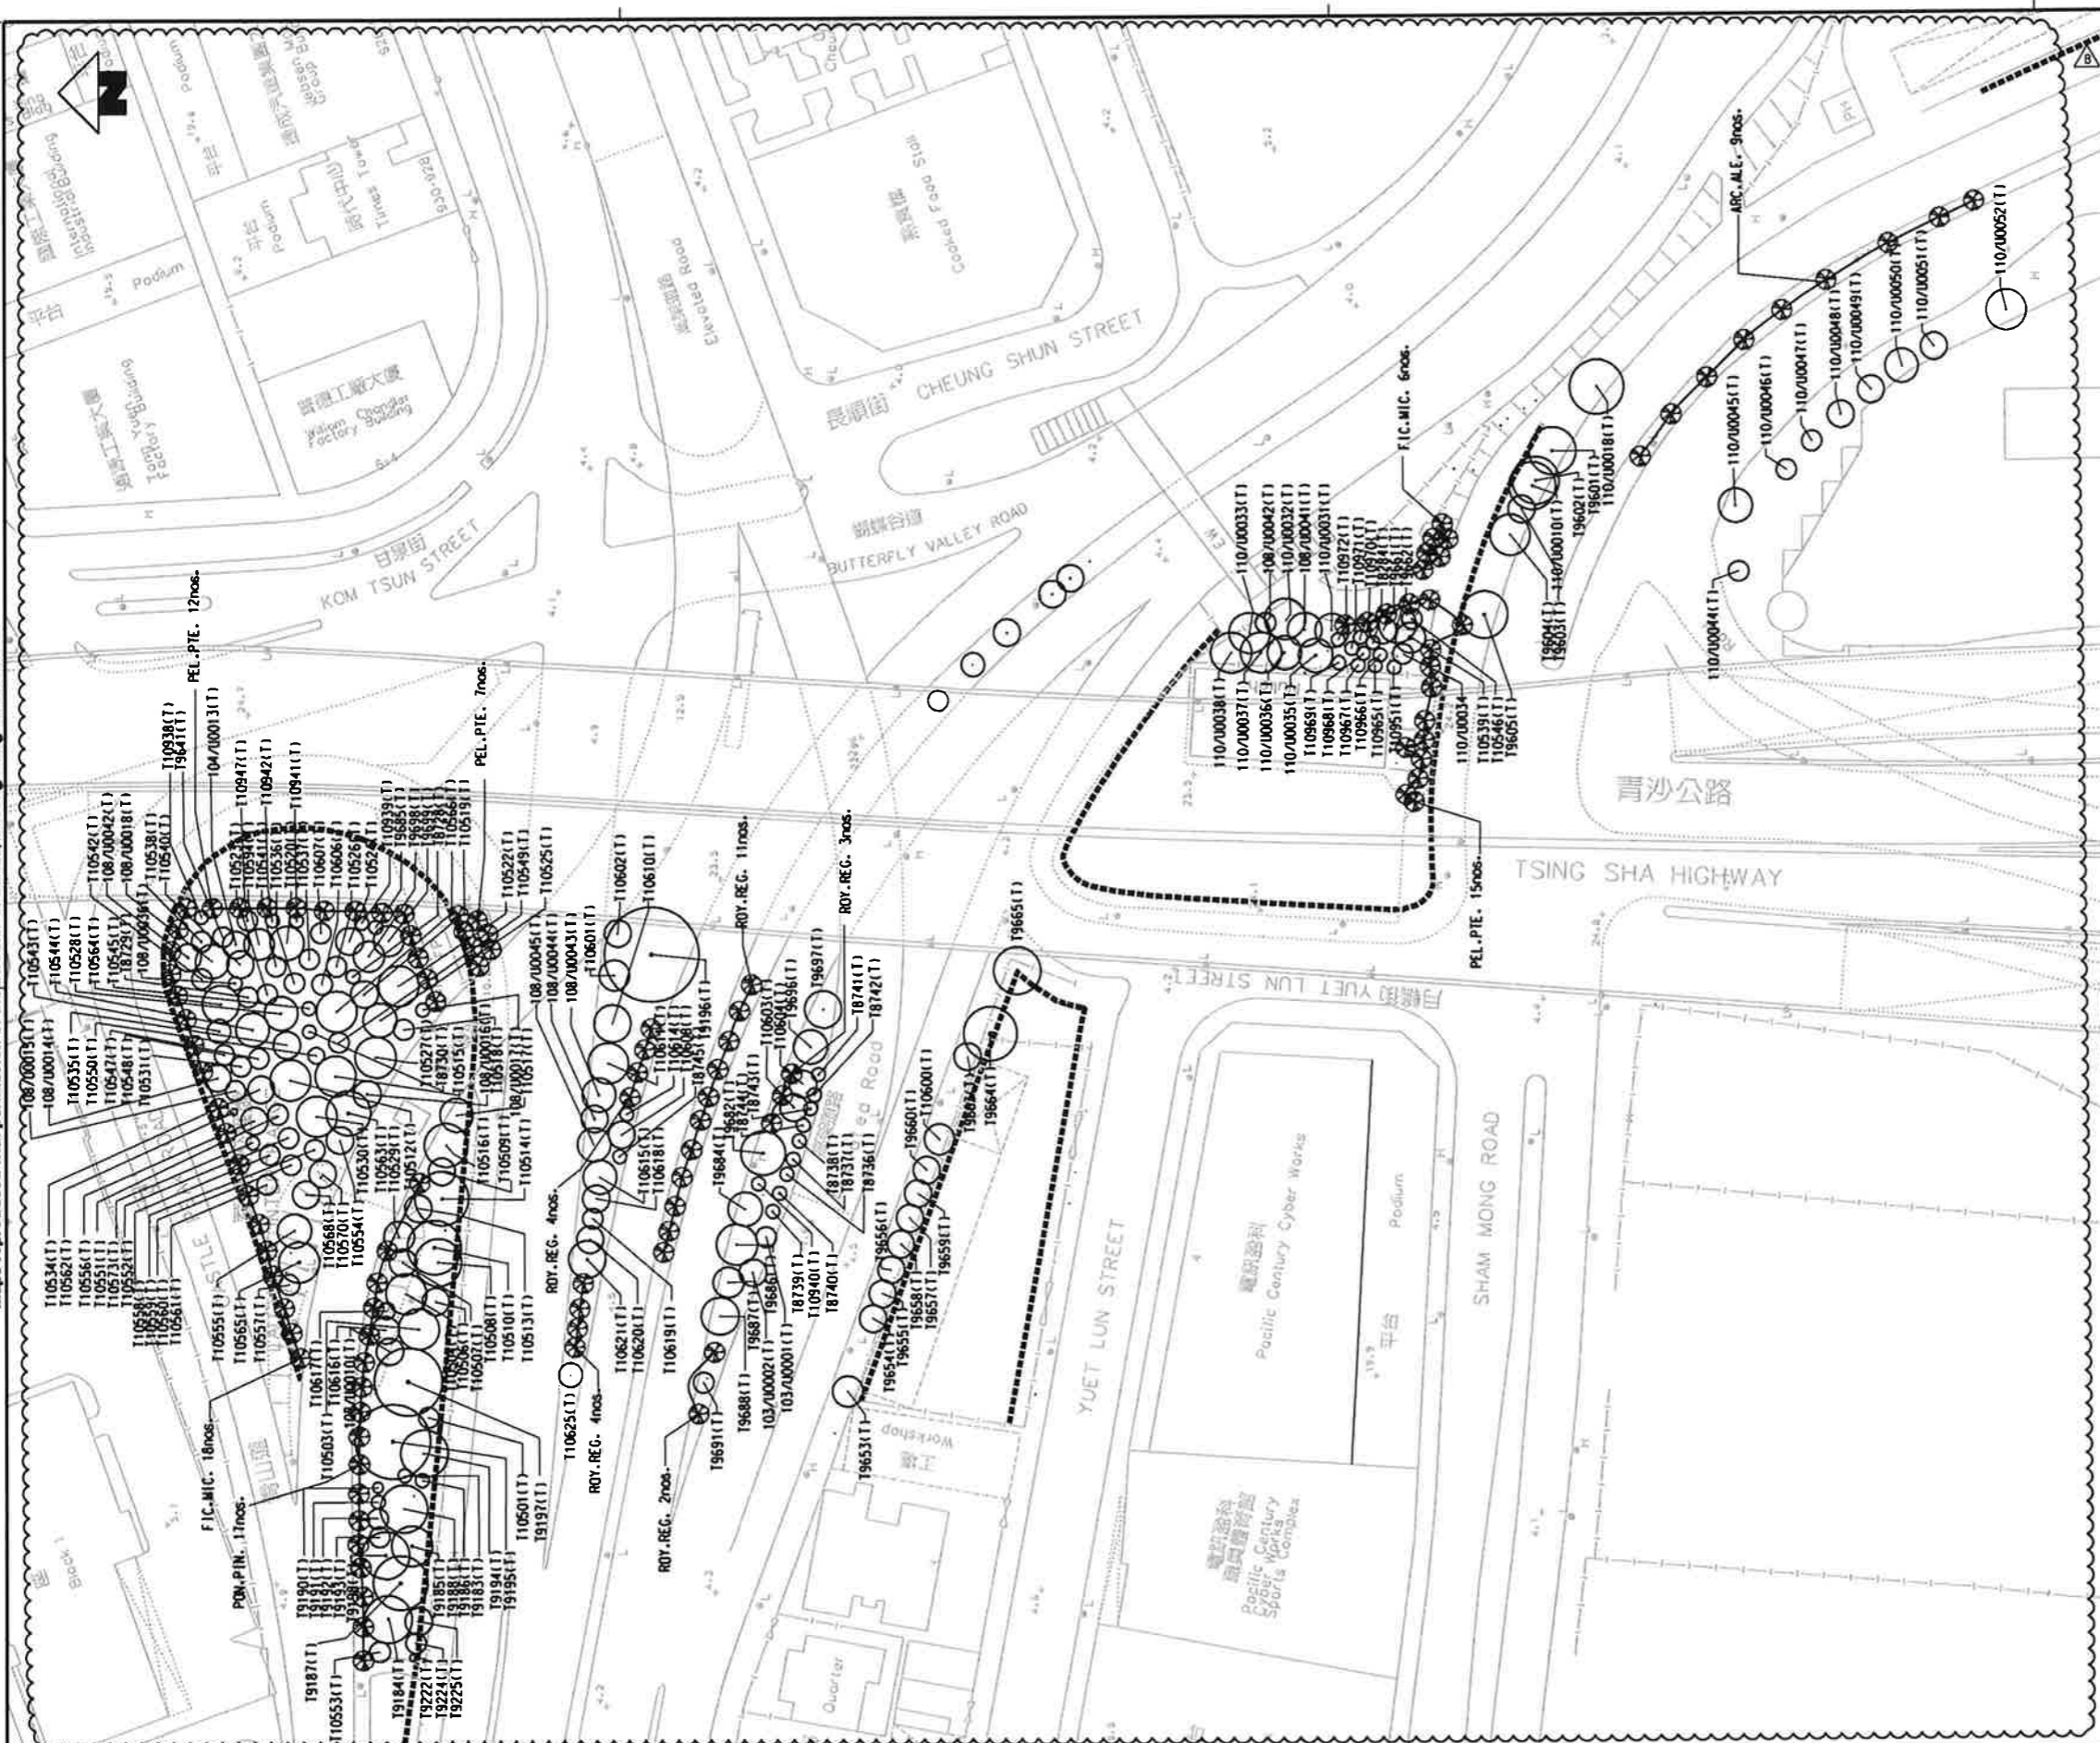

NOTES: FOR GENERAL LEGEND REFER TO DWG. NO. 820/T/NCV/ATK/A58/801

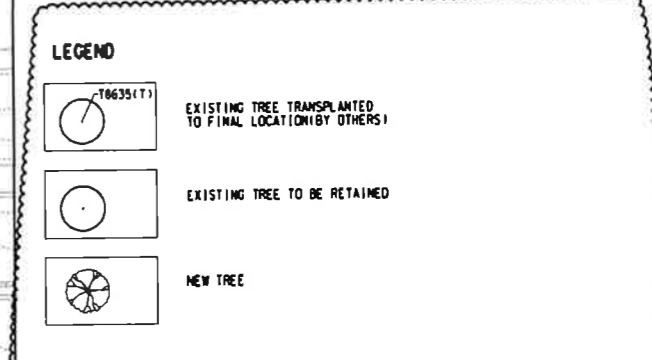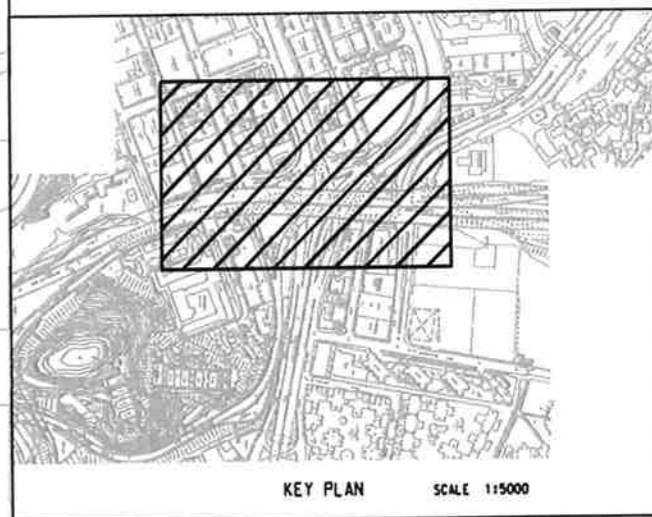

Type	Botanical Name	Chinese Name	Standard	Spacing	Remarks	Quantity
樹種	學名	中文名稱	規格	間距	備註	數量
TREE						
ARC.ALE.	ARCHONTOPHOENIX ALEXANDRAE		6000(H)X3000(S)X150mm TRUNK DIA. AS SHOWN		CONTAINER GROWN	9
FIC.MIC.	FICUS MICROCARPA		4000(H)X3000(S)X100mm TRUNK DIA. AS SHOWN		CONTAINER GROWN	24
PEL.PTE.	PELTOPHORUM PTEROCARPUM		5000(H)X2500(S)X100mm TRUNK DIA. AS SHOWN		CONTAINER GROWN	34
POM.PIN.	PONGAMIA PINNATA		4000(H)X2500(S)X100mm TRUNK DIA. AS SHOWN		CONTAINER GROWN	17

 

REV	DESCRIPTION	BY	DATE	APPROVED	REV	DESCRIPTION	BY	DATE	APPROVED
B	TENDER ADDENDUM NO. 2	AC	30/07/09	TM					
A	TENDER ADDENDUM	AC	30/07/09	TM					

DRAWN	SK
DESIGNED	AC
CHECKED	KN
APPROVED	TM
DATE	30/OCT/09

MTR


EXPRESS RAIL LINK

ORIGINATOR: **ATKINS** Supported by Arup, TFP, Farrells, DLS, Kenneth Ng


CAAD REF. 820_T_380_ATK_A58_8608.dgn


 

TITLE: **CONTRACT 820**
MEI LAI ROAD TO HOI TING ROAD TUNNELS
 SHAM SHUI PO DISTRICT
LANDSCAPE PLAN - TREE PLANTING
 (SHEET 9 OF 12)

SCALE: 1:500 (A1) DRAWING NO. 820/T/380/ATK/A58/860 REV. B

 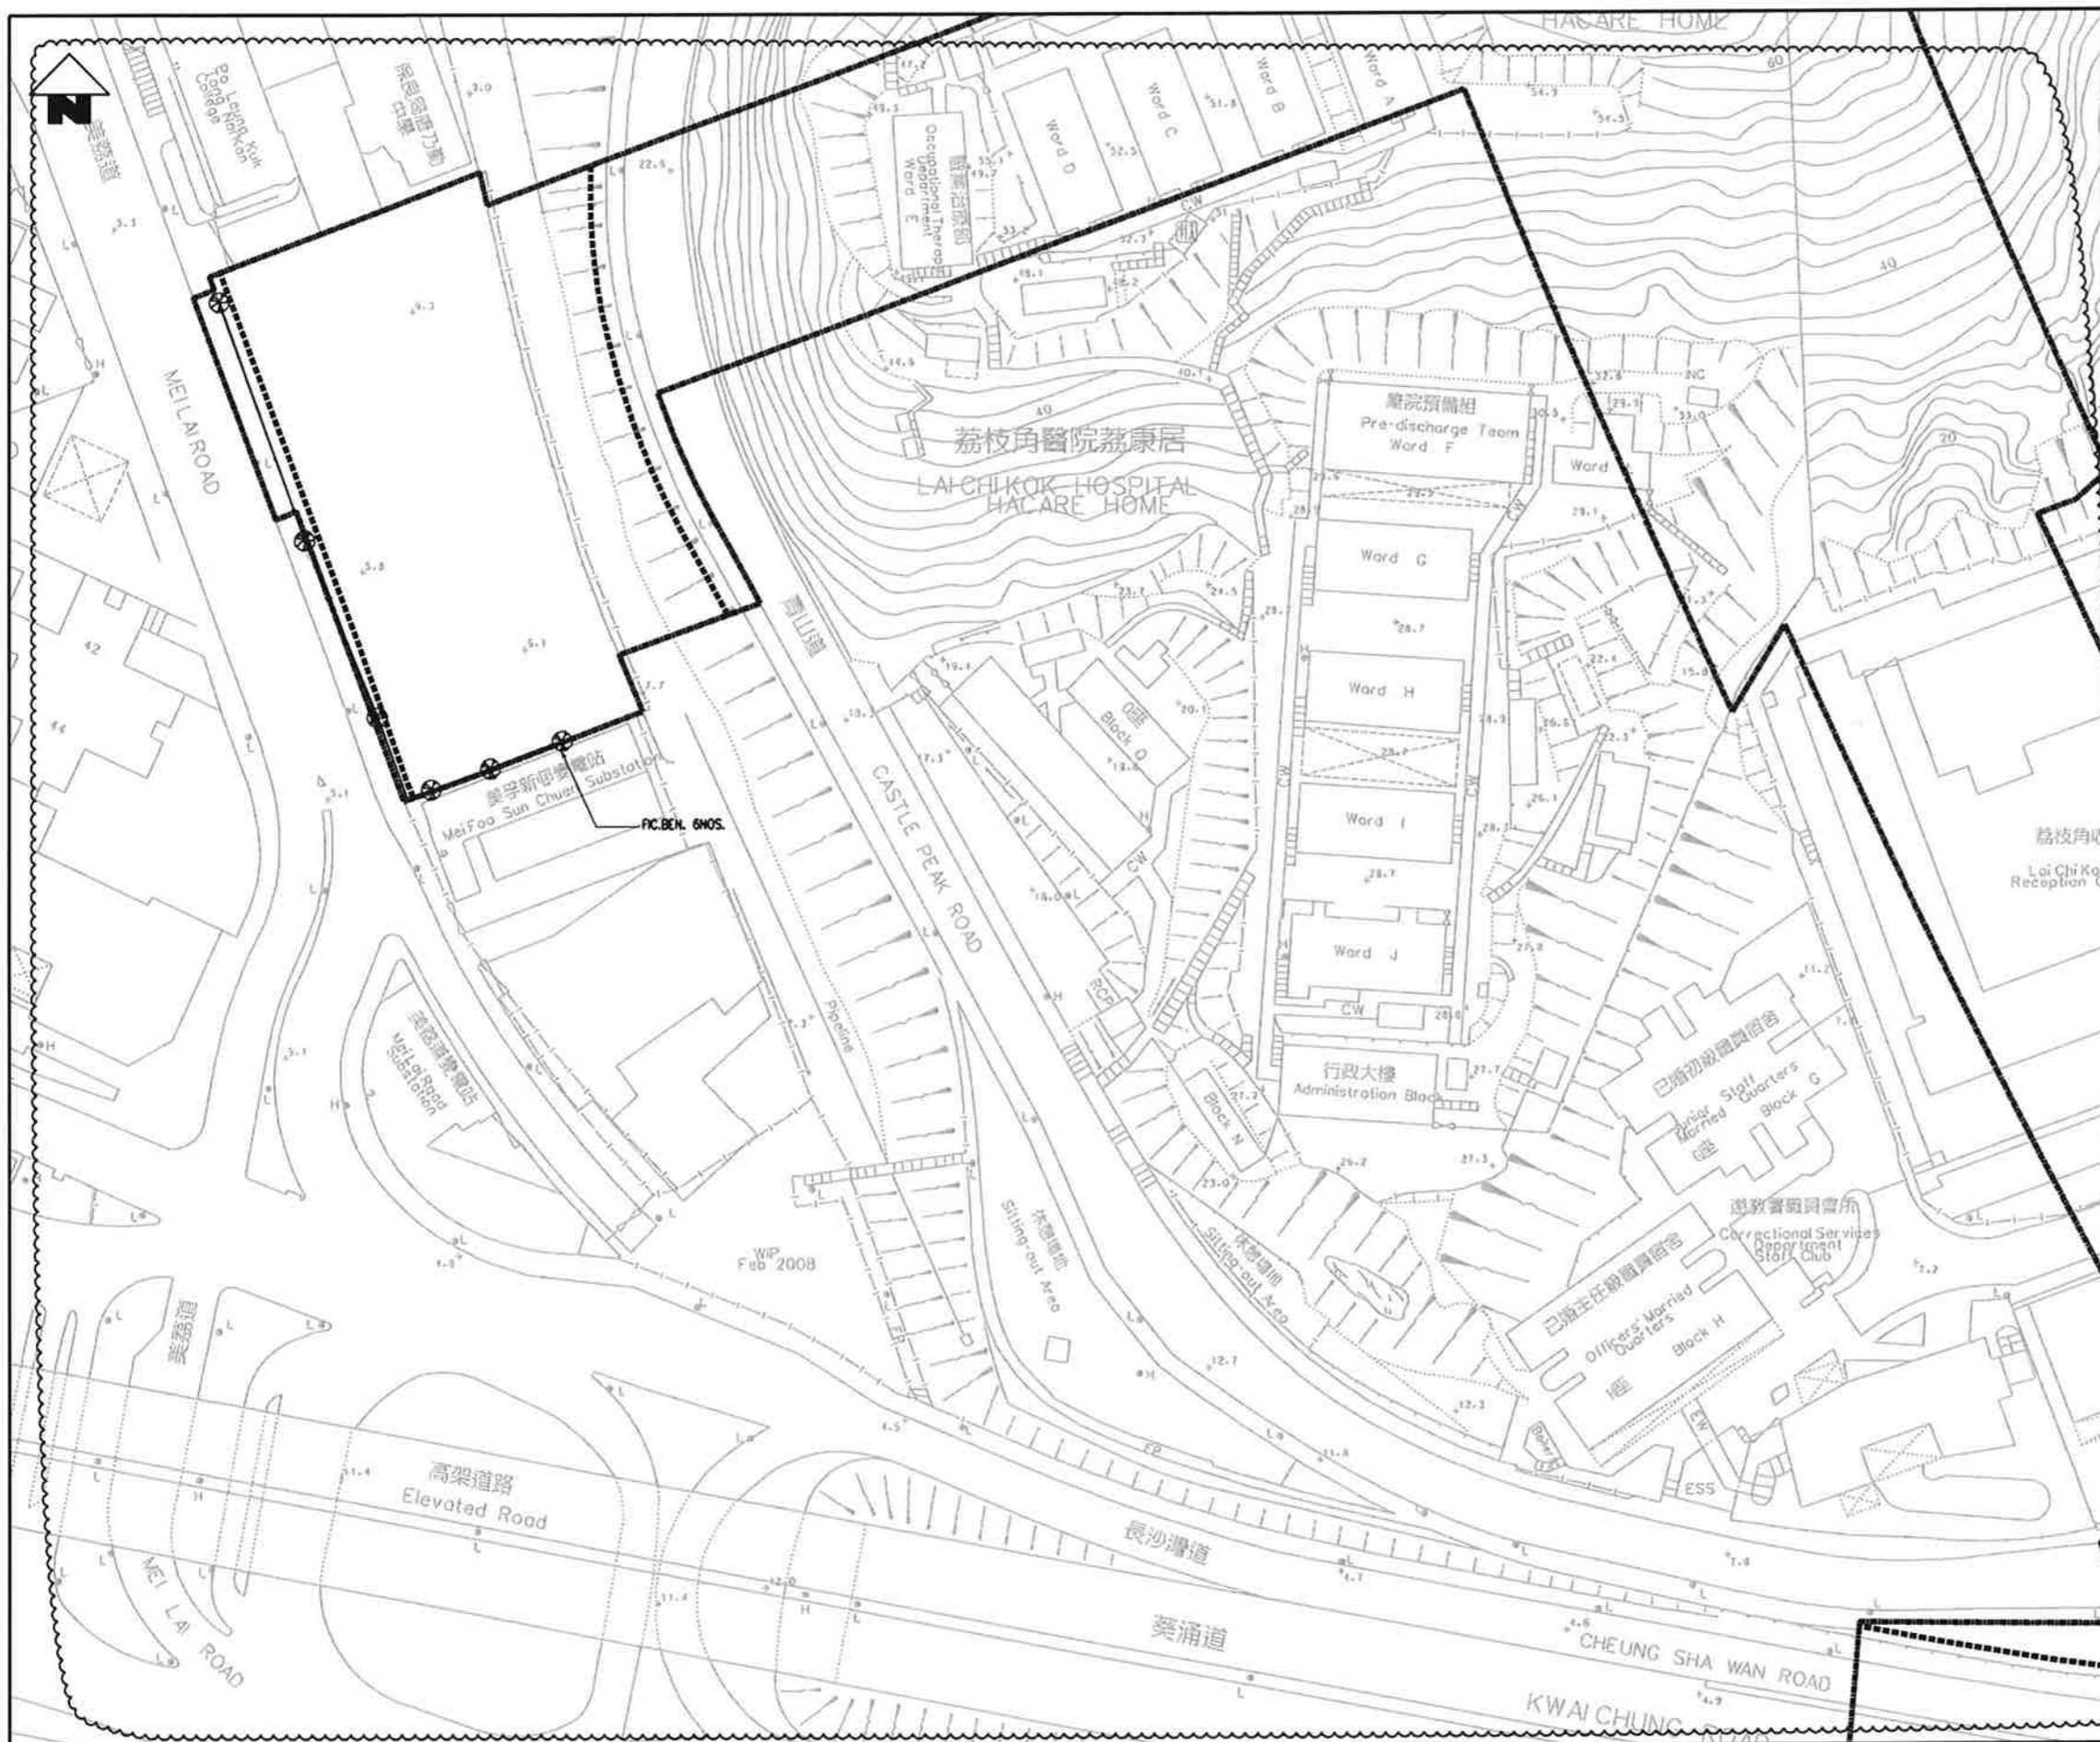


NOTES: FOR GENERAL LEGEND REFER TO DWG. NO. 820/T/NCV/ATK/A58/801

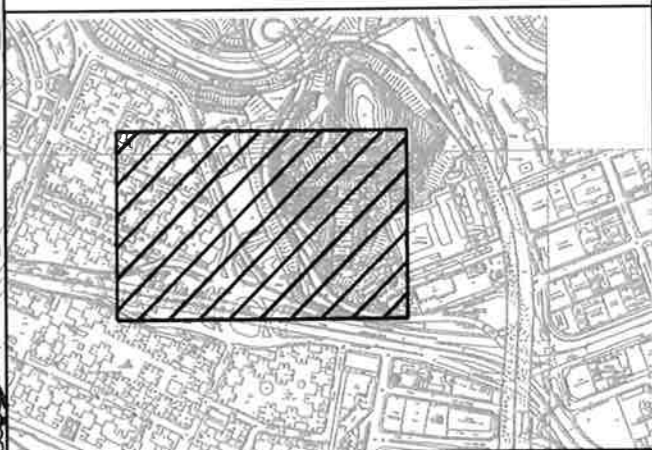



-  EXISTING TREE TRANSPLANTED TO FINAL LOCATION (BY OTHERS)
-  EXISTING TREE TO BE RETAINED
-  NEW TREE

Type	Botanical Name	Chinese Name	Standard	Spacing	Remarks	Quantity
FC.BEN.	FICUS BENJAMINA	銀葉白蠟樹	4000(H)X4000(S)X150mm TRUNK DIA.	AS SHOWN	CONTAINER GROWN	6





REV	DESCRIPTION	BY	DATE	APPROVED	REV	DESCRIPTION	BY	DATE	APPROVED
B	TENDER ADDENDUM NO.2	AC	30NOV09	TM					
A	TENDER ADDENDUM	AC	30OCT09	TM					

DRAWN SK
 DESIGNED AC
 CHECKED KN
 APPROVED TM
 DATE 30/OCT/09


 
 
 **MTR**
 EXPRESS RAIL LINK
 ORIGINATOR
 **ATKINS**
 Supported by Arup, TFP Farrells, DLS Kenneth Ng
 CADD REF. 820_T_380_ATK_A58_861B.dgn

TITLE **CONTRACT 820**
MEI LAI ROAD TO HOI TING ROAD TUNNELS
 SHAM SHUI PO DISTRICT
 LANDSCAPE PLAN - TREE PLANTING
 (SHEET 10 OF 12)
 SCALE 1 : 500 (A1)
 DRAWING NO. 820/T/380/ATK/A58/861
 REV. B

 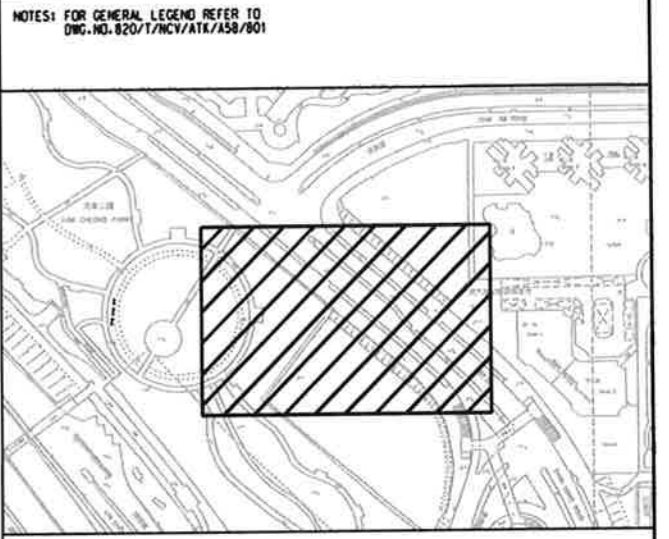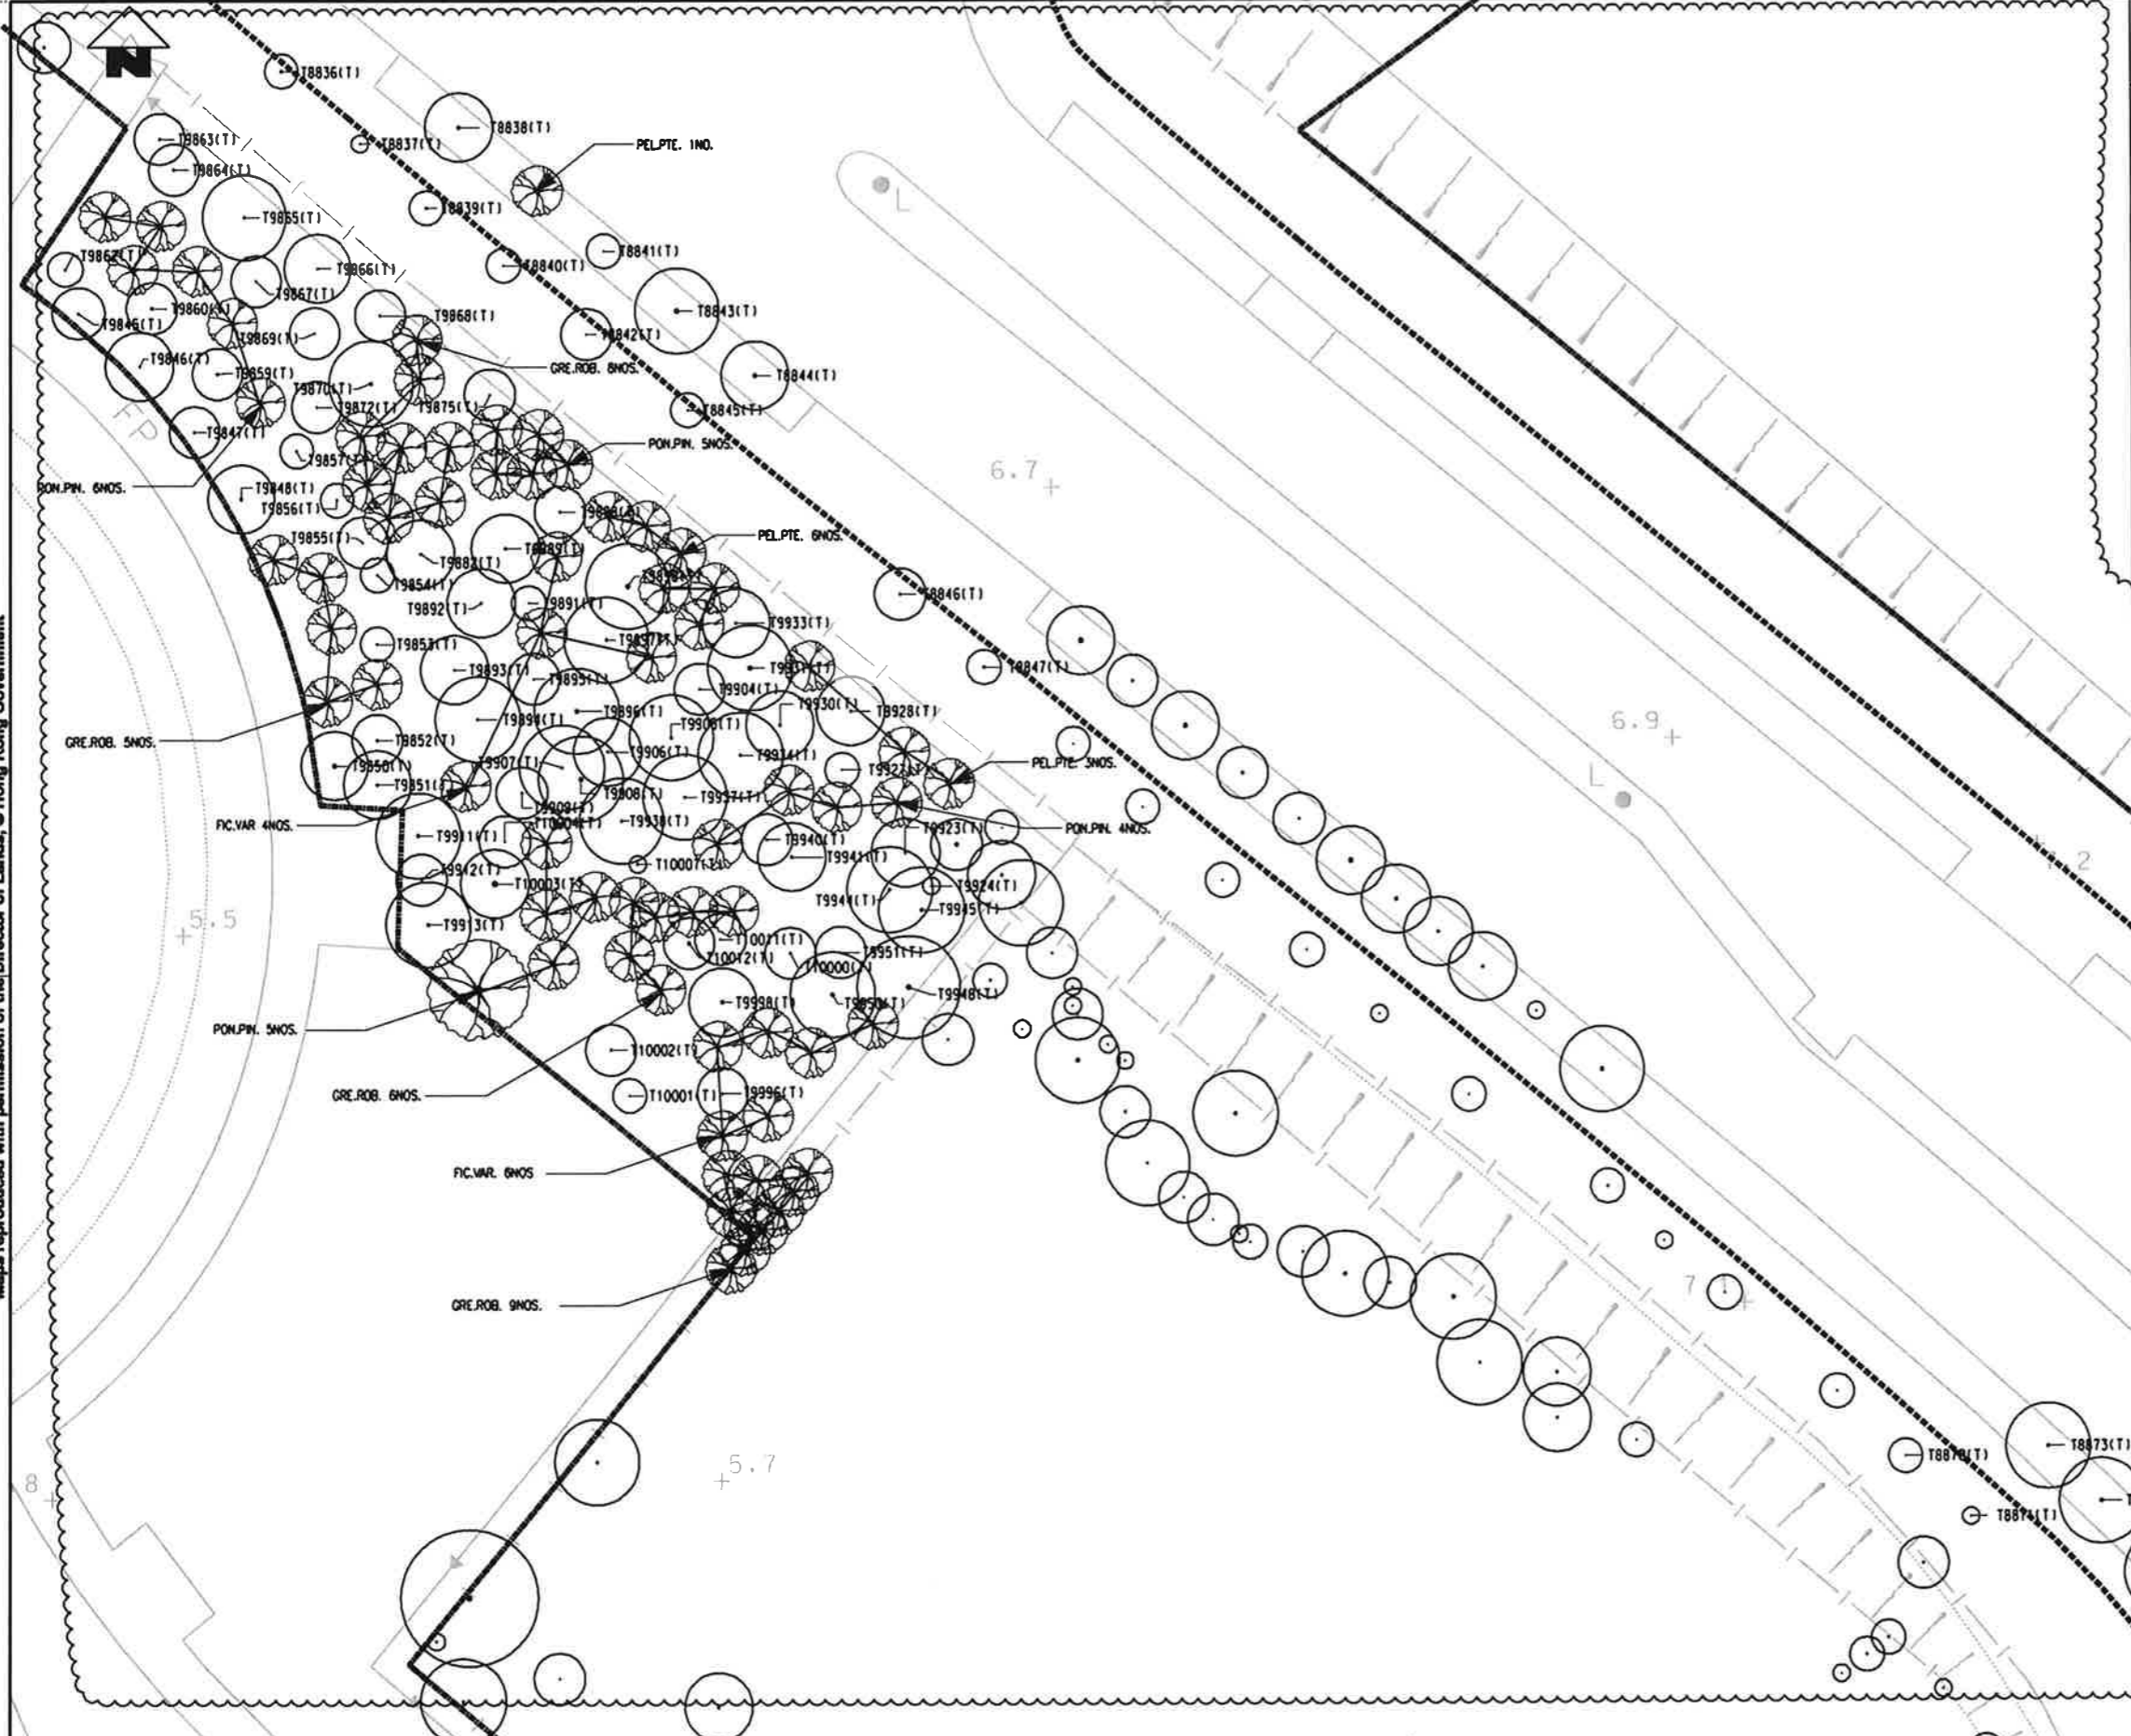


KEY PLAN SCALE 1:5000



LEGEND

-  EXISTING TREE TRANSPLANTED TO FINAL LOCATION (BY OTHERS)
-  EXISTING TREE TO BE RETAINED
-  NEW TREE

Type	Botanical Name	Chinese Name	Standard	Spacing	Remarks	Quantity
樹種	學名	中文名稱	規格	間距	註	數量
TREE						
GRE. ROB.	GREVILLEA ROBUSTA	銀葉樹	5000(H)X2000(S)X100mm TRUNK DIA. AS SHOWN		CONTAINER GROWN	10
PON. PIN.	PONGAMIA PINNATA	大葉欖	4000(H)X2500(S)X100mm TRUNK DIA. AS SHOWN		CONTAINER GROWN	20
PEL. PTE.	PELTOPHORUM PTEROCARPUM	銀葉樹	5000(H)X2500(S)X100mm TRUNK DIA. AS SHOWN		CONTAINER GROWN	10
FIC. MC.	FICUS MICROCARPA	細葉欖	4000(H)X3000(S)X100mm TRUNK DIA. AS SHOWN		CONTAINER GROWN	28



REV	DESCRIPTION	BY	DATE	APPROVED	REV	DESCRIPTION	BY	DATE	APPROVED
B	TENDER ADDENDUM NO.2	AC	30NOV09	TM					
A	TENDER ADDENDUM	AC	30OCT09	TM					



 **EXPRESS RAIL LINK**
 Supported by Arup, TFP, Farrells, DLS, Kenneth Ng
 CADD REF. 821.T_370.ATK.A58.862B

CONTRACT 820
MEI LAI ROAD TO HOI TING ROAD TUNNELS
SHAM SHUI PO DISTRICT
LANDSCAPE PLAN - TREE PLANTING
(SHEET 11 OF 12)

SCALE 1 : 200 (A1) DRAWING NO. 820/T/380/ATK/A58/862 REV. B

Type	Botanical Name	Chinese Name	Standard	Spacing	Remarks	Quantity
種類	學名	中文名稱	規格	間距	註	數量
TREE 樹類						
ARC.ALE.	ARCHONTOPHOENIX ALEXANDRAE	銀劍椰	6000(H)x3000(S)x150mm TRUNK DIA.	AS SHOWN	CONTAINER GROWN	52
BAU.VAR.	BAUHINIA VARIEGATA	宮粉洋紫荊	5000(H)x4000(S)x100mm TRUNK DIA.	AS SHOWN	CONTAINER GROWN	6
ROY.REG.	ROYSTONEA REGIA	玉桂	7000(H)x5000(S)x200mm TRUNK DIA.	AS SHOWN	CONTAINER GROWN	19
FIC.BEN.	FICUS BENJAMINA	垂葉榕	4000(H)x4000(S)x150mm TRUNK DIA.	AS SHOWN	CONTAINER GROWN	19
GRE.ROB.	GREVILLEA ROBUSTA	銀樟	5000(H)x2000(S)x100mm TRUNK DIA.	AS SHOWN	CONTAINER GROWN	11
PON.PIN.	PONGAMIA PINNATA	水黃皮	4000(H)x2500(S)x100mm TRUNK DIA.	AS SHOWN	CONTAINER GROWN	37
PEL.PTE.	PELTOPHORUM PTEROCARPUM	雙翼豆	5000(H)x2500(S)x100mm TRUNK DIA.	AS SHOWN	CONTAINER GROWN	46
FIC.MIC.	FICUS MICROCARPA	超榕	4000(H)x3000(S)x100mm TRUNK DIA.	AS SHOWN	CONTAINER GROWN	70
ALE.MOL.	ALEURITES MOLUCCANA	石栗	5000(H)x2500(S)x100mm TRUNK DIA.	AS SHOWN	CONTAINER GROWN	21
TOTAL						281


REV				DESCRIPTION				BT		DATE		APPROVED		REV		DESCRIPTION		BT		DATE		APPROVED															
				B TENDER ADDENDUM NO.2				AC		30NOV09		TM						DRAWN		SK		MTR		TITLE CONTRACT 820 MEI LAI ROAD TO HOI TING ROAD TUNNELS SHAM SHUI PO DISTRICT COMPENSATION TREE SCHEDULE (SHEET 12 OF 12)													
				A TENDER ADDENDUM NO.1				AC		30OCT09		TM						CHECKED		KN		EXPRESS RAIL LINK															
																		APPROVED		TM		ORIGINATOR				Supported by Arup, TFP Farrelis, DLS Kenneth Ng											
																		DATE		30/OCT/09		DO NOT SCALE DRAWINGS. ALL DIMENSIONS SHALL BE READ OFF THE SET. © HER COMPANIES LIMITED 2009. COPYRIGHT IN RESPECT OF THIS DRAWING / DOCUMENT IS OWNED BY THE HER COMPANIES LIMITED OF HONG KONG. NO REPRODUCTION OF THE DRAWING / DOCUMENT OR ANY PART OF THEM FOR ANY PURPOSE IS PERMITTED WITHOUT THE PRIOR WRITTEN CONSENT OF THE HER COMPANIES LIMITED.				CAD REF. 820_T_380_ATK_A58_863A.dgn		SCALE		NTS		DRAWING NO.		820/T/380/ATK/A58/863		REV.	

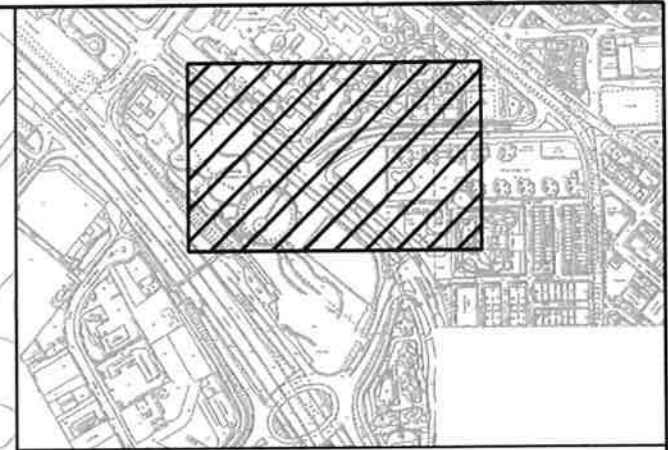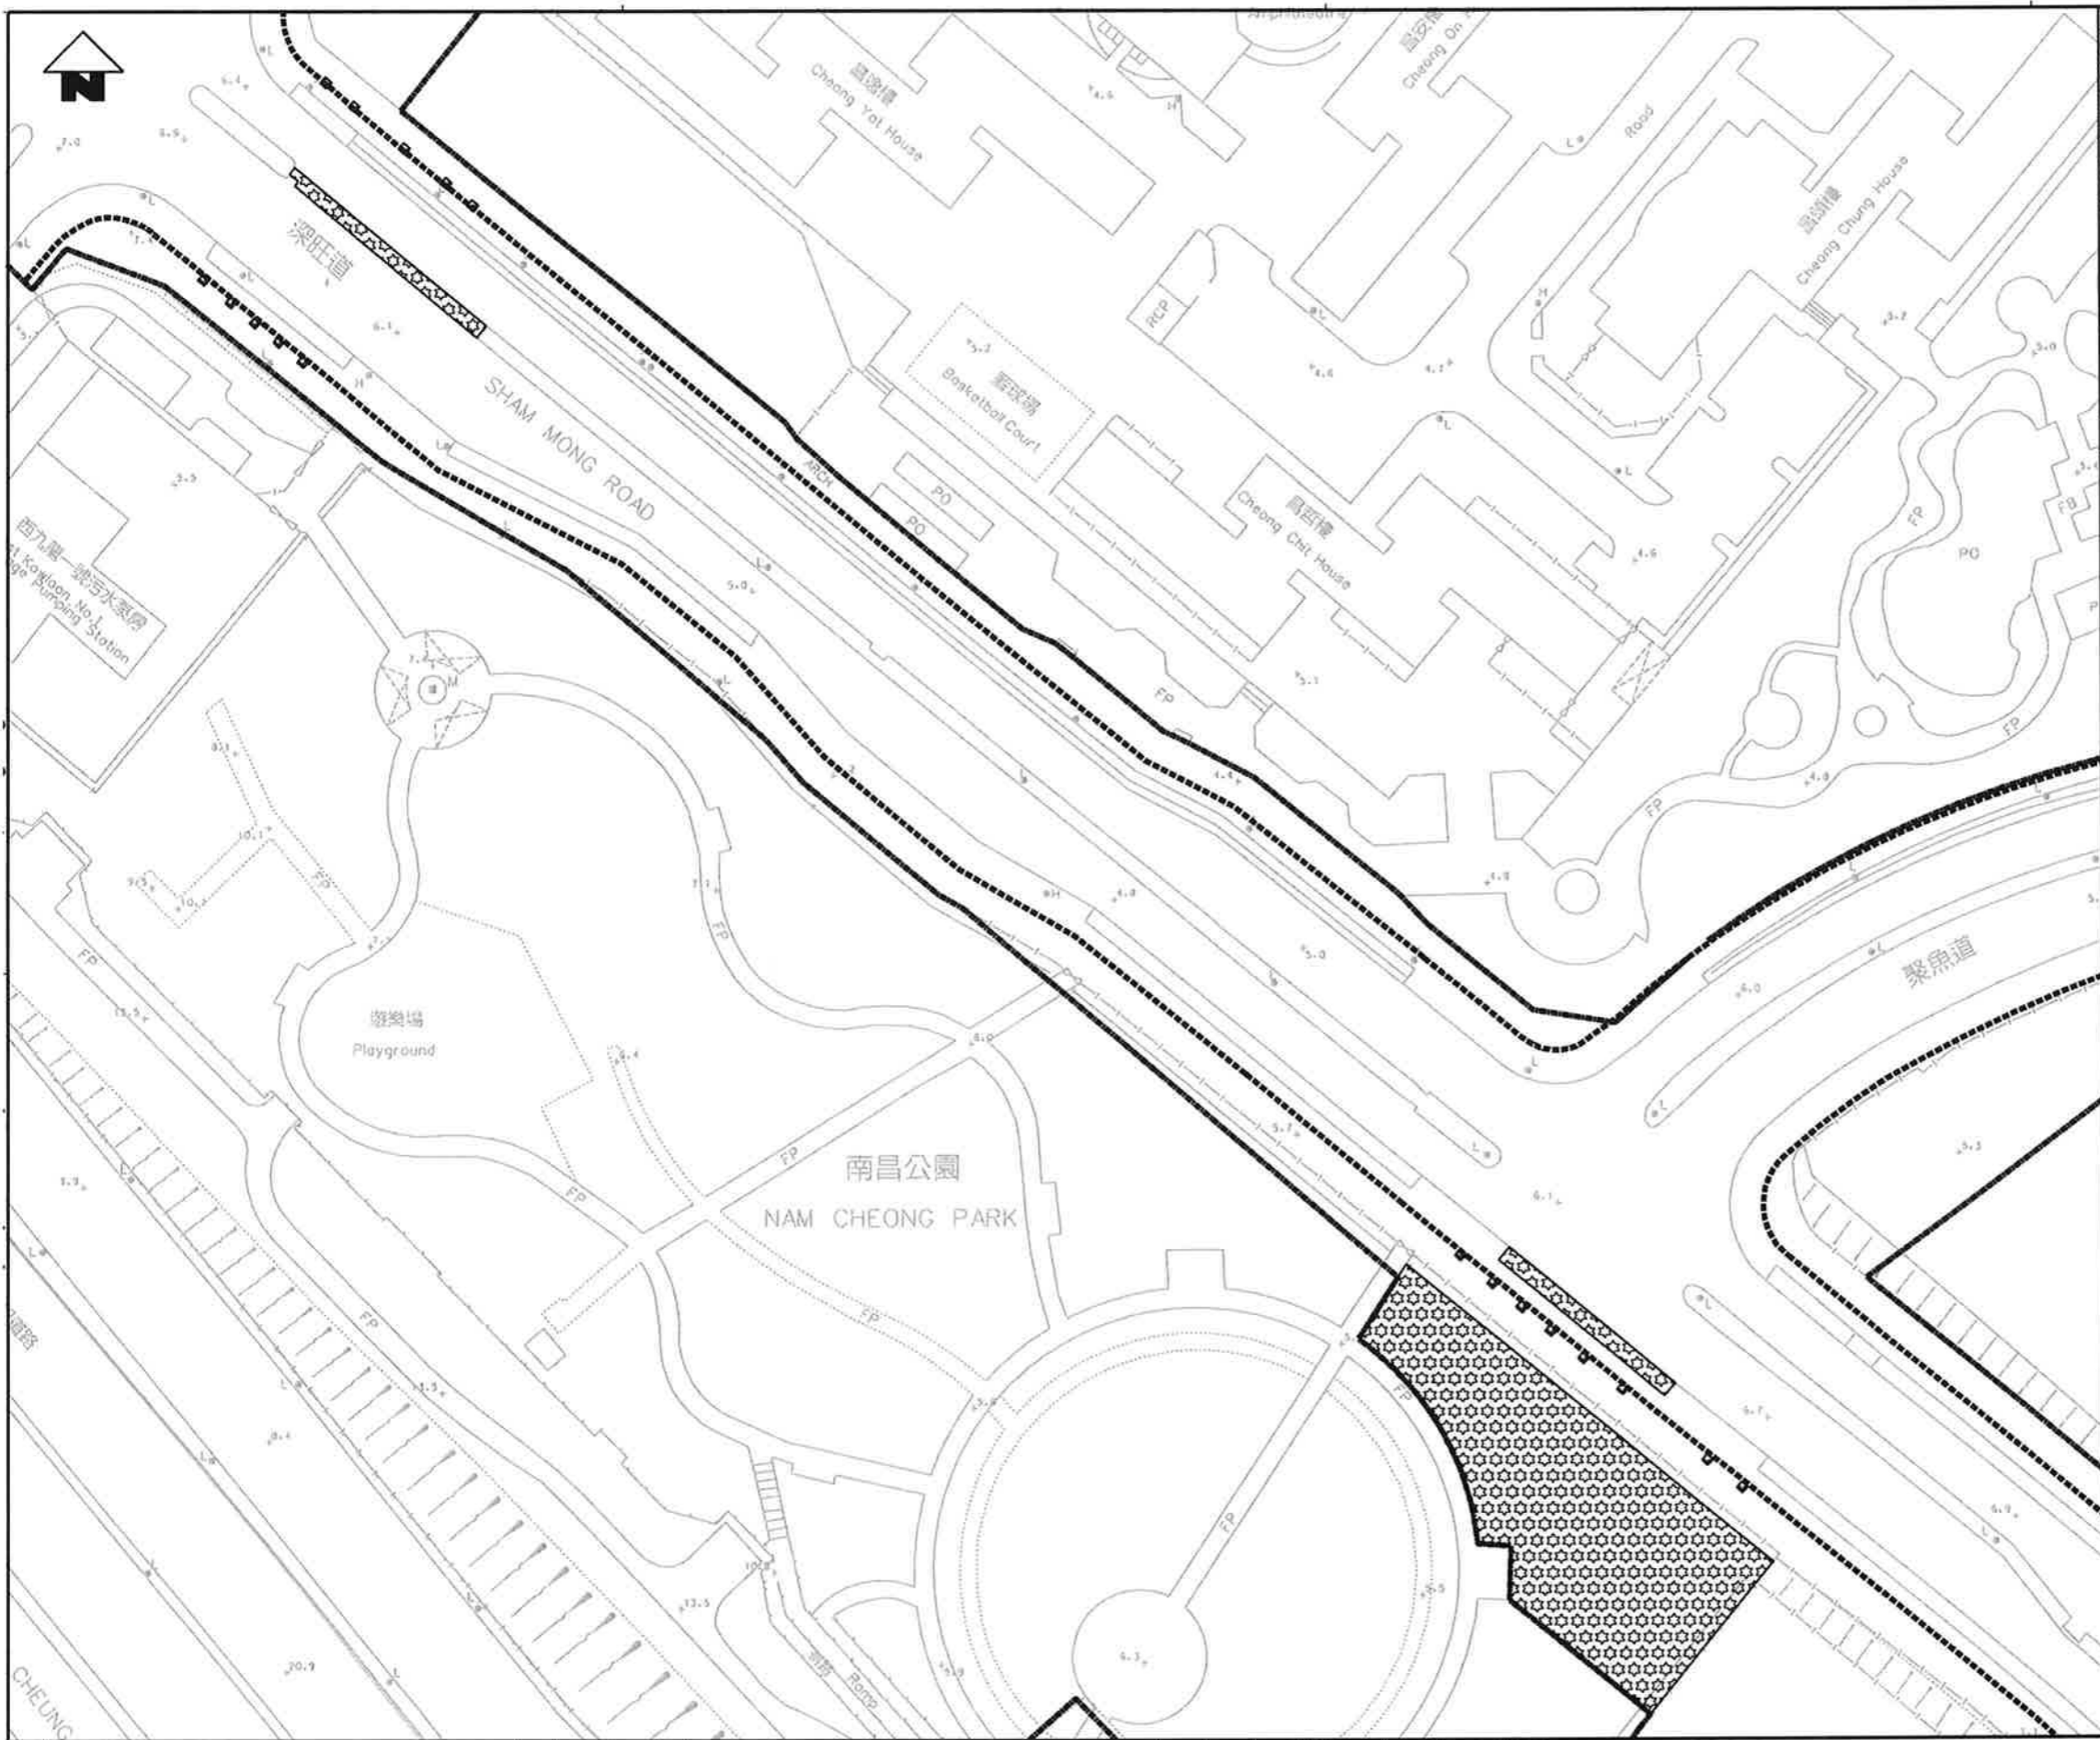



KEY PLAN SCALE 1:5000

LEGEND

  300mm DEPTH PLANTING SOIL MIX ABOVE MIN. 900mm DEPTH SUBSOIL (AREA = 1747 sqm)




 
				DRAWN SK DESIGNED AC CHECKED KN APPROVED TM DATE 30/NOV/09 <small>DO NOT SCALE DRAWINGS. ALL DIMENSIONS SHALL BE REFERRED TO SITE. © MTR CORPORATION LIMITED 2009. COPYRIGHT IN RESPECT OF THIS DRAWING / DOCUMENT IS OWNED BY THE MTR CORPORATION LIMITED OF HONG KONG. NO REPRODUCTION OF THE DRAWING / DOCUMENT OR ANY PART THEREOF IS PERMITTED WITHOUT THE PRIOR WRITTEN CONSENT OF THE MTR CORPORATION LIMITED.</small>		 MTR EXPRESS RAIL LINK ORIGINATOR ATKINS Supported by Arup, TFP, Farrells, DLS, Kenneth Ng		TITLE CONTRACT 820 MEI LAI ROAD TO HOI TING ROAD TUNNELS SHAM SHUI PO DISTRICT SOILING PLAN (SHEET 1 OF 9)	
TENDER ADDENDUM NO.2				AC 30/NOV/09 TM		CADD REF. 820_T_380_ATK_A58_864A.dgn		SCALE 1 : 500 (A1) DRAWING NO. 820/T/380/ATK/A58/864 REV. A	
REV	DESCRIPTION	BY	DATE	APPROVED	REV	DESCRIPTION	BY	DATE	APPROVED

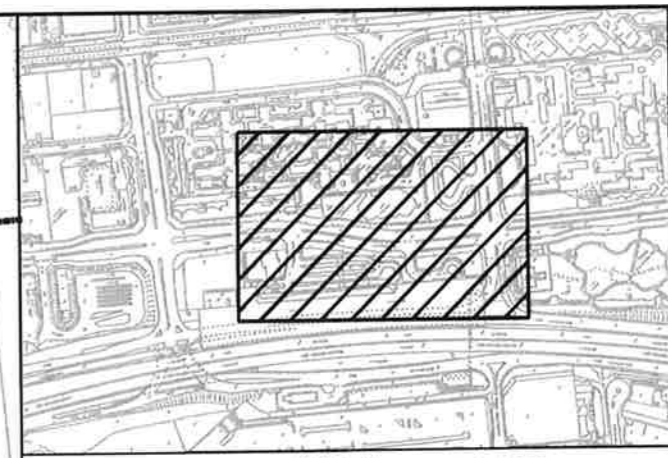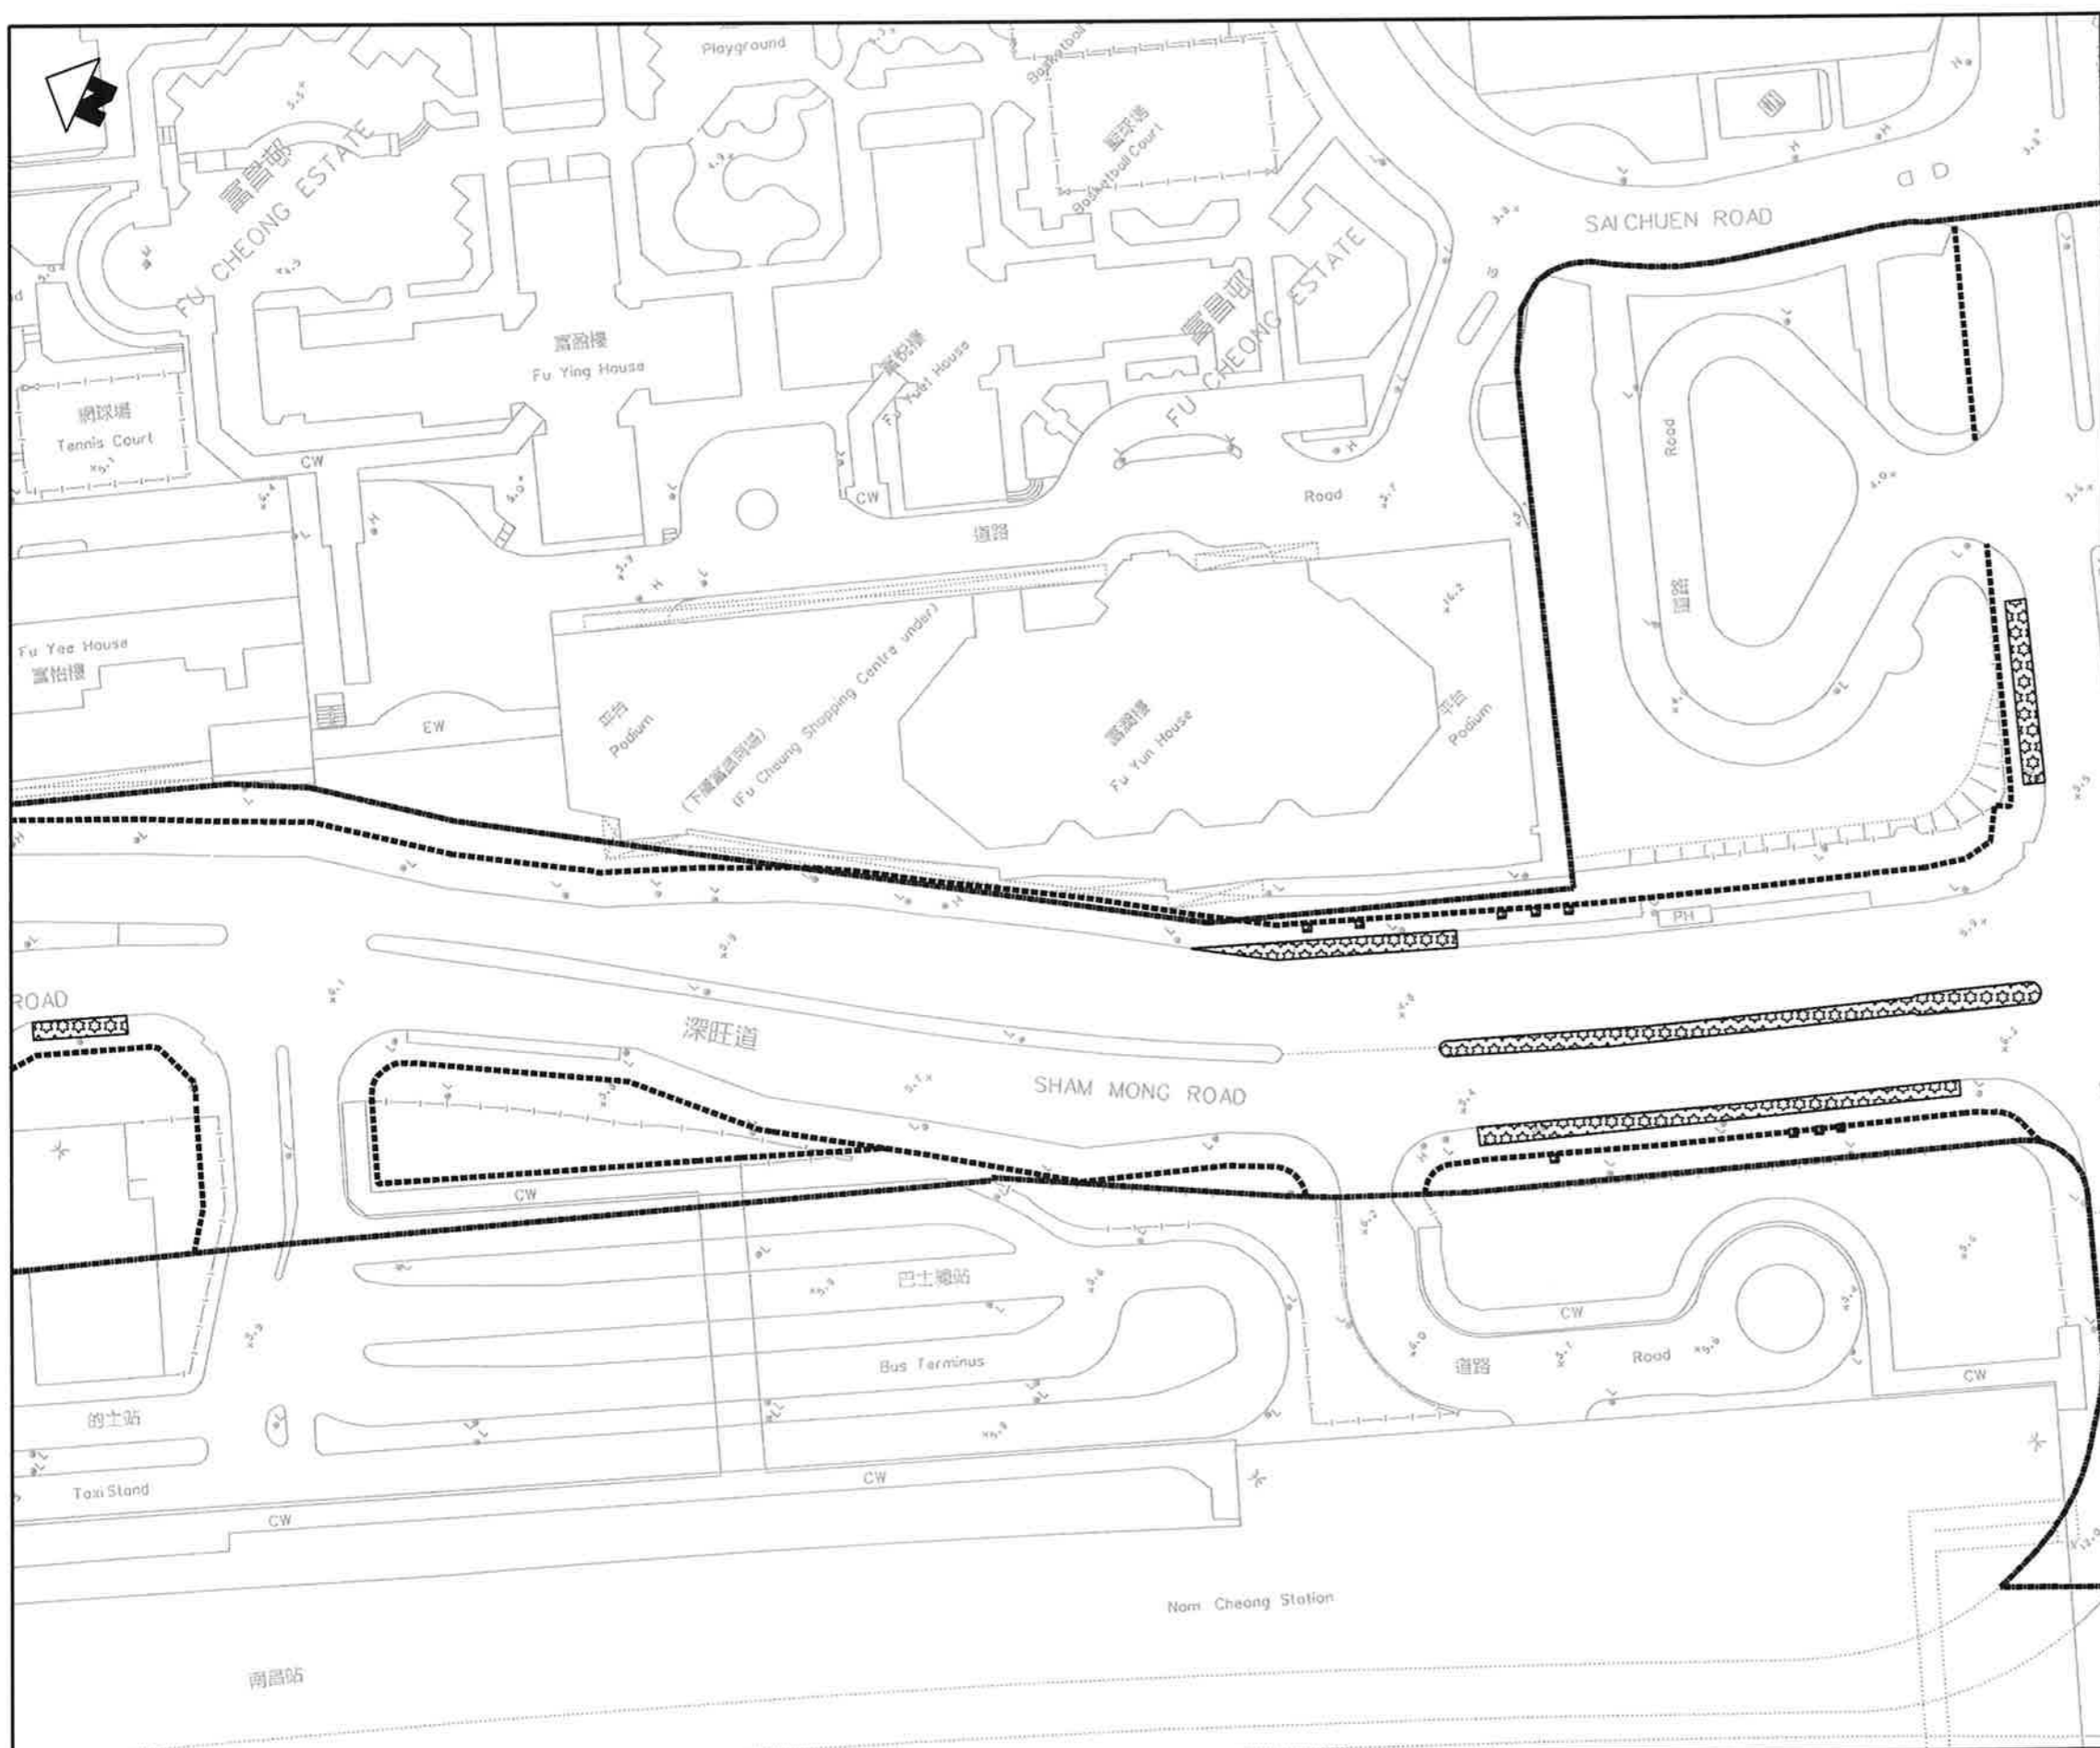





KEY PLAN SCALE 1:5000

LEGEND

 300mm DEPTH PLANTING SOIL MIX ABOVE MIN. 900mm DEPTH SUB SOIL (AREA = 617sqm)





DRAWN SK		DESIGNED AC		CHECKED KN		APPROVED TM		DATE 30/NOV/09		 EXPRESS RAIL LINK	
A TENDER ADDENDUM NO.2		AC	30NOV09	TM	 Supported by Arup, TFP Farrells, DLS Kenneth Ng		CADD REF. 820_T_380_ATK_A58_865A.dgn		TITLE CONTRACT 820 MEI LAI ROAD TO HOI TING ROAD TUNNELS SHAM SHUI PO DISTRICT SOILING PLAN (SHEET 2 OF 9)		
REV	DESCRIPTION	BY	DATE	APPROVER	REV	DESCRIPTION	BY	DATE	APPROVER	SCALE 1 : 500 (A1)	DRAWING NO. 820/T/380/ATK/A58/865 REV. A

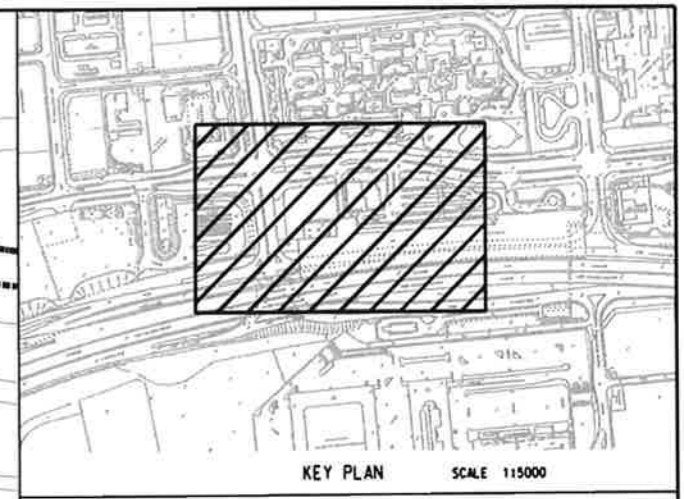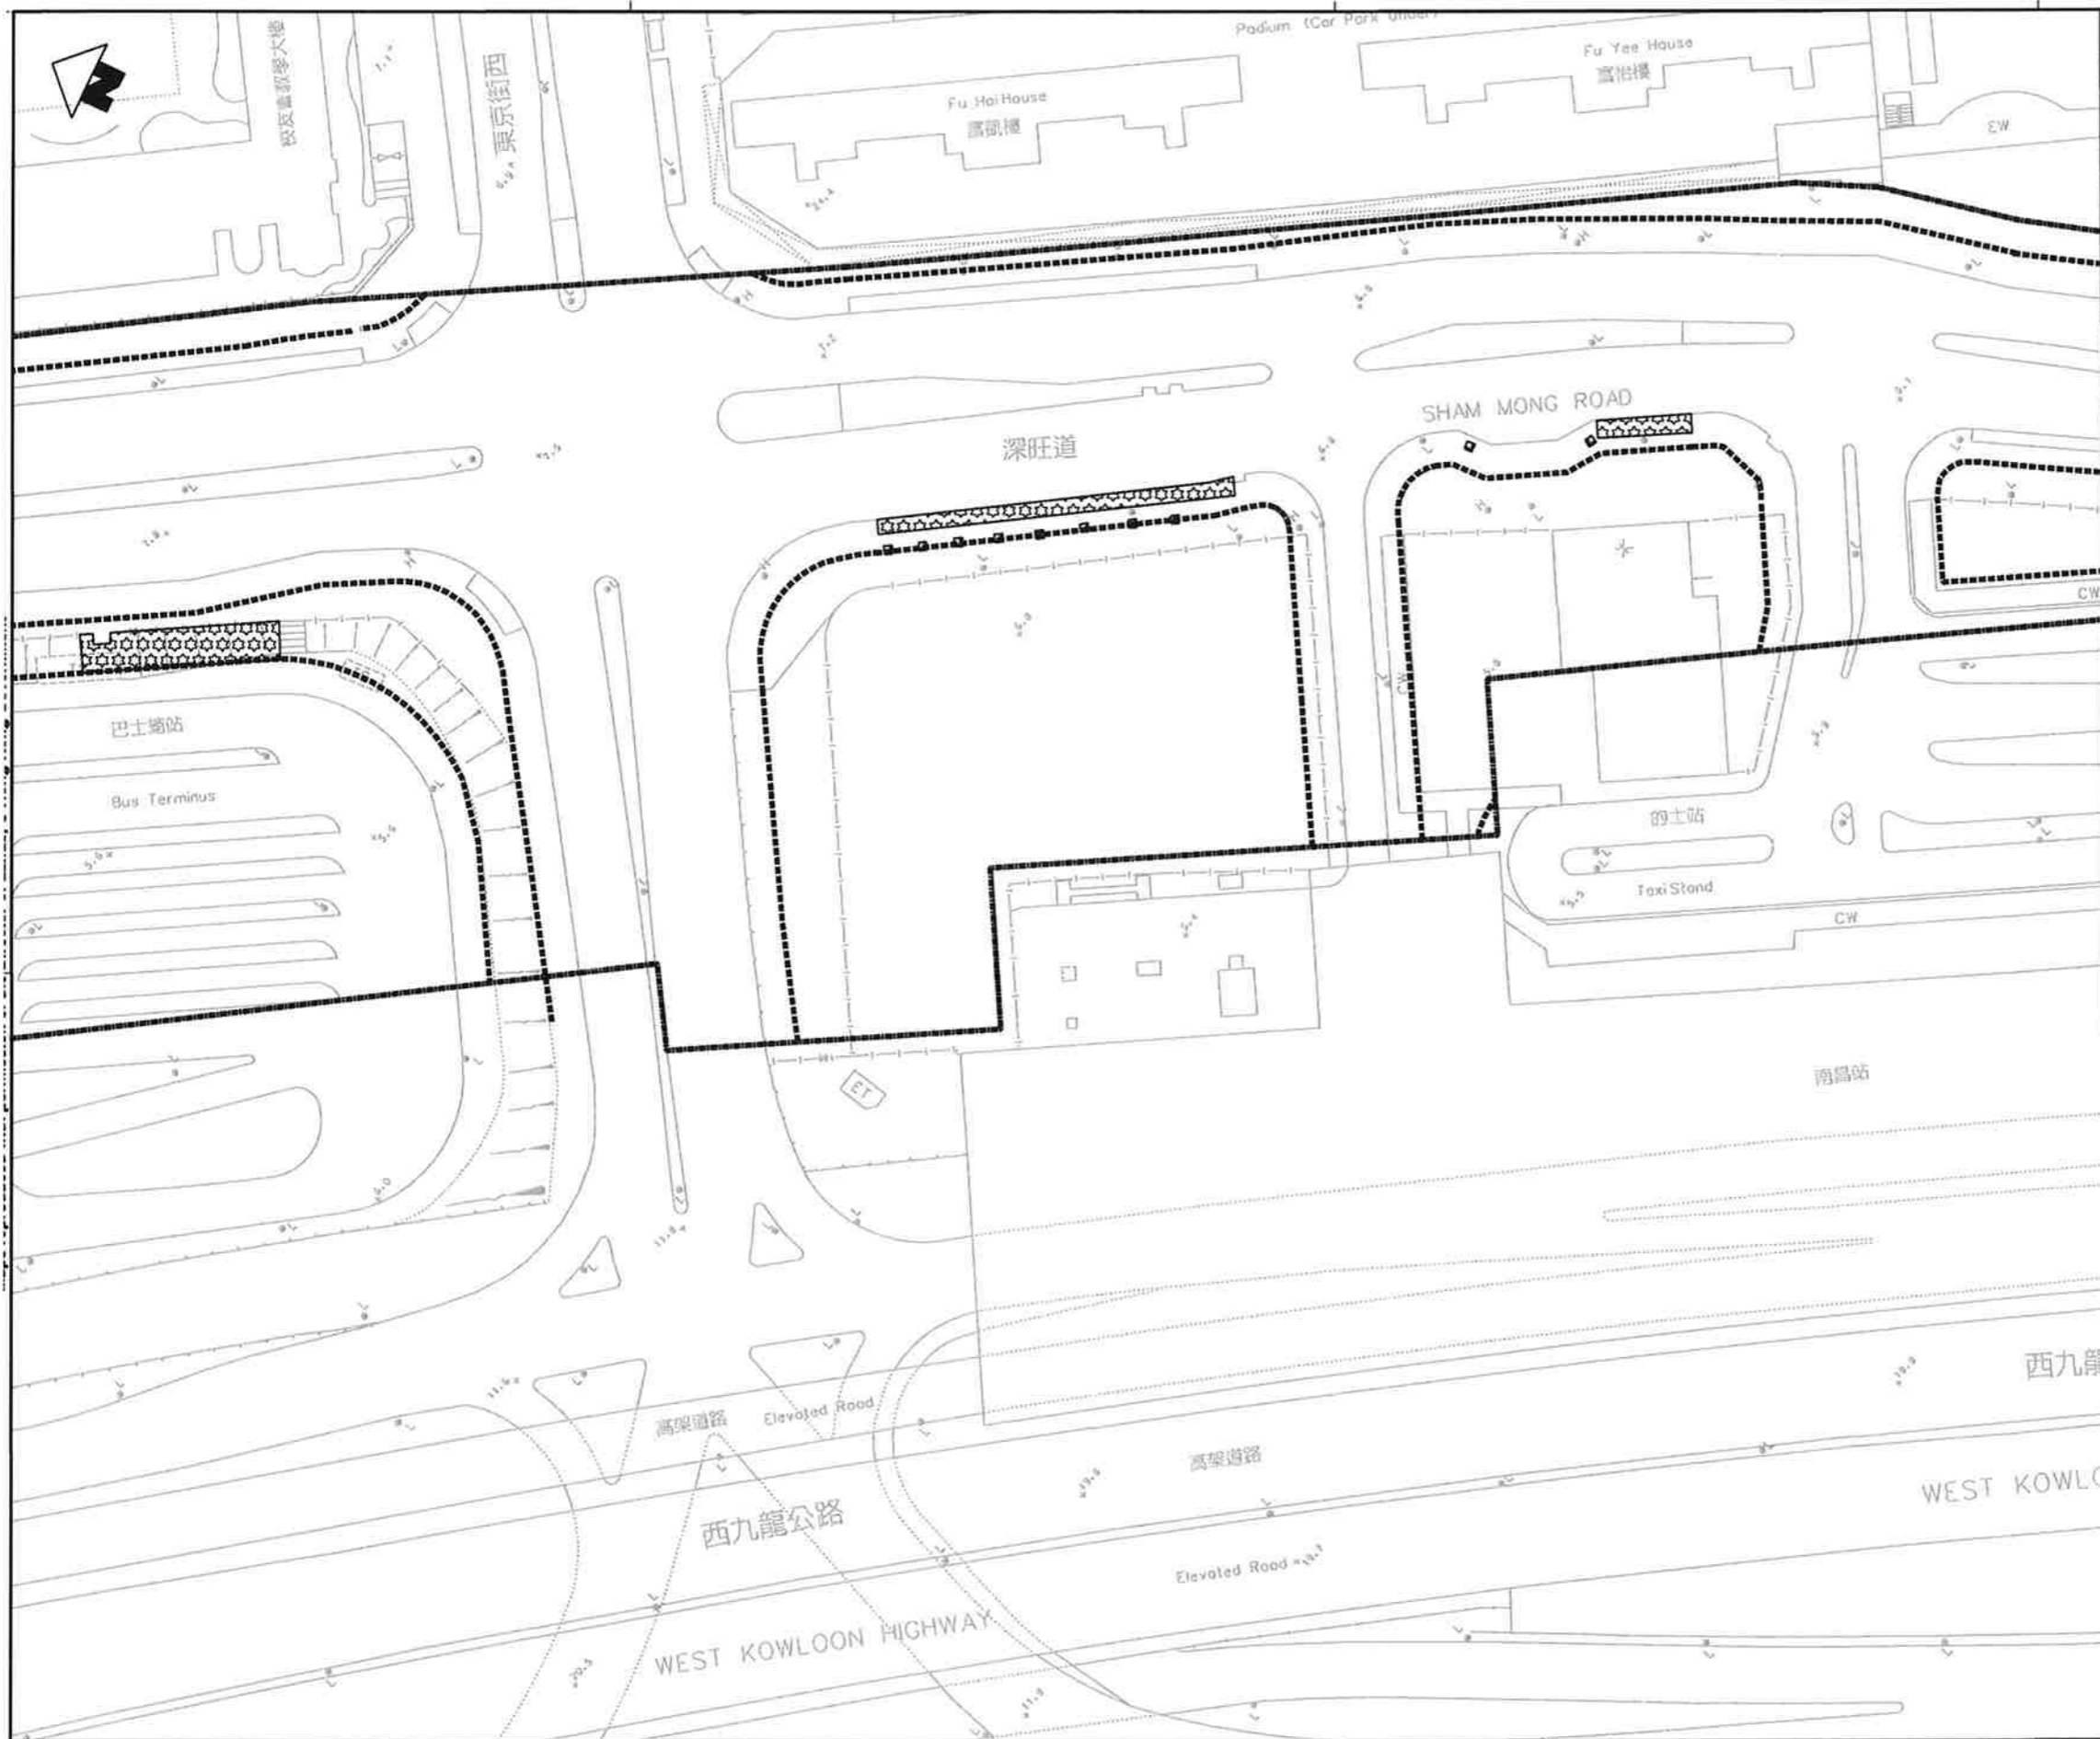



LEGEND

  300mm DEPTH PLANTING SOIL MIX ABOVE MIN. 900mm DEPTH SUB SOIL (AREA = 339sqm)




DRAWN		SK		 EXPRESS RAIL LINK ORIGINATOR ATKINS Supported by Arup, TFP, Farrells, DLS, Kenneth Ng	
DESIGNED		AC			
CHECKED		KN			
APPROVED		TM			
DATE		30/NOV/09		CADD REF. 820_T_380_ATK_A58_866A.dgn	
<small> ALL DIMENSIONS SHALL BE SHOWN ON SITE. © MTR CORPORATION LIMITED 2009. ALL RIGHTS RESERVED. REPRODUCTION OF THIS DRAWING OR DOCUMENT IS STRICTLY PROHIBITED WITHOUT THE WRITTEN CONSENT OF THE MTR CORPORATION LIMITED. </small>					
REV	DESCRIPTION	BY	DATE	APPROVED	REV
A	TENDER ADDENDUM NO.2	AC	30/NOV/09	TM	


CONTRACT 820 MEI LAI ROAD TO HOI TING ROAD TUNNELS SHAM SHUI PO DISTRICT SOILING PLAN (SHEET 3 OF 9)	
SCALE	DRAWING NO. 820/T/380/ATK/A58/866
1 : 500 (A1)	REV. A

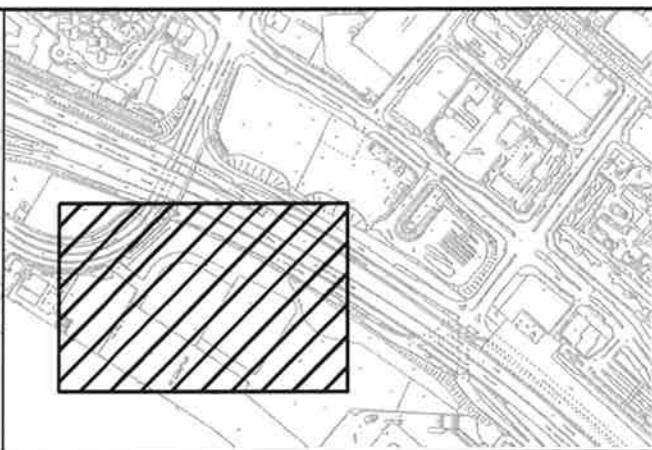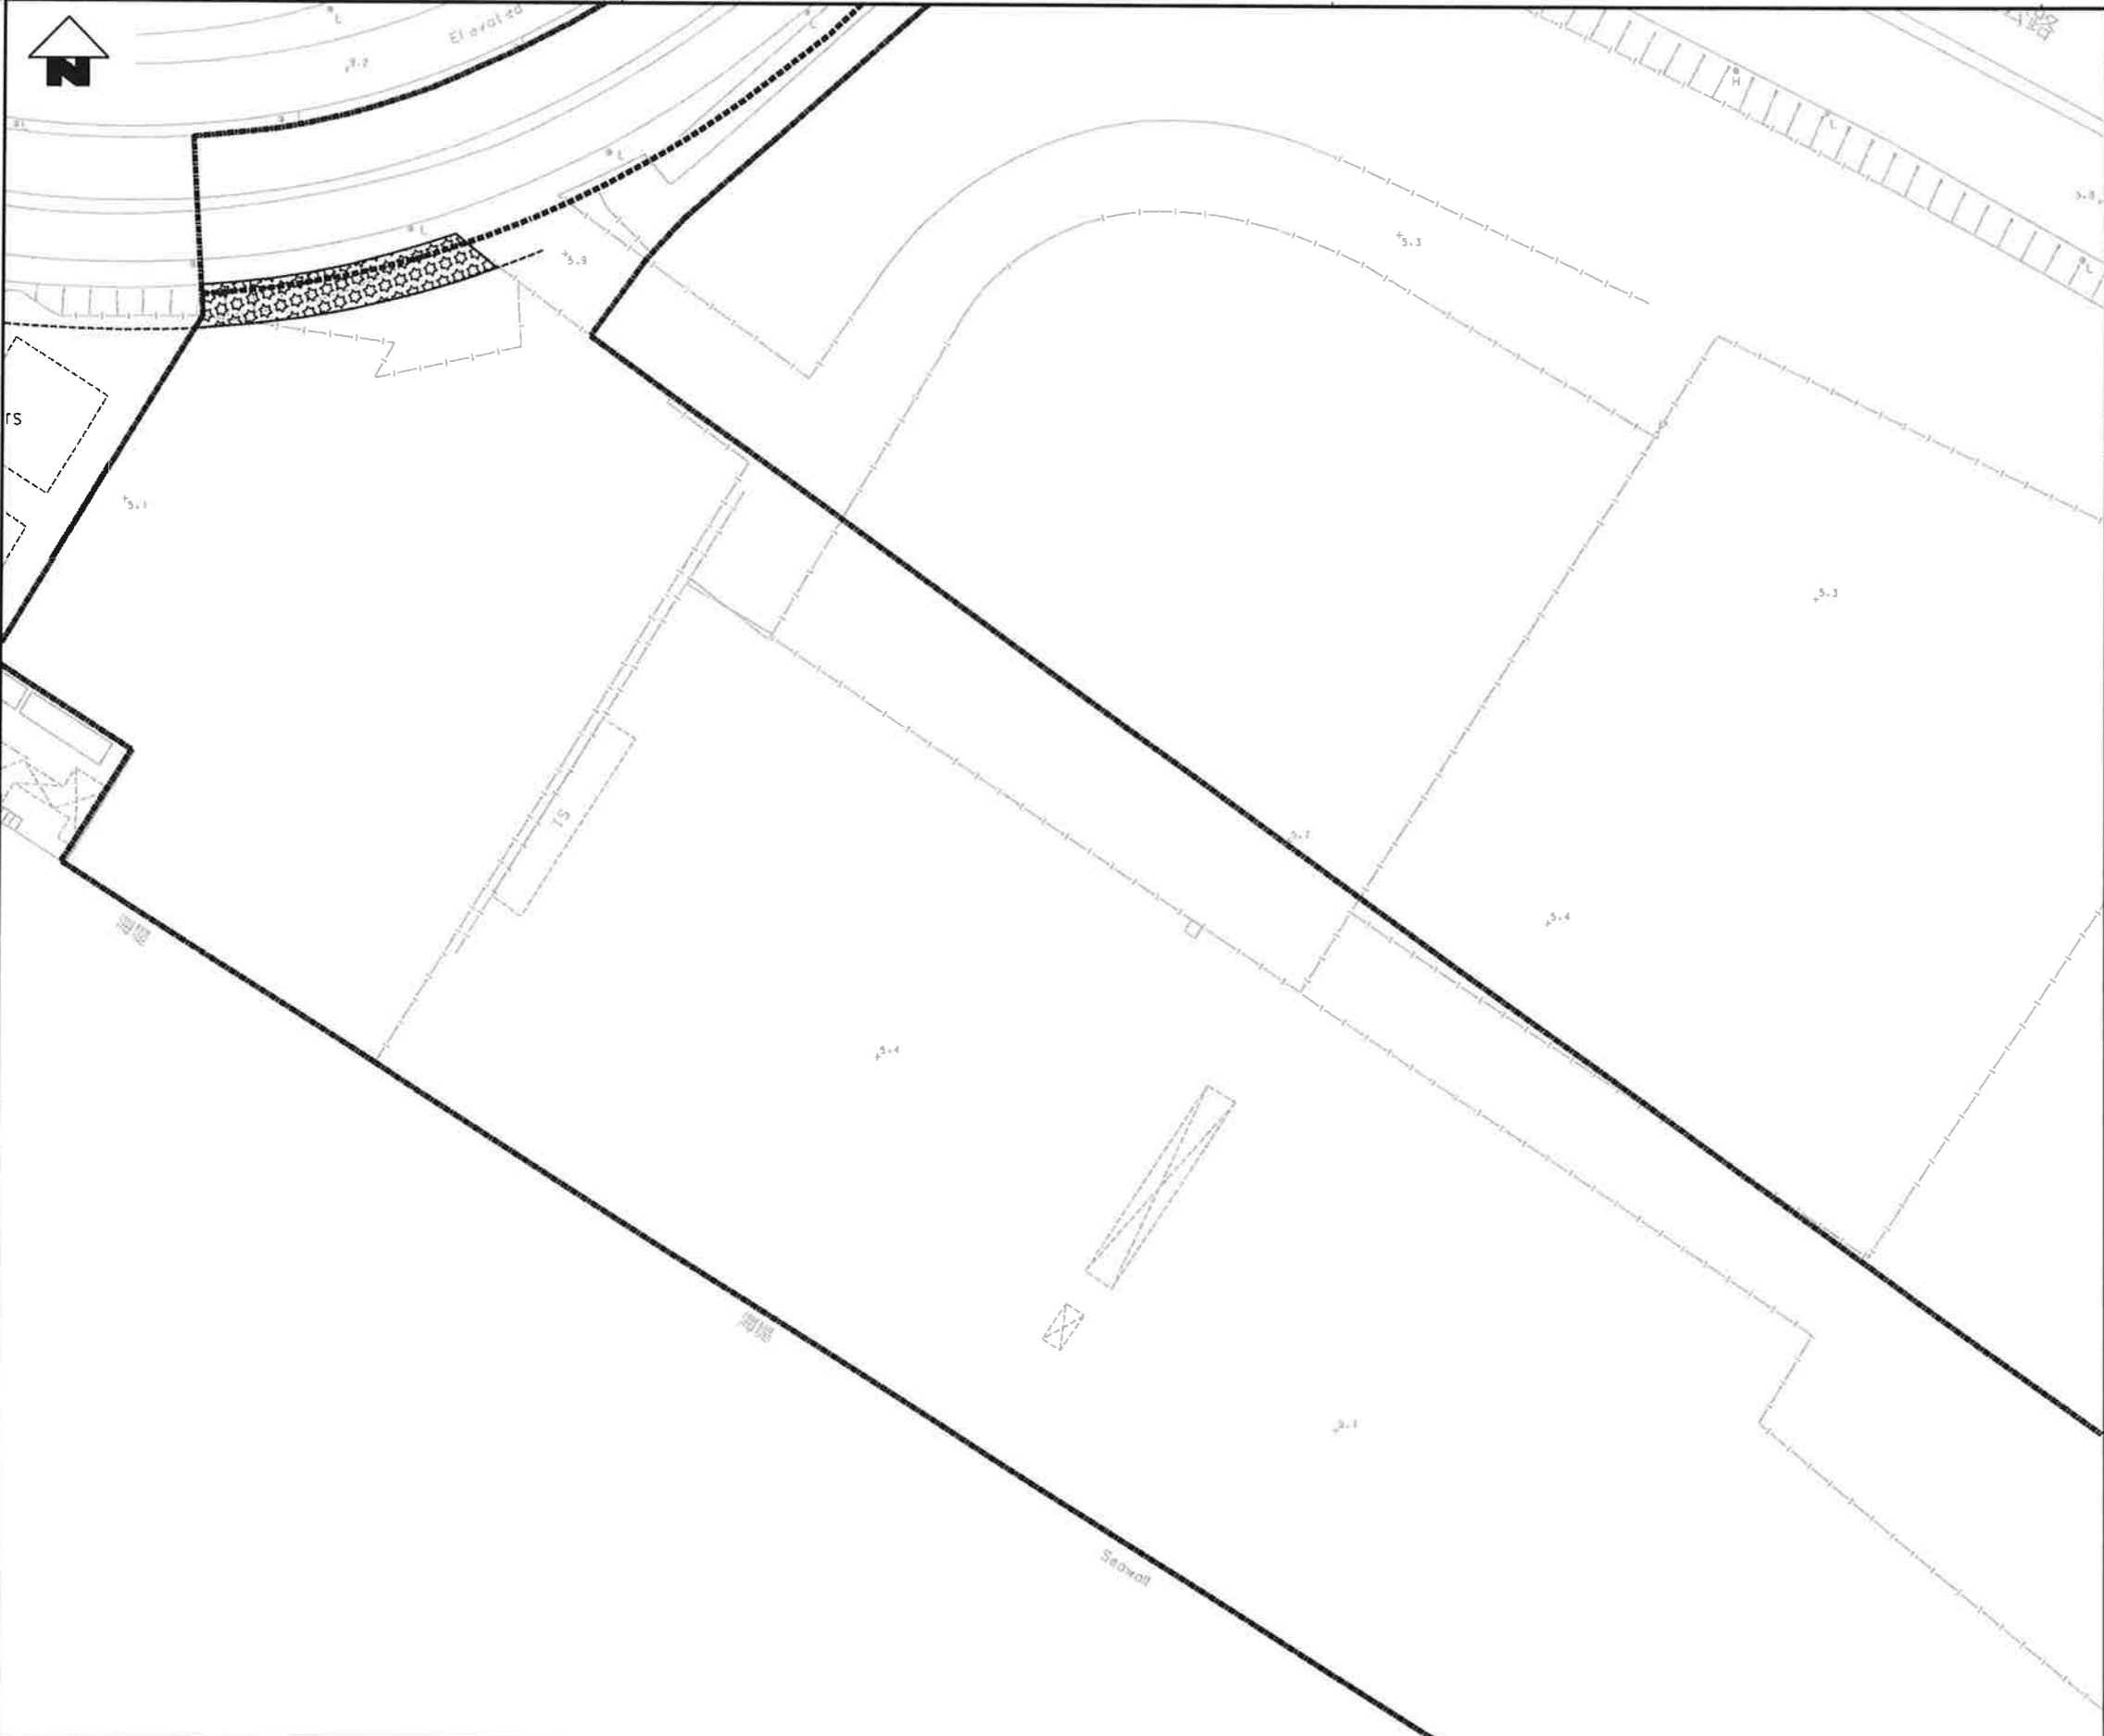

  
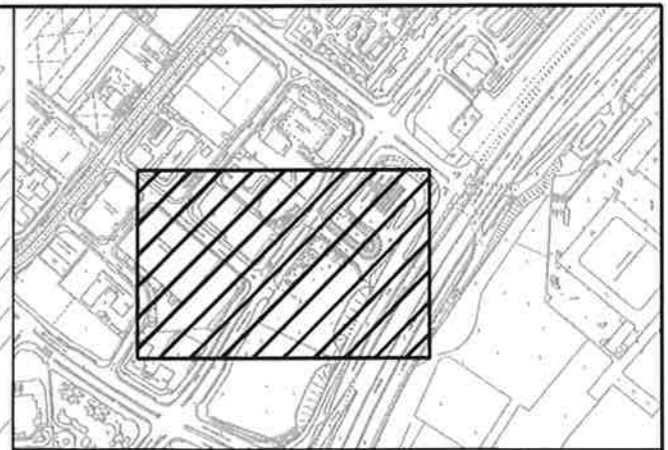
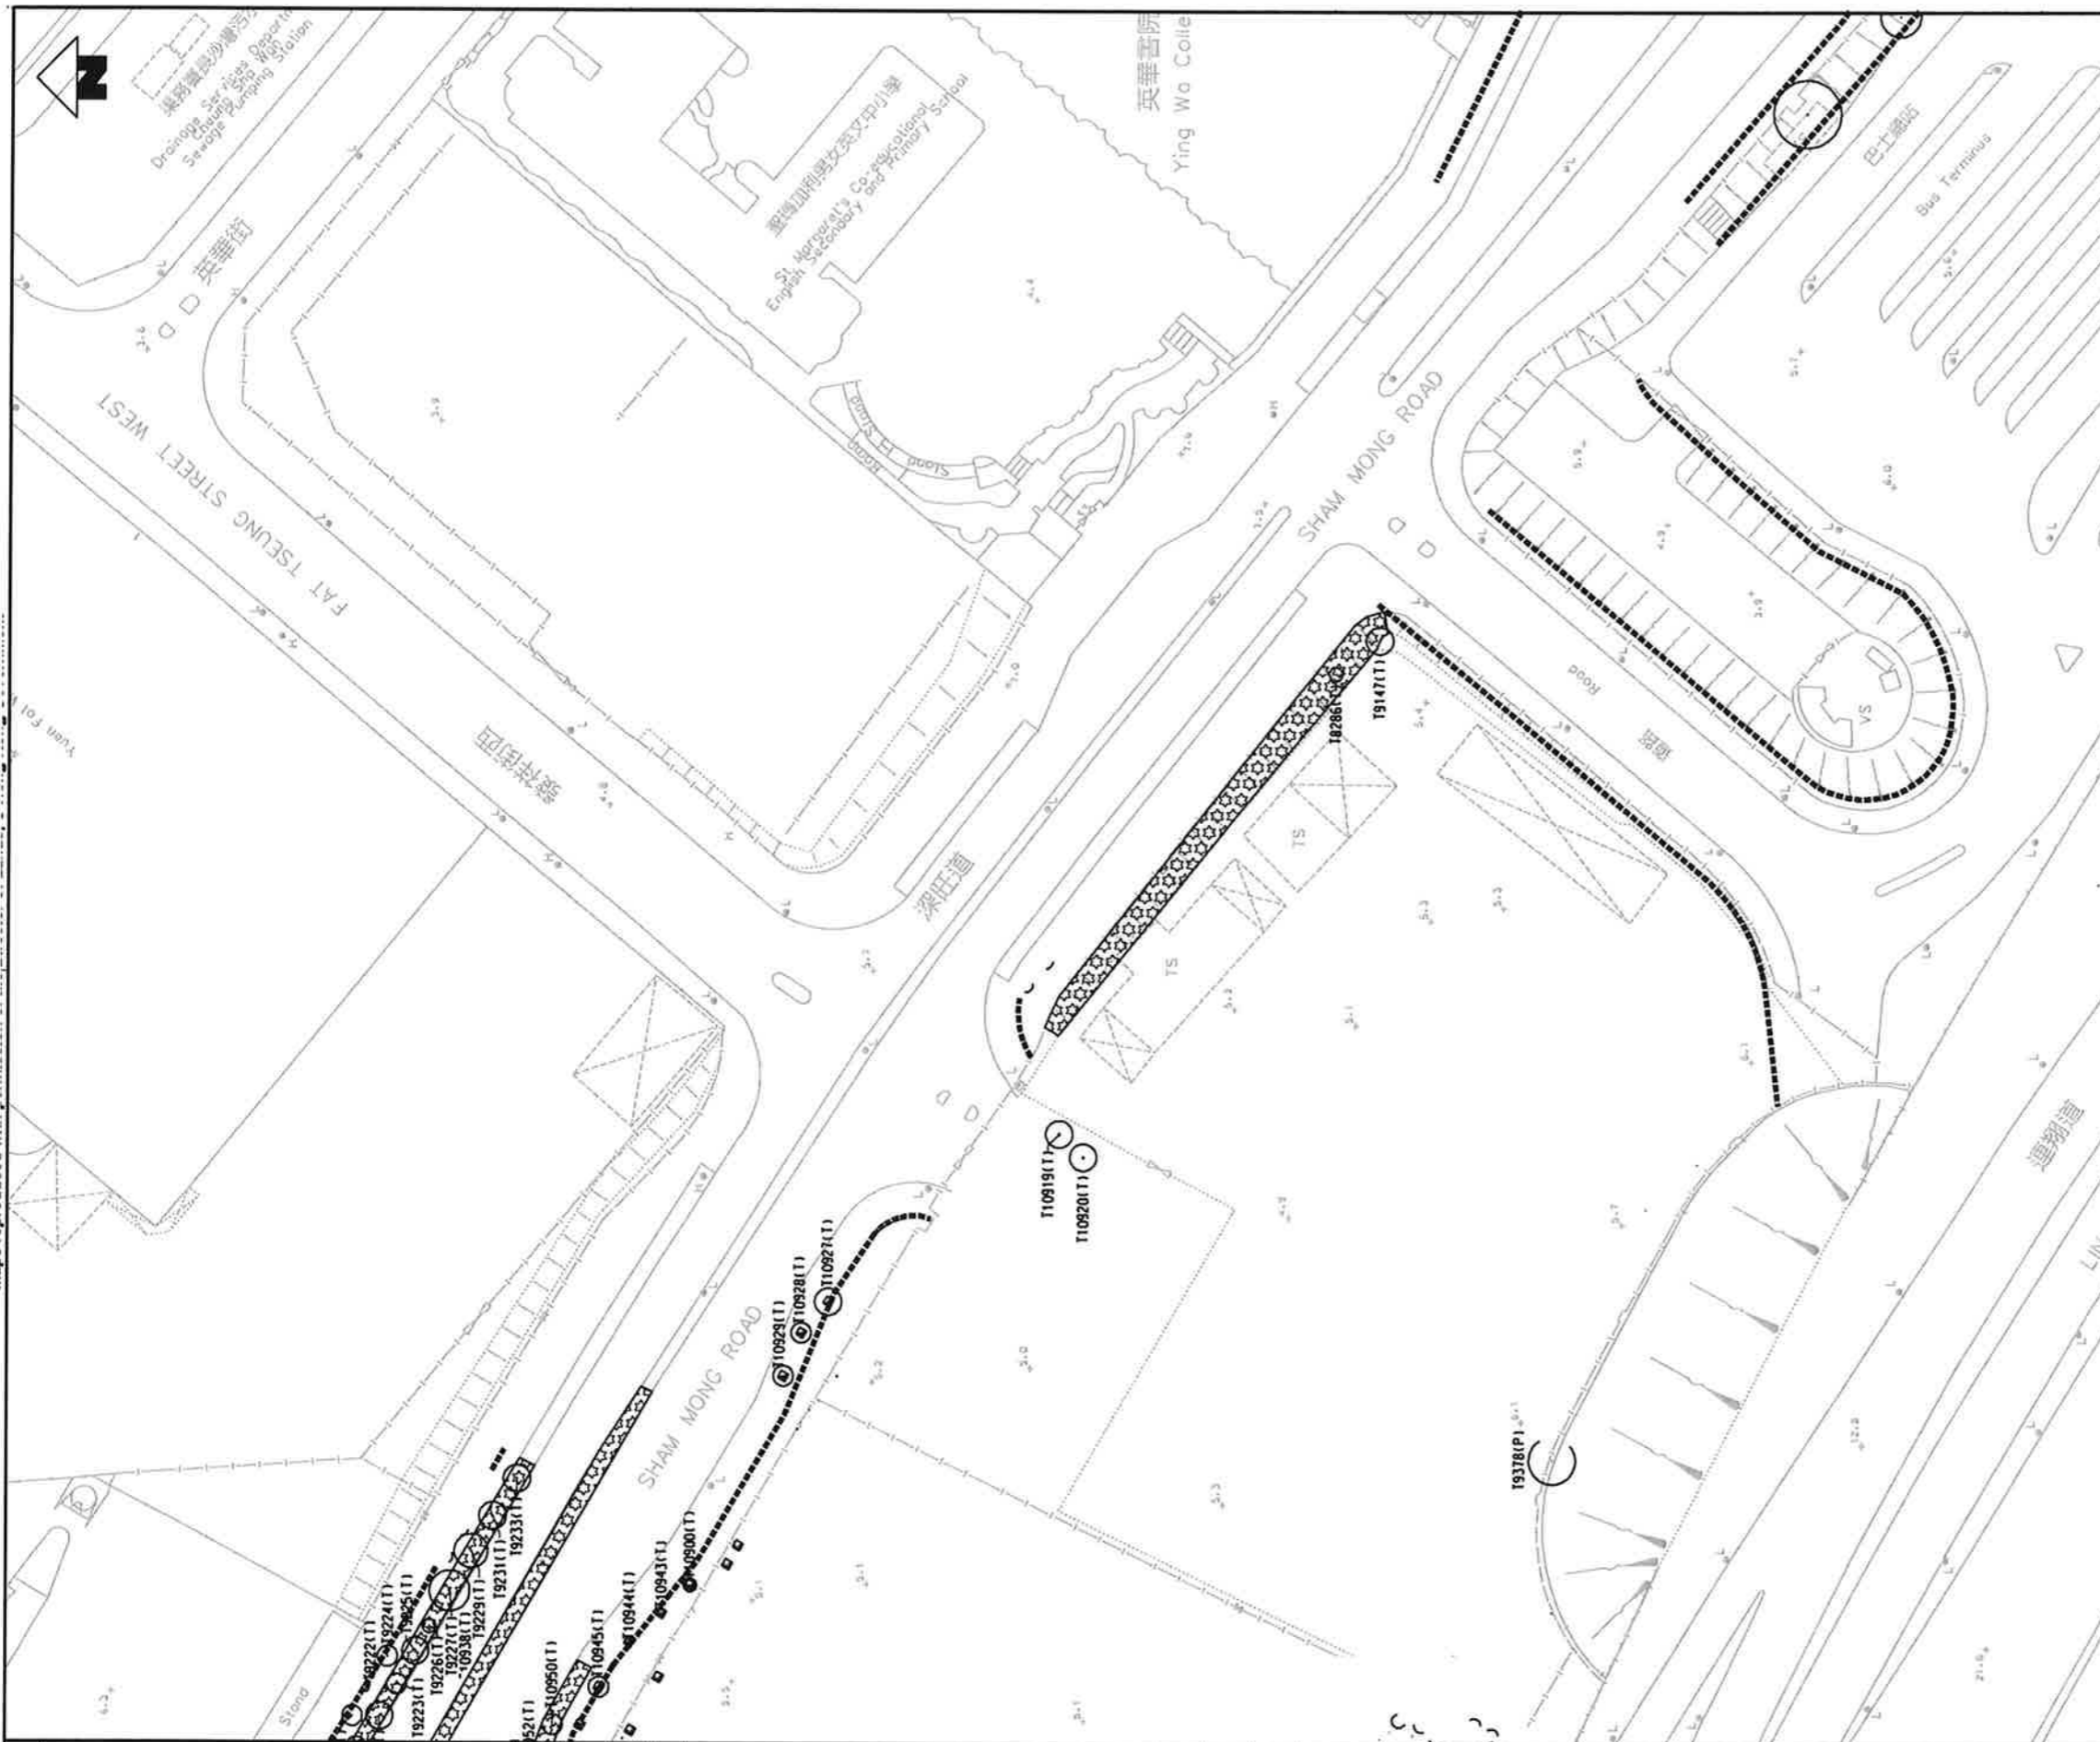
KEY PLAN SCALE 1:15000

LEGEND


 300mm DEPTH PLANTING SOIL MIX
 ABOVE MIN. 900mm DEPTH SUB SOIL
 (AREA = 271sqm)




								DRAWN SK DESIGNED AC CHECKED KH APPROVED TM DATE 30/NOV/09 <small>IF NOT SCALE DRAWINGS - ALL DIMENSIONS SHALL BE READ OFF OF SITE. © THE CORPORATION LIMITED 2009. COPYRIGHT IN THE DESIGN OF THIS DRAWING / DOCUMENT IS OWNED BY THE MTR CORPORATION LIMITED OF HONG KONG. NO REPRODUCTION OF THE DRAWING / DOCUMENT OR ANY PART BY WHATEVER MEANS IS PERMITTED WITHOUT THE PRIOR WRITTEN CONSENT OF THE MTR CORPORATION LIMITED.</small>		 EXPRESS RAIL LINK ORIGINATOR ATKINS Supported by Arup, TFP, Farrells, DLS, Kenneth Ng CADD REF. 820-T-380-ATK-A58-867A.dgn		TITLE CONTRACT 820 MEI LAI ROAD TO HOI TING ROAD TUNNELS SHAM SHUI PO DISTRICT SOILING PLAN (SHEET 4 OF 9)	
REV	DESCRIPTION	BY	DATE	APPROVED	REV	DESCRIPTION	BY	DATE	APPROVED	SCALE	DRAWING NO.	REV.	
	A TENDER ADDENDUM NO.2	AC	30/NOV/09	TM						1 : 500 (A1)	820/T/380/ATK/A58/867	A	




KEY PLAN SCALE 1:15000

 LEGEND




 300mm DEPTH PLANTING SOIL MIX ABOVE WITH 900mm DEPTH SUB SOIL (AREA = 780sqm)




<table border="1"> <tr><td>DRAWN</td><td>SK</td></tr> <tr><td>DESIGNED</td><td>AC</td></tr> <tr><td>CHECKED</td><td>KN</td></tr> <tr><td>APPROVED</td><td>TM</td></tr> <tr><td>DATE</td><td>30/NOV/09</td></tr> </table>	DRAWN	SK	DESIGNED	AC	CHECKED	KN	APPROVED	TM	DATE	30/NOV/09	
DRAWN	SK										
DESIGNED	AC										
CHECKED	KN										
APPROVED	TM										
DATE	30/NOV/09										
<table border="1"> <tr><td>BY</td><td>DATE</td><td>APPROVED</td></tr> <tr><td>AC</td><td>30/NOV/09</td><td>TM</td></tr> </table>	BY	DATE	APPROVED	AC	30/NOV/09	TM	<p>EXPRESS RAIL LINK</p> <p>ATKINS Supported by Arup, TFP Farrells, DLS Kenneth Ng</p>				
BY	DATE	APPROVED									
AC	30/NOV/09	TM									
<table border="1"> <tr><td>REV</td><td>DESCRIPTION</td><td>BY</td><td>DATE</td><td>APPROVED</td></tr> <tr><td>A</td><td>TENDER ADDENDUM NO.2</td><td>AC</td><td>30/NOV/09</td><td>TM</td></tr> </table>	REV	DESCRIPTION	BY	DATE	APPROVED	A	TENDER ADDENDUM NO.2	AC	30/NOV/09	TM	<p>ORIGINATOR</p> <p>CAOD REF. 820_T_380_ATK_A58_868A.dgn</p>
REV	DESCRIPTION	BY	DATE	APPROVED							
A	TENDER ADDENDUM NO.2	AC	30/NOV/09	TM							

<p>TITLE</p> <p>CONTRACT 820</p> <p>MEI LAI ROAD TO HOI TING ROAD TUNNELS</p> <p>SHAM SHUI PO DISTRICT</p> <p>SOILING PLAN</p> <p>(SHEET 5 OF 9)</p>	
<p>SCALE</p> <p>1 : 400 (A1)</p>	<p>DRAWING NO.</p> <p>820/T/380/ATK/A58/868</p>
<p>REV.</p> <p>A</p>	

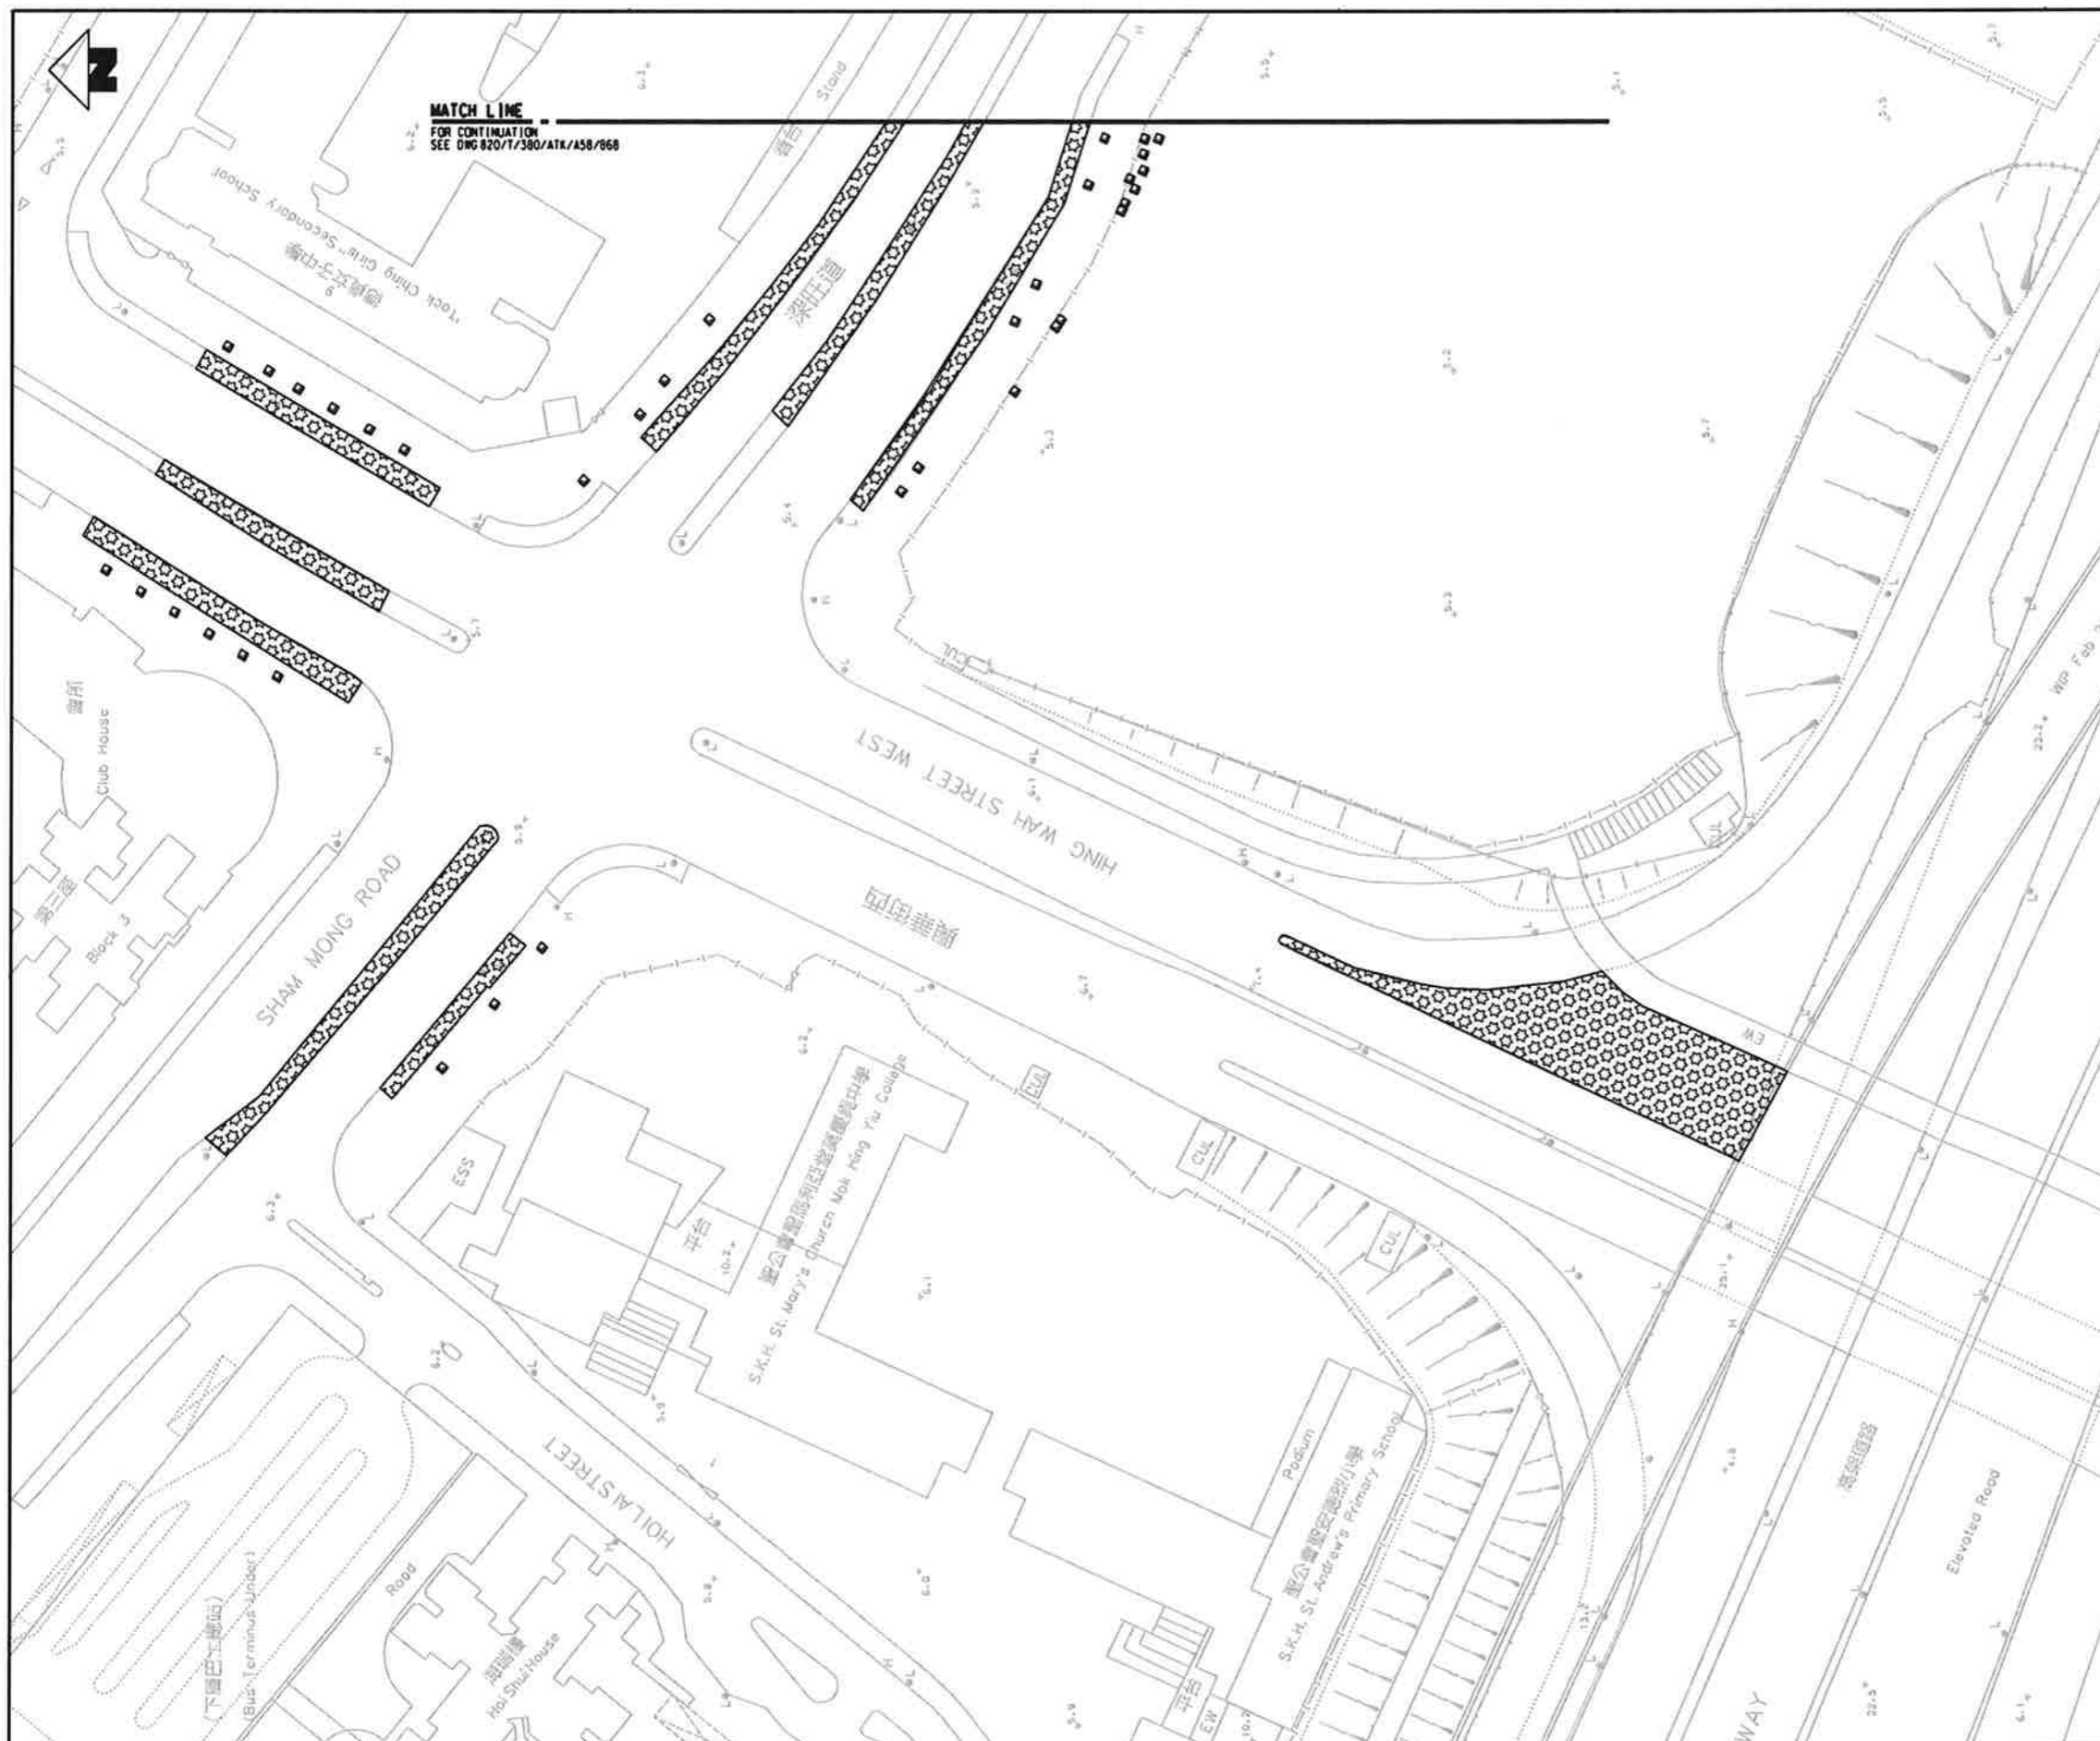



MATCH LINE
FOR CONTINUATION
SEE DWG 820/T/380/ATK/A58/868

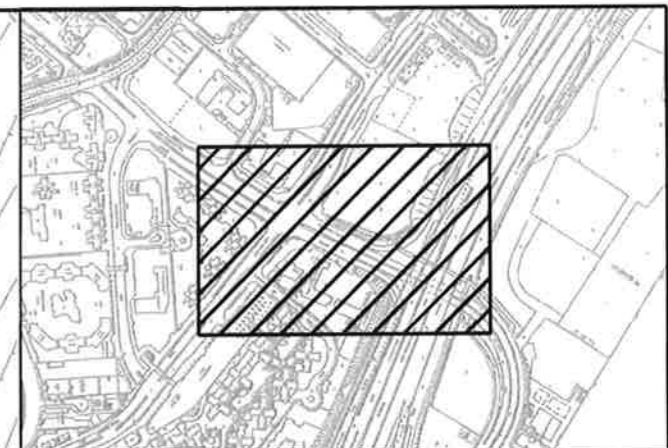

KEY PLAN SCALE 1:5000

 LEGEND

  300mm DEPTH PLANTING SOIL MIX
ABOVE MIN. 900mm DEPTH SUB SOIL
(AREA = 2340sqm)



REV	DESCRIPTION	BY	DATE	APPROVED	REV	DESCRIPTION	BY	DATE	APPROVED
					A	TENDER ADDENDUM NO.2	AC	30NOV09	TM

DRAWN	SK
DESIGNED	AC
CHECKED	KN
APPROVED	TM
DATE	30/NOV/09

MTR

EXPRESS RAIL LINK

ORIGINATOR

ATKINS Supported by Arup, TFP Farrells, DLS Kenneth Ng

CAAD REF. 820_T_380_ATK_A58_869A.dgn

TITLE



CONTRACT 820
MEI LAI ROAD TO HOI TING ROAD TUNNELS
SHAM SHUI PO DISTRICT
LANDSCAPE PLAN
(SHEET 6 OF 9)

SCALE 1 : 500 (A1)

DRAWING NO. 820/T/380/ATK/A58/869

REV. A


Maps reproduced with permission of the Director of Lands, © Hong Kong Government

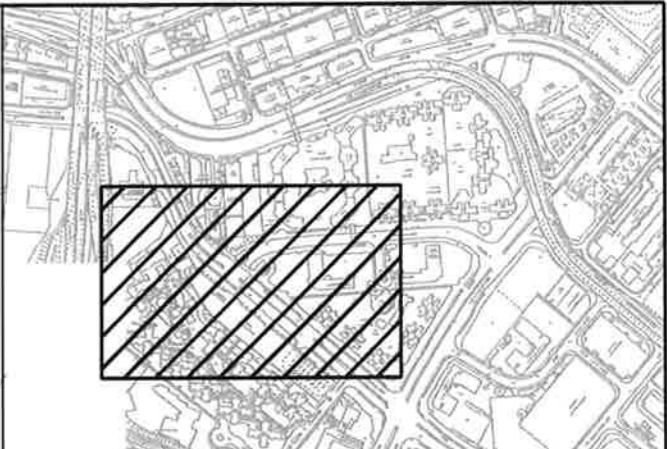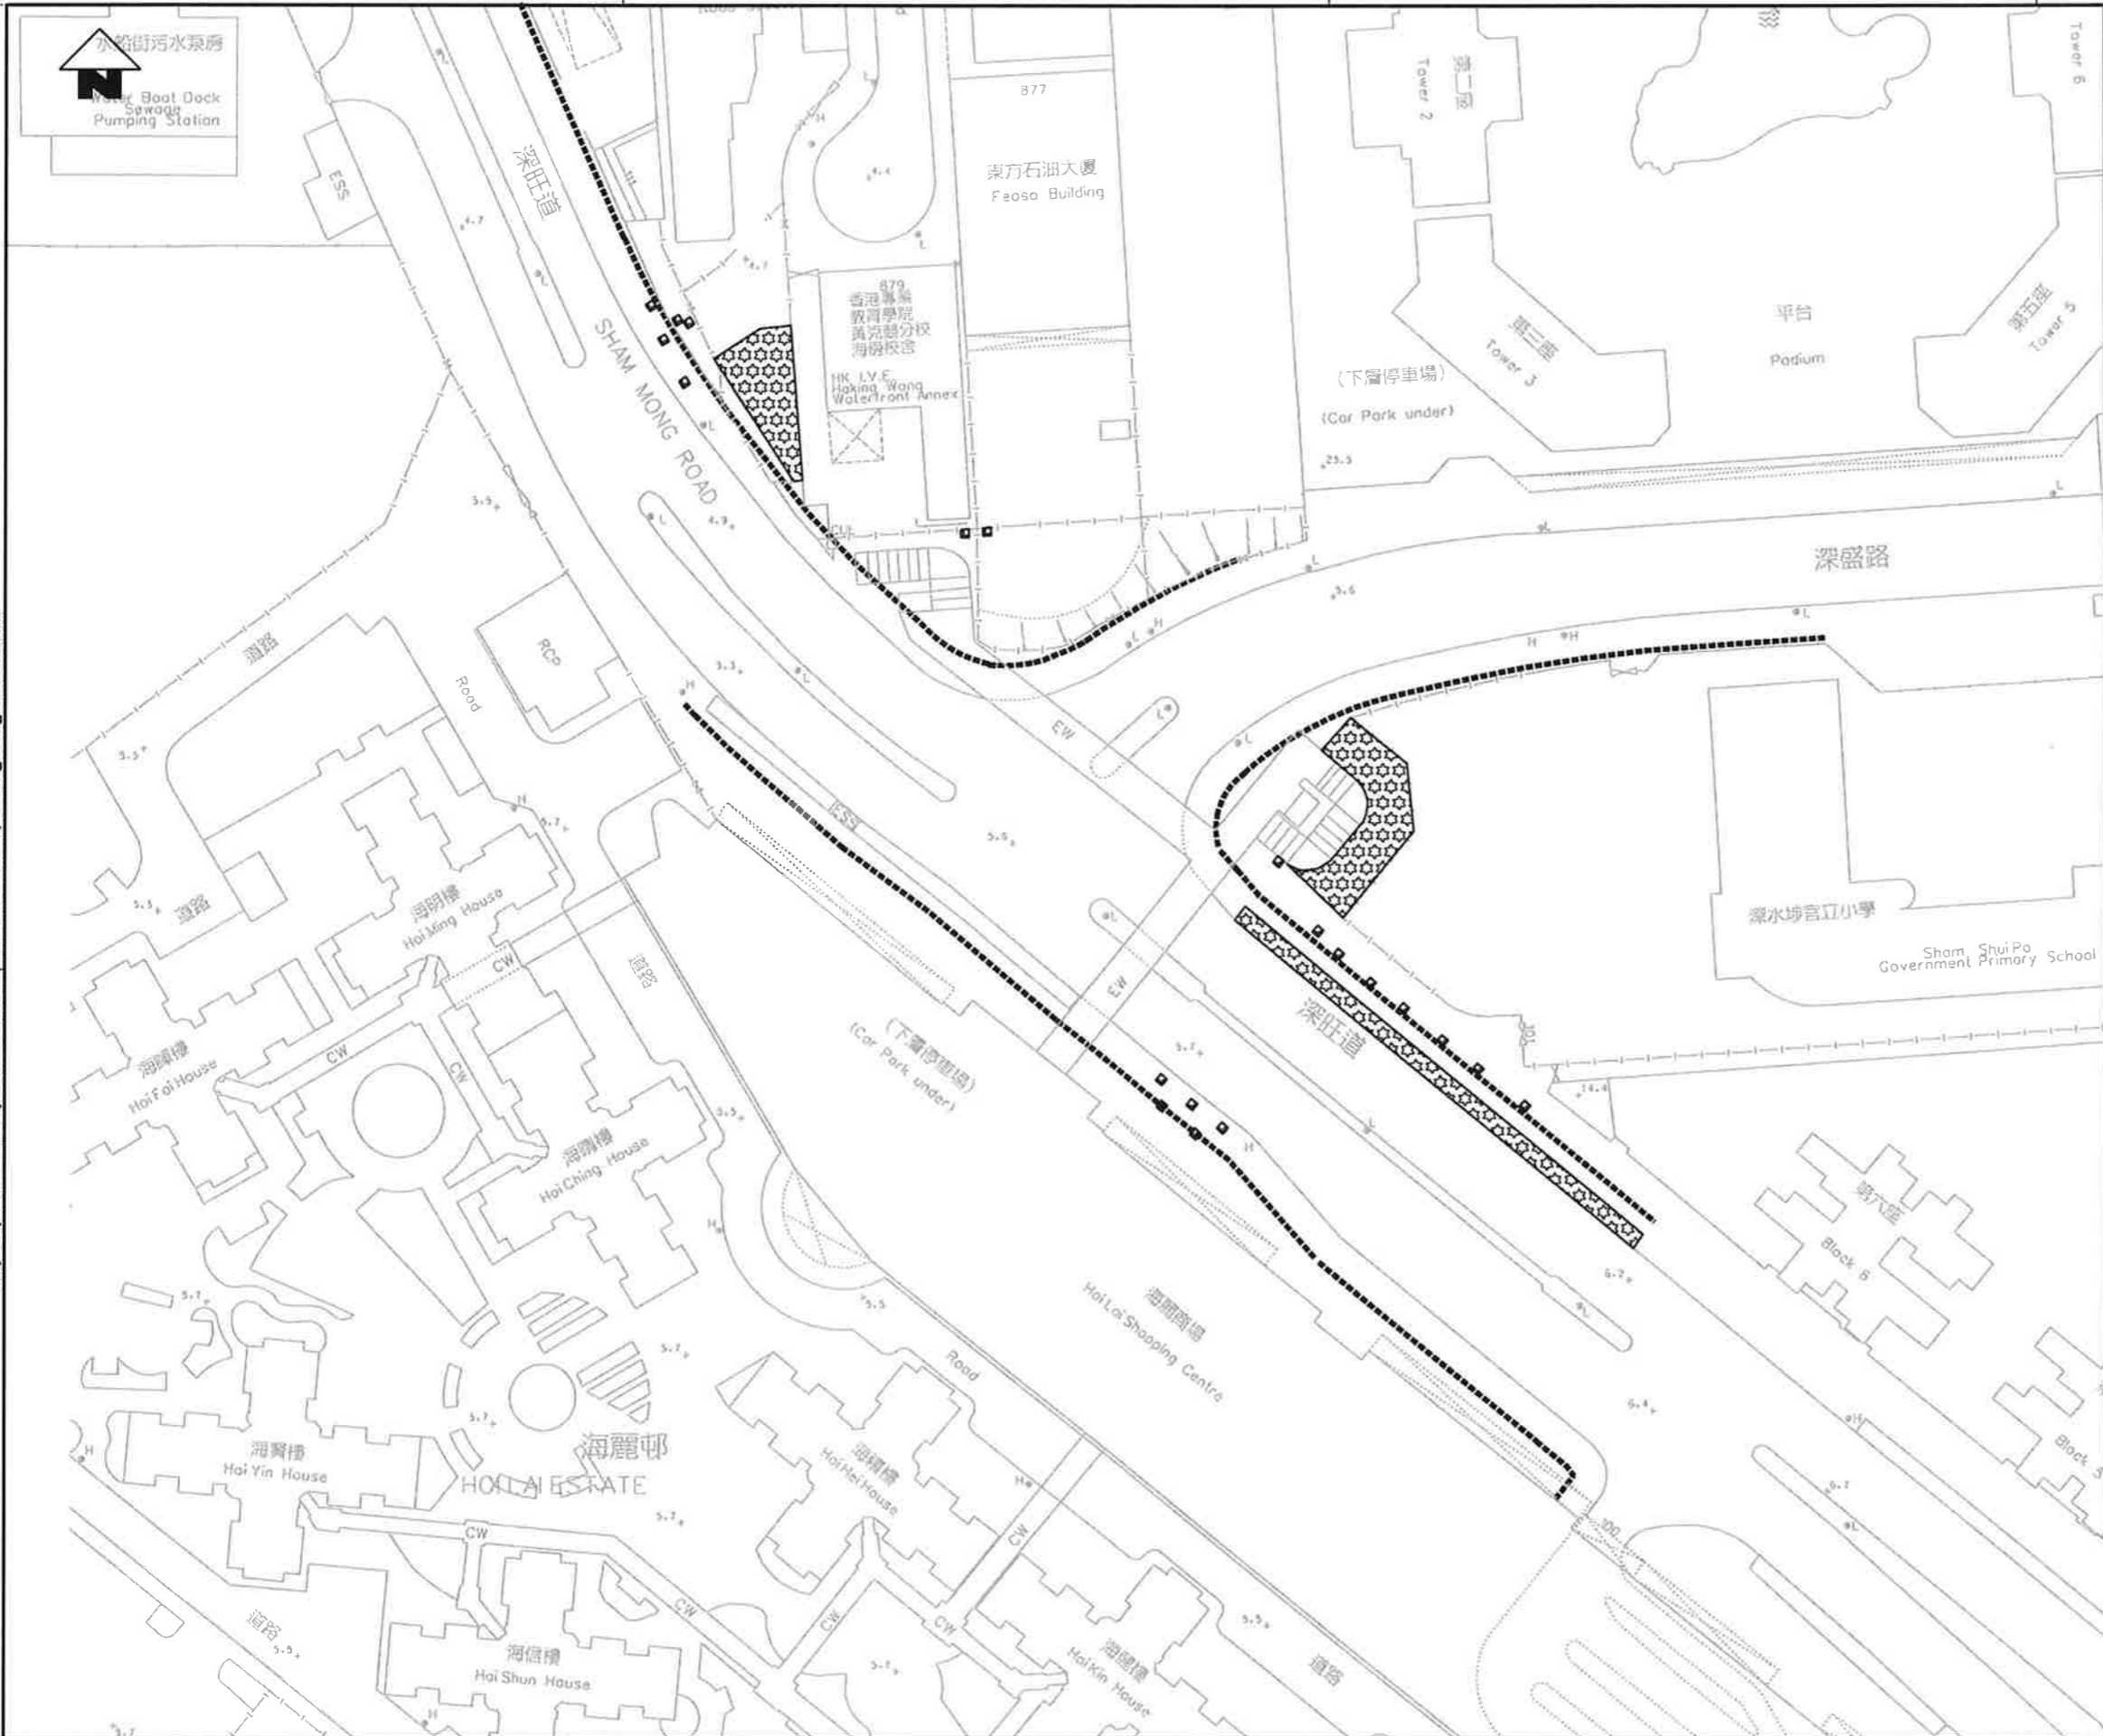

KEY PLAN SCALE 1:5000

LEGEND

 300mm DEPTH PLANTING SOIL MIX
ABOVE MIN. 900mm DEPTH SUB SOIL
(AREA = 602sqm)



REV	DESCRIPTION	BY	DATE	APPROVED	REV	DESCRIPTION	BY	DATE	APPROVED
	A TENDER ADDENDUM NO.2								

DRAWN	SK
DESIGNED	AC
CHECKED	KN
APPROVED	TM
DATE	13/NOV/09

MTR

EXPRESS RAIL LINK

ORIGINATOR

ATKINS Supported by Arup, TFP, Farrells, DLS, Kenneth Ng


CADD REF. 820_T_380_ATK_A58_870A.dgn

TITLE	CONTRACT 820 MEI LAI ROAD TO HOI TING ROAD TUNNELS SHAM SHUI PO DISTRICT SOILING PLAN (SHEET 7 OF 9)
SCALE	1 : 500 (A1)
DRAWING NO.	820/T/380/ATK/A58/870
REV.	A

Maps reproduced with permission of the Director of Lands, © Hong Kong Government


PRINTED BY: 4158R# 2009/11/17 1/4"=1'@ 05:36:24


MODEL# 4158R#
FILE# 05:36:24

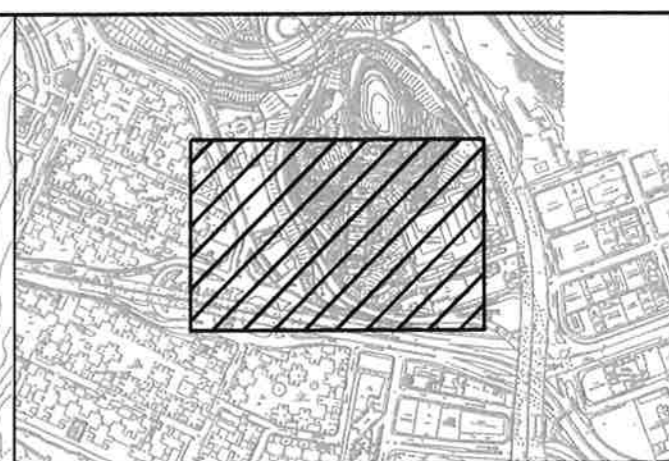

KEY PLAN SCALE 1:5000

 LEGEND

  300mm DEPTH PLANTING SOIL MIX ABOVE MIN. 900mm DEPTH SUB SOIL (AREA = 205sqm)





DRAWN SK		DESIGNED AC		CHECKED KN		APPROVED TM		DATE 30/NOV/09		ORIGINATOR	
BY		DATE		APPROVED		BY		DATE		APPROVED	
A		TENDER ADDENDUM NO. 2		AC		JONV09		TM		CADD REF. 820-T-380-ATK-A58-871A.dgn	

MTR
EXPRESS RAIL LINK


ATKINS
Supported by Arup, TFP, Farrells, DLS, Kenneth Ng


TITLE		CONTRACT 820	
		MEI LAI ROAD TO HOI TING ROAD TUNNELS	
		SHAM SHUI PO DISTRICT	
		SOILING PLAN	
		(SHEET 8 OF 9)	
SCALE	DRAWING NO.	REV.	
1 : 500 (A1)	820/T/380/ATK/A58/871	A	

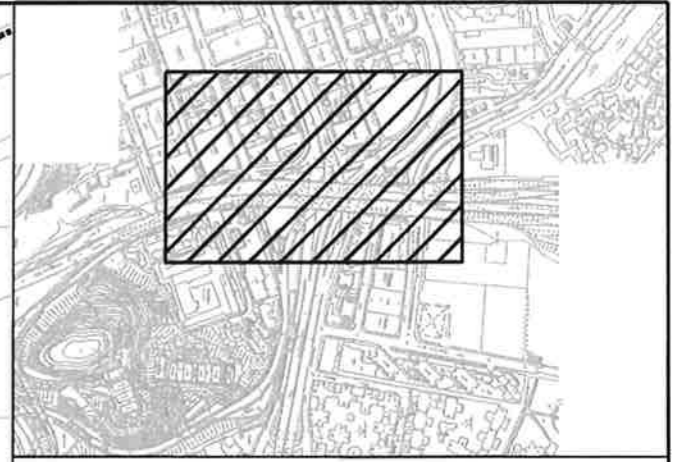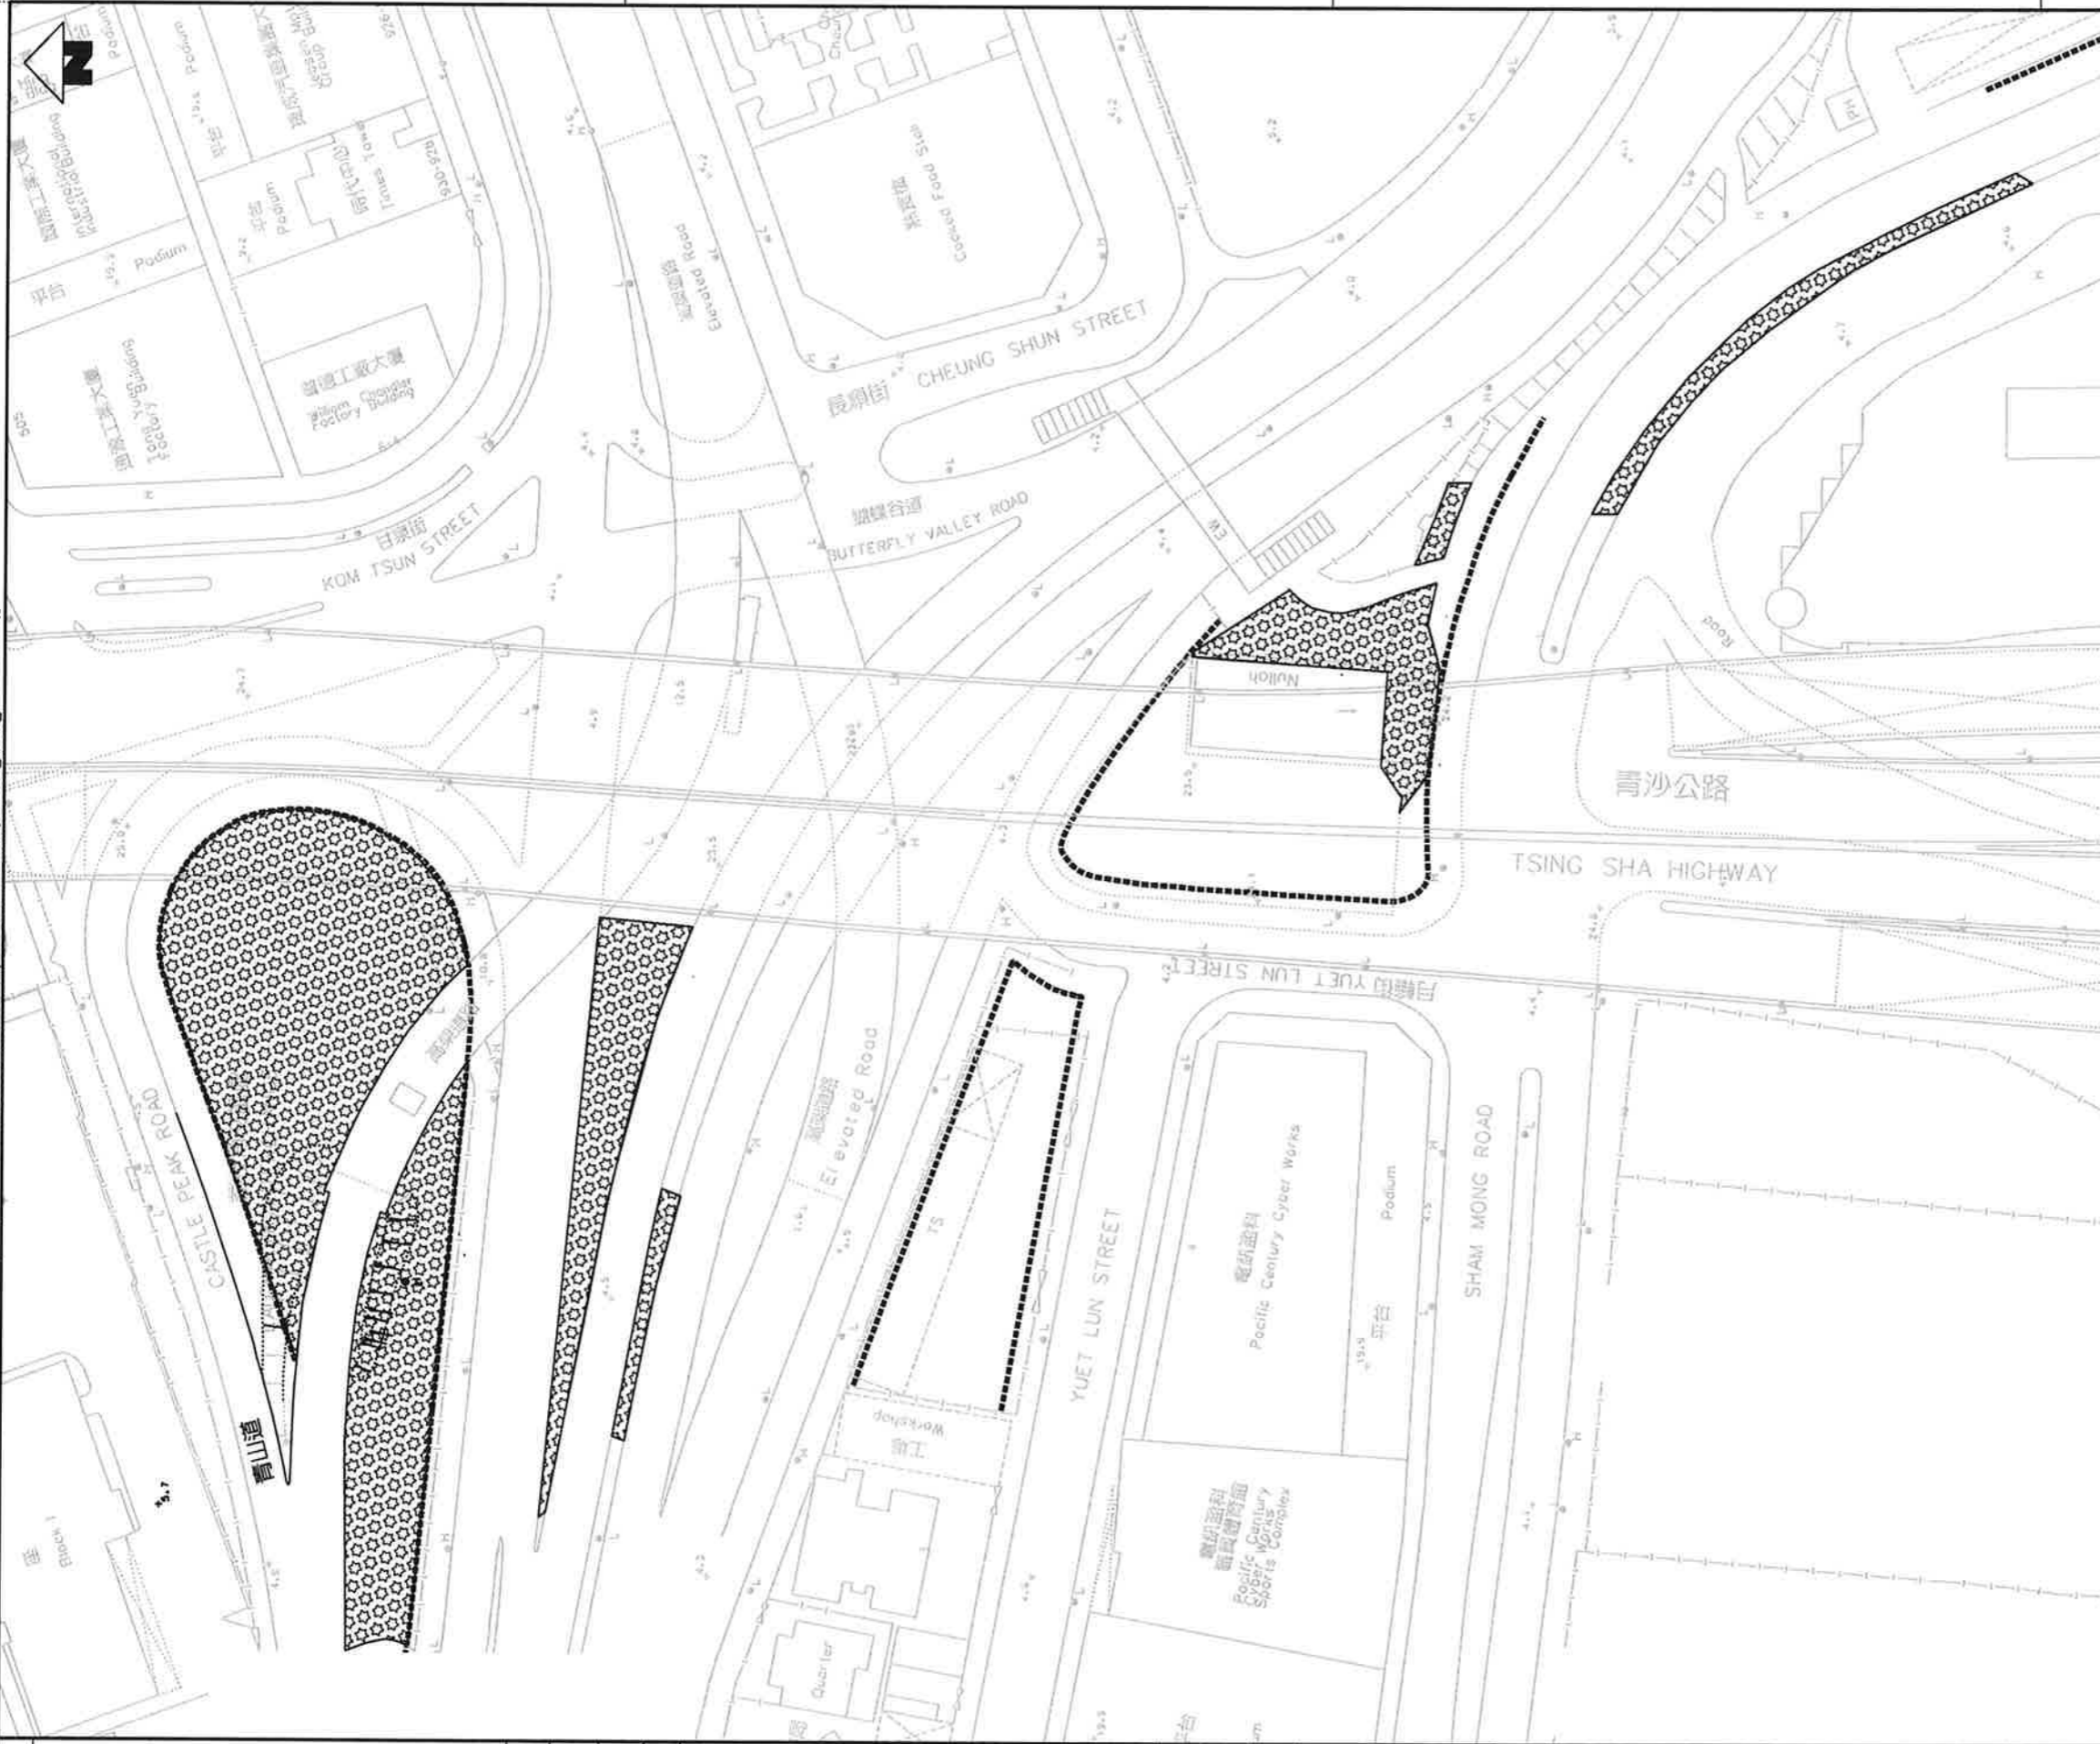

KEY PLAN SCALE 1:15000

LEGEND

  300mm DEPTH PLANTING SOIL MIX ABOVE MIN. 900mm DEPTH SUB SOIL (AREA = 4079sqm)



REV	DESCRIPTION	BY	DATE	APPROVED	REV	DESCRIPTION	BY	DATE	APPROVED
A	TENDER ADDENDUM NO.2	AC	30/NOV/09	TM					

DRAWN	SK
DESIGNED	AC
CHECKED	KN
APPROVED	TM
DATE	30/NOV/09



MTR

EXPRESS RAIL LINK

ORIGINATOR **ATKINS** Supported by Arup, TFP, Farrells, DLS, Kenneth Ng

CAAD REF. 820_T_380_ATK_A58_872A.dgn


TITLE	CONTRACT 820 MEI LAI ROAD TO HOI TING ROAD TUNNELS SHAM SHUI PO DISTRICT SOILING PLAN (SHEET 9 OF 9)		
SCALE	1 : 500 (A1)	DRAWING NO.	820/T/380/ATK/A58/872
REV.			A

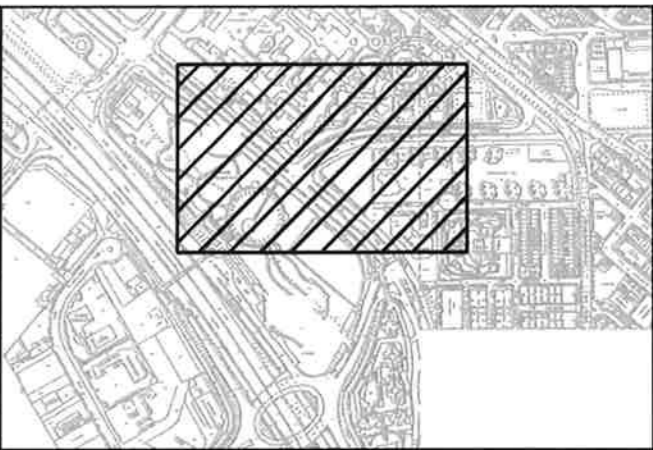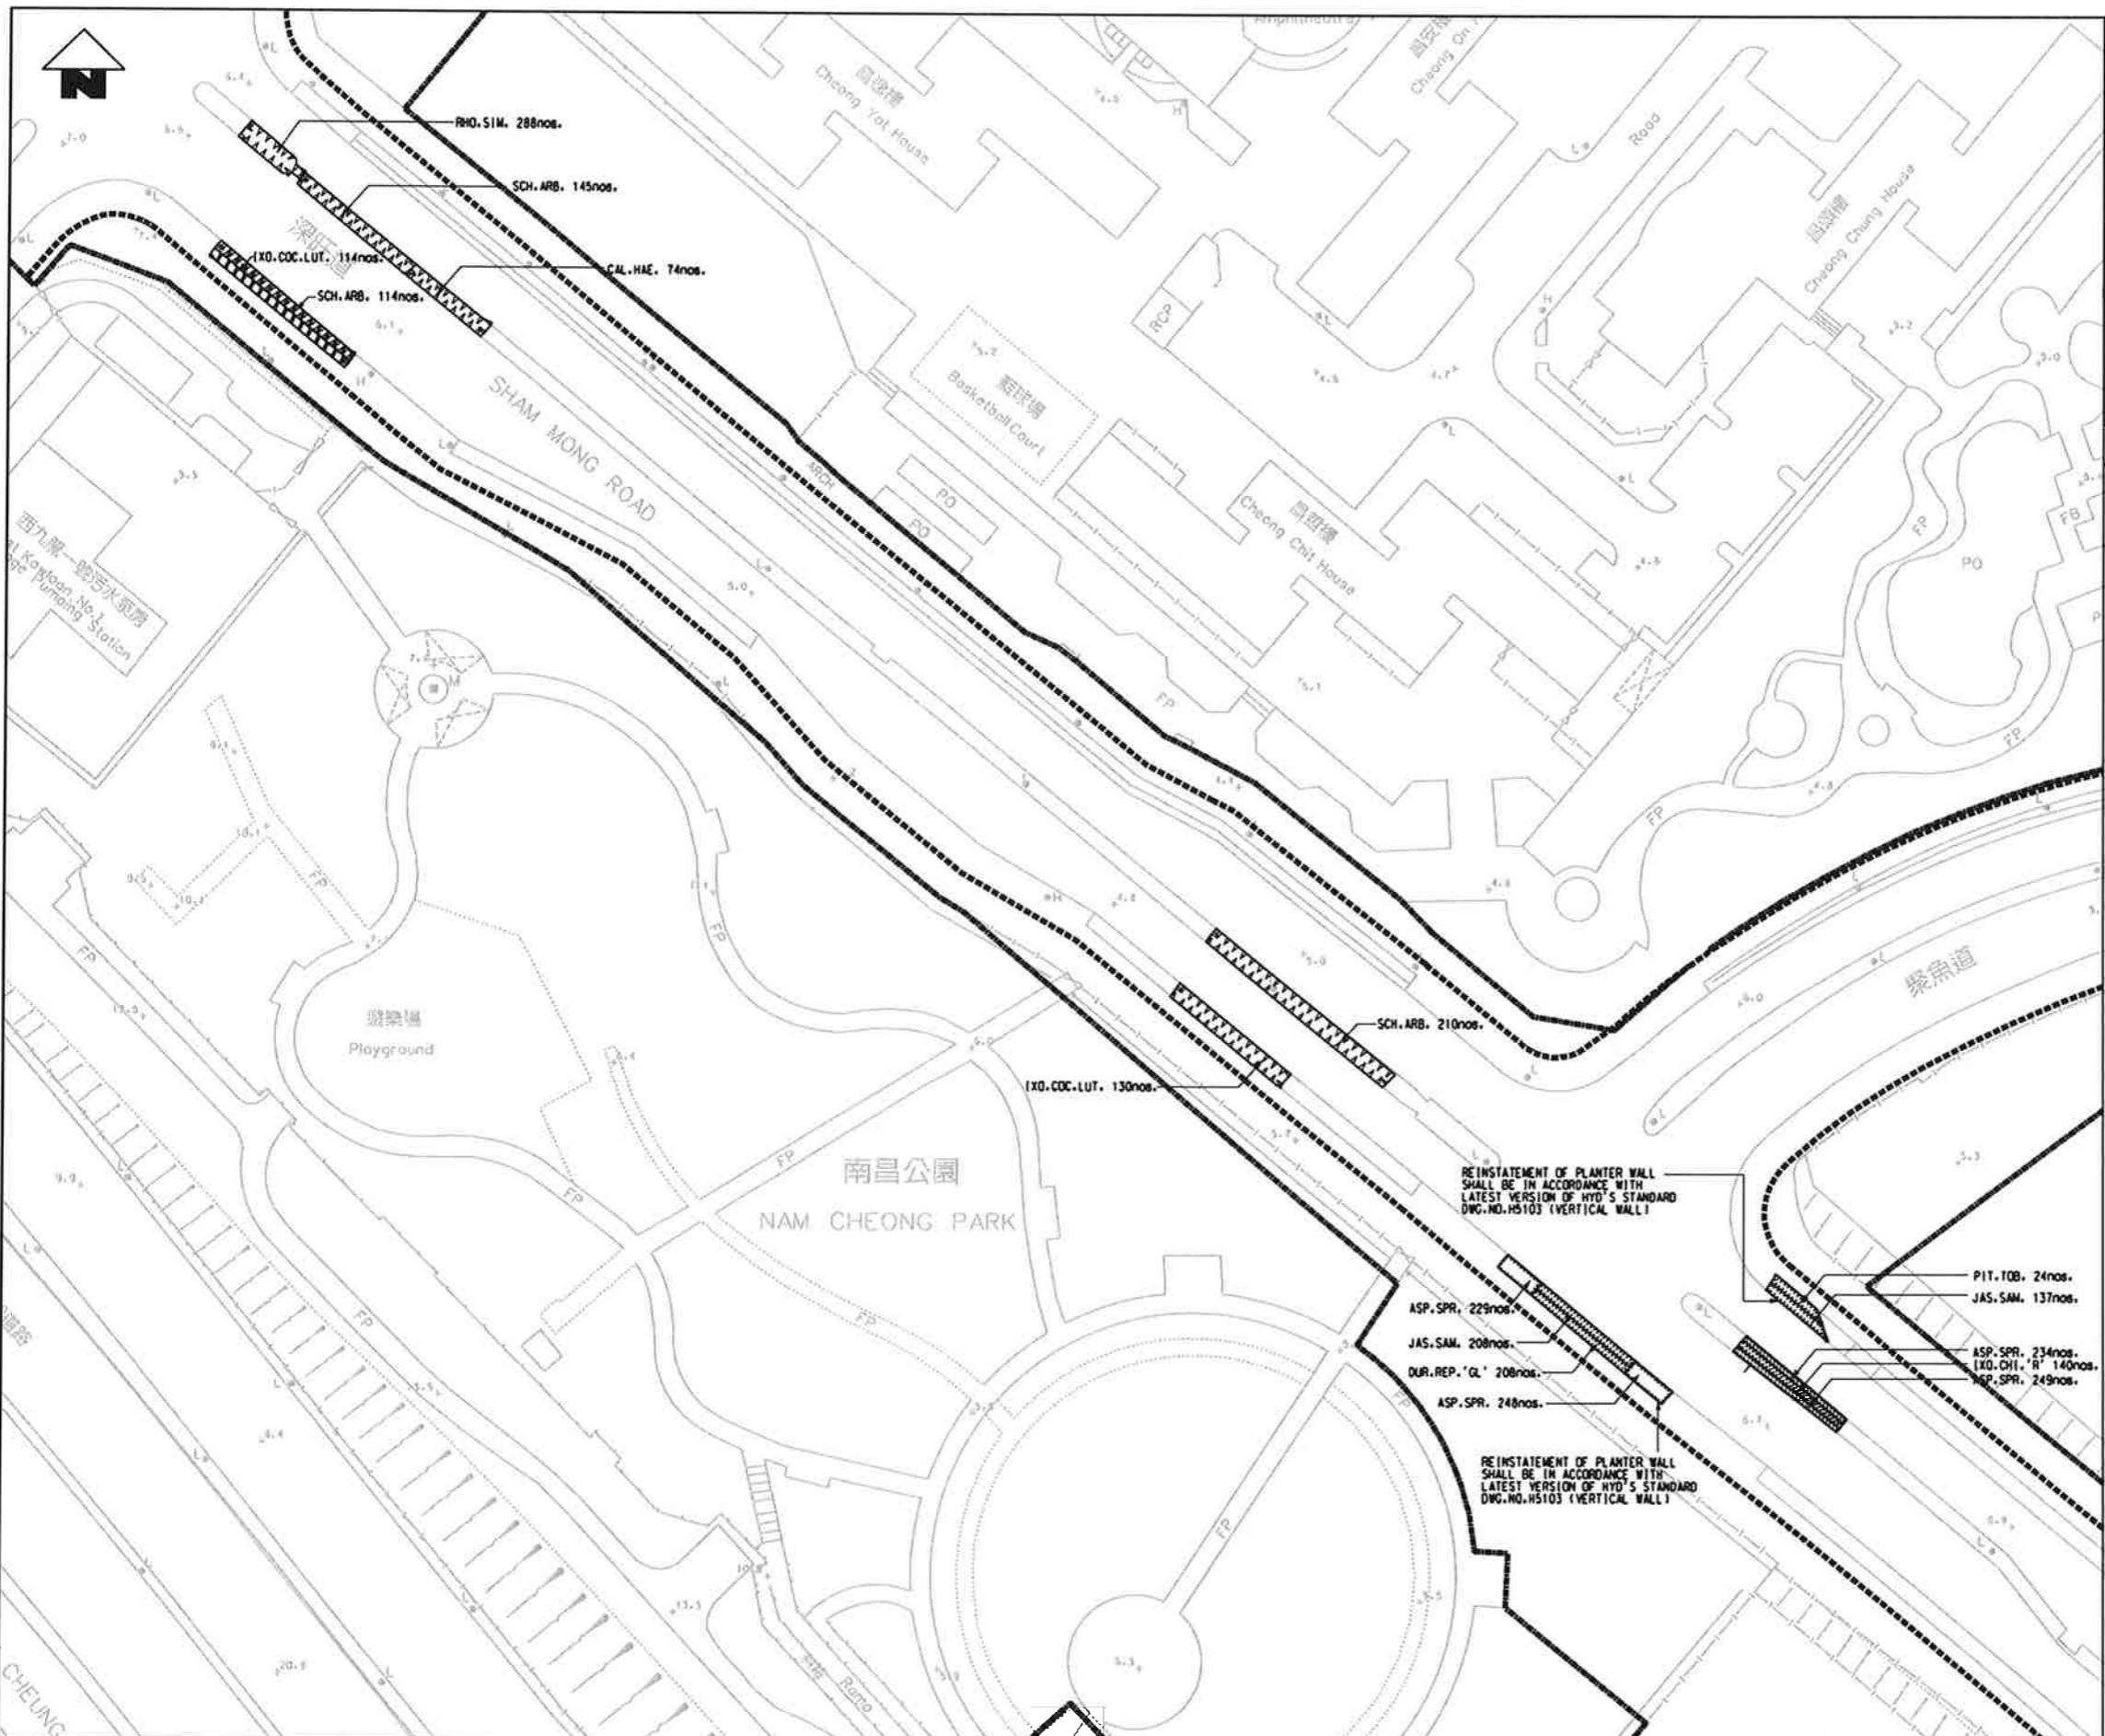

SCALE 1:15000

LEGEND

 - SHRUB
- GROUND COVER



REV	DESCRIPTION	BY	DATE	APPROVED	REV	DESCRIPTION	BY	DATE	APPROVED
					B	TENDER ADDENDUM NO.2	AC	30NOV09	TM

DRAWN	SK
DESIGNED	AC
CHECKED	KN
APPROVED	TM
DATE	30/OCT/09

MTR



EXPRESS RAIL LINK

ORIGINATOR

ATKINS Supported by Arup, TFP Farrells, DLS Kenneth Ng

CAAD REF. 820.T.380.ATK.A58.880A.dgn


TITLE	CONTRACT 820 MEI LAI ROAD TO HOI TING ROAD TUNNELS SHAM SHUI PO DISTRICT PLANTING PLAN (SHEET 1 OF 11)
SCALE	1 : 500 (A1)
DRAWING NO.	820/T/380/ATK/A58/880
REV.	A

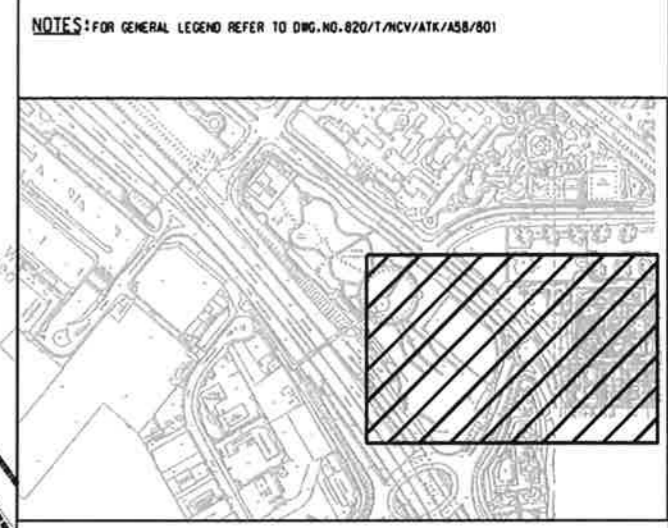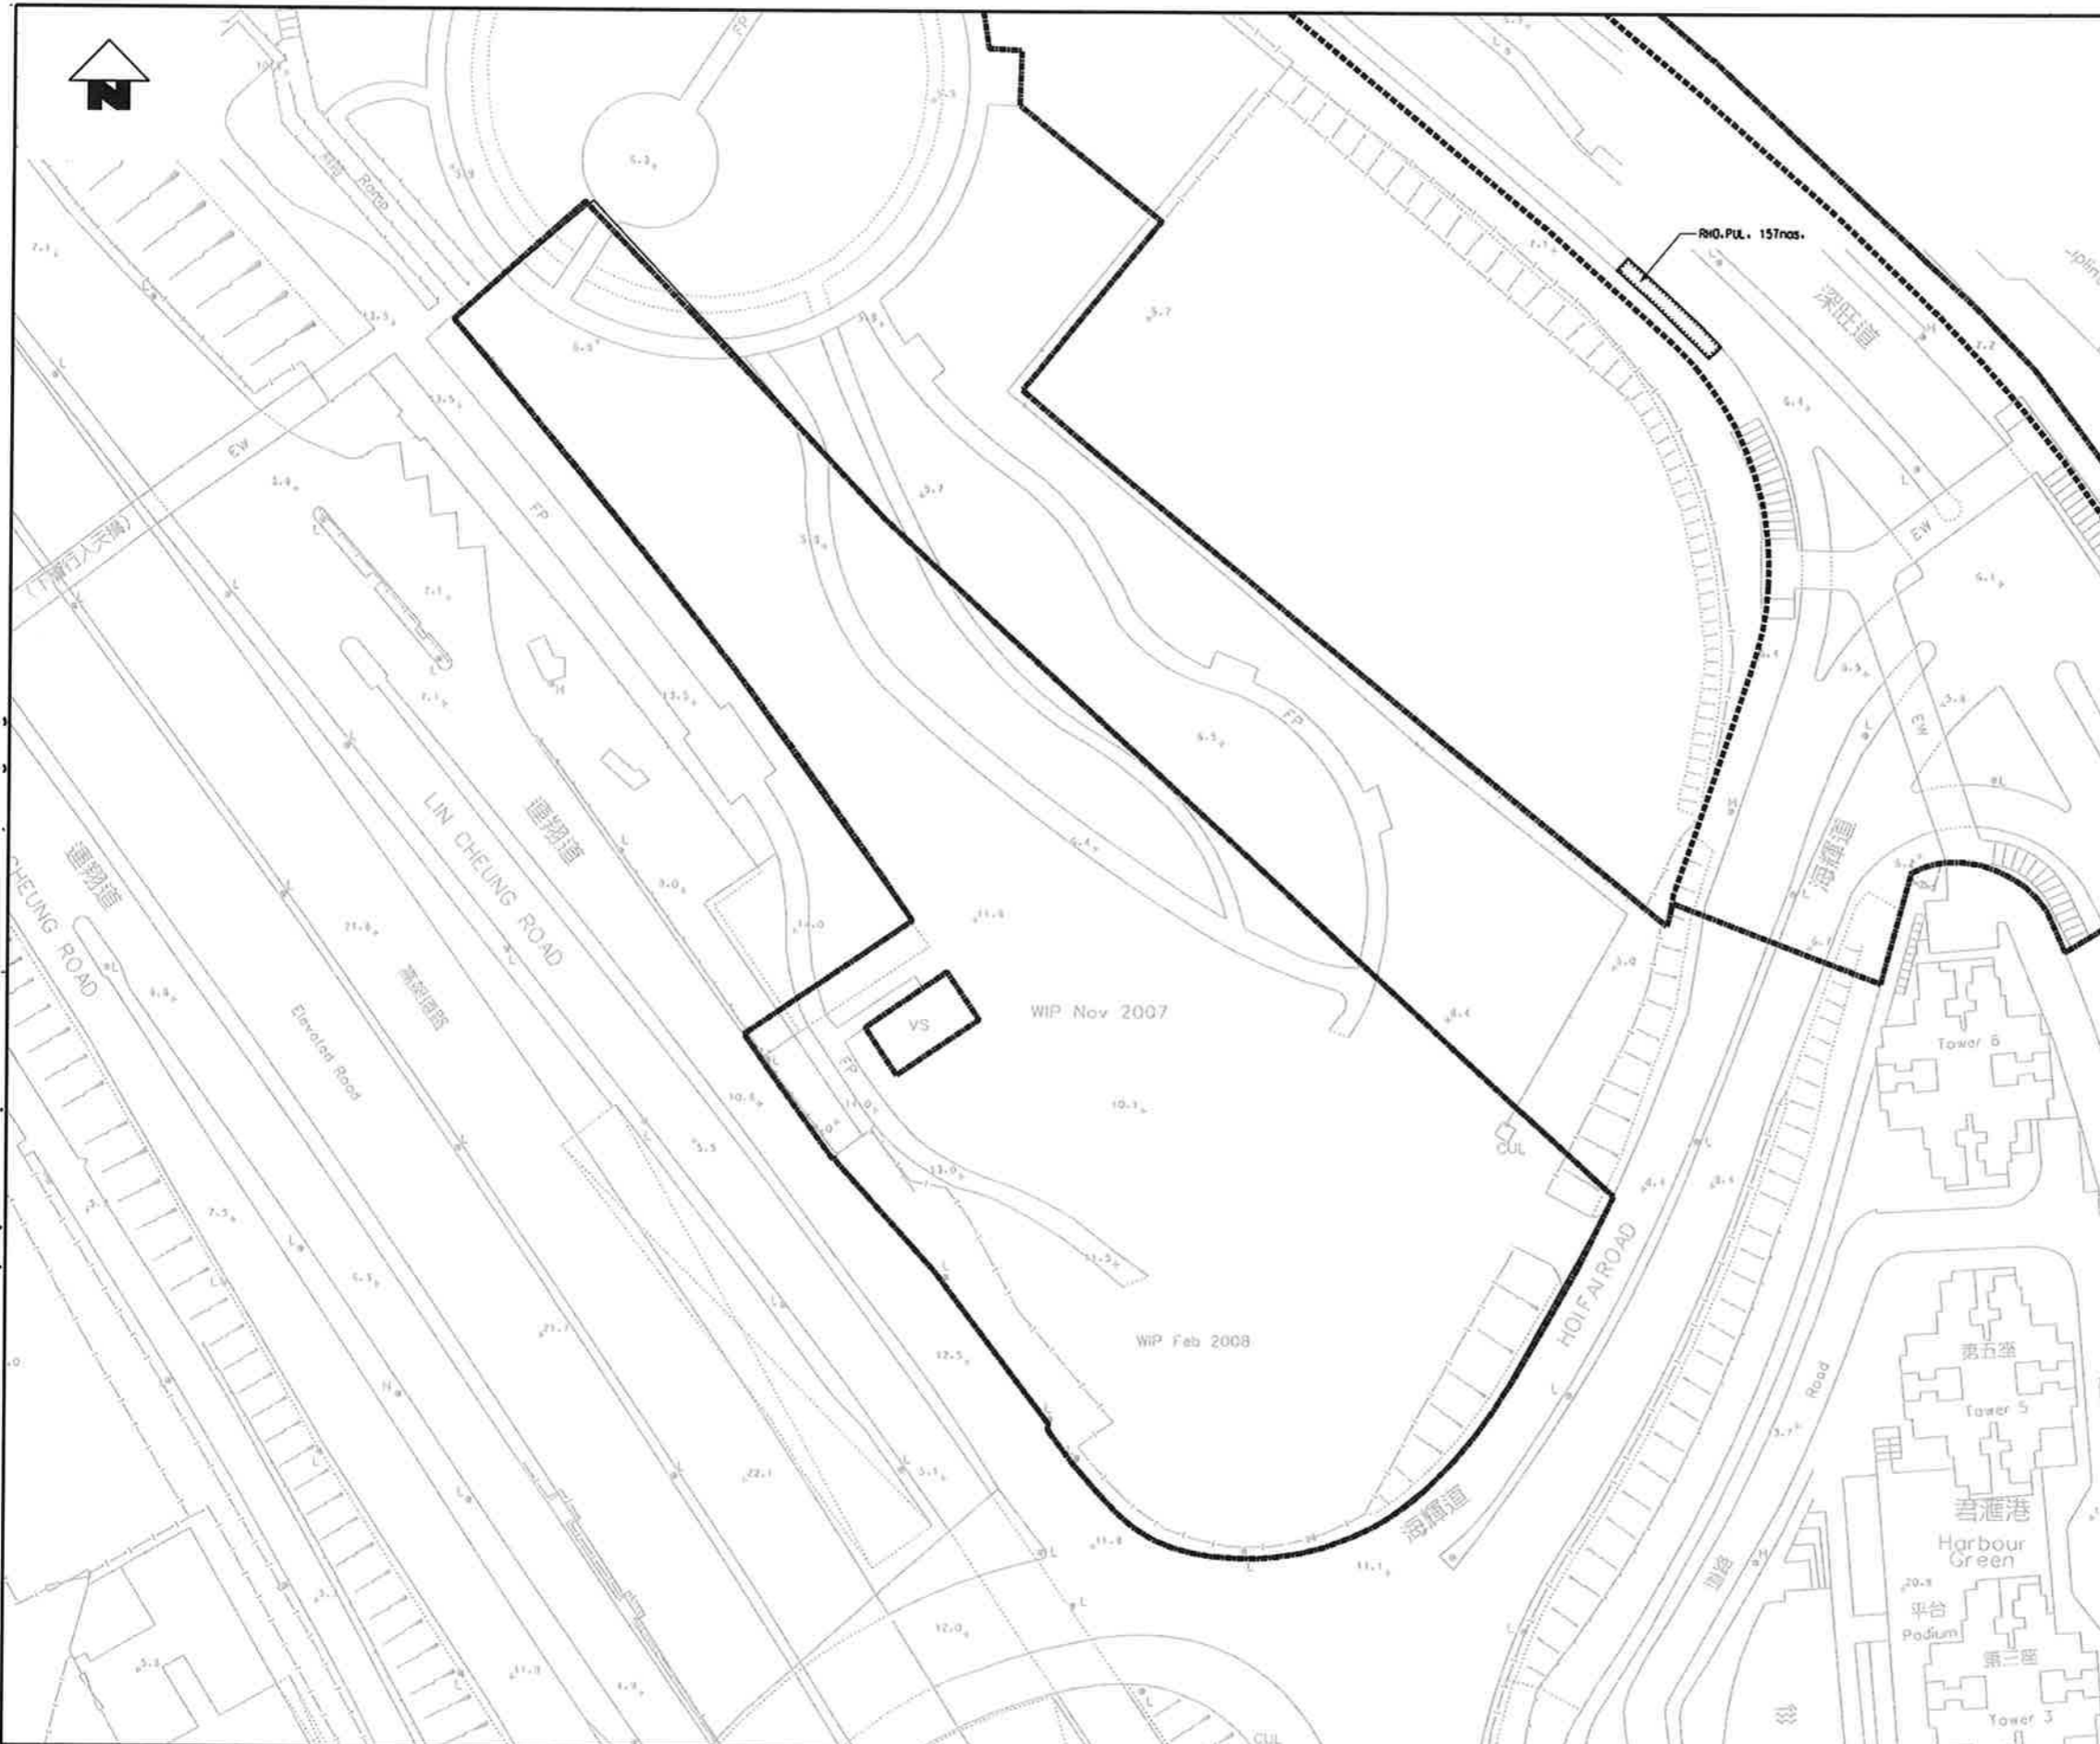

KEY PLAN SCALE 1:5000

LEGEND

	SHURB
	GROUND COVER

 


REV	DESCRIPTION	BY	DATE	APPROVED	REV	DESCRIPTION	BY	DATE	APPROVED
					A	TENDER ADDENDUM NO. 2	AC	30NOV09	TM

DRAWN	SK
DESIGNED	AC
CHECKED	KN
APPROVED	TM
DATE	30/NOV/09

© MTR CORPORATION LIMITED 2009. ALL DIMENSIONS SHALL BE NOTED ON SITE.
 © MTR CORPORATION LIMITED 2009. COPYRIGHT IN RESPECT OF THIS DRAWING / DOCUMENT IS OWNED BY THE MTR CORPORATION LIMITED OF HONG KONG. NO REPRODUCTION OF THE DRAWING / DOCUMENT OR ANY PART OF EITHER HEREIN IS PERMITTED WITHOUT THE PRIOR WRITTEN CONSENT OF THE MTR CORPORATION LIMITED.


MTR
EXPRESS RAIL LINK
 ORIGINATOR
ATKINS Supported by Arup, TFP, Farrells, DLS, Kenneth Ng
 CADD REF. 820_T_380_ATK_A58_881A.dgn

TITLE	CONTRACT 820 MEI LAI ROAD TO HOI TING ROAD TUNNELS SHAM SHUI PO DISTRICT PLANTING PLAN (SHEET 2 OF 11)
SCALE	1 : 500 (A1)
DRAWING NO.	820/T/380/ATK/A58/881
REV.	A


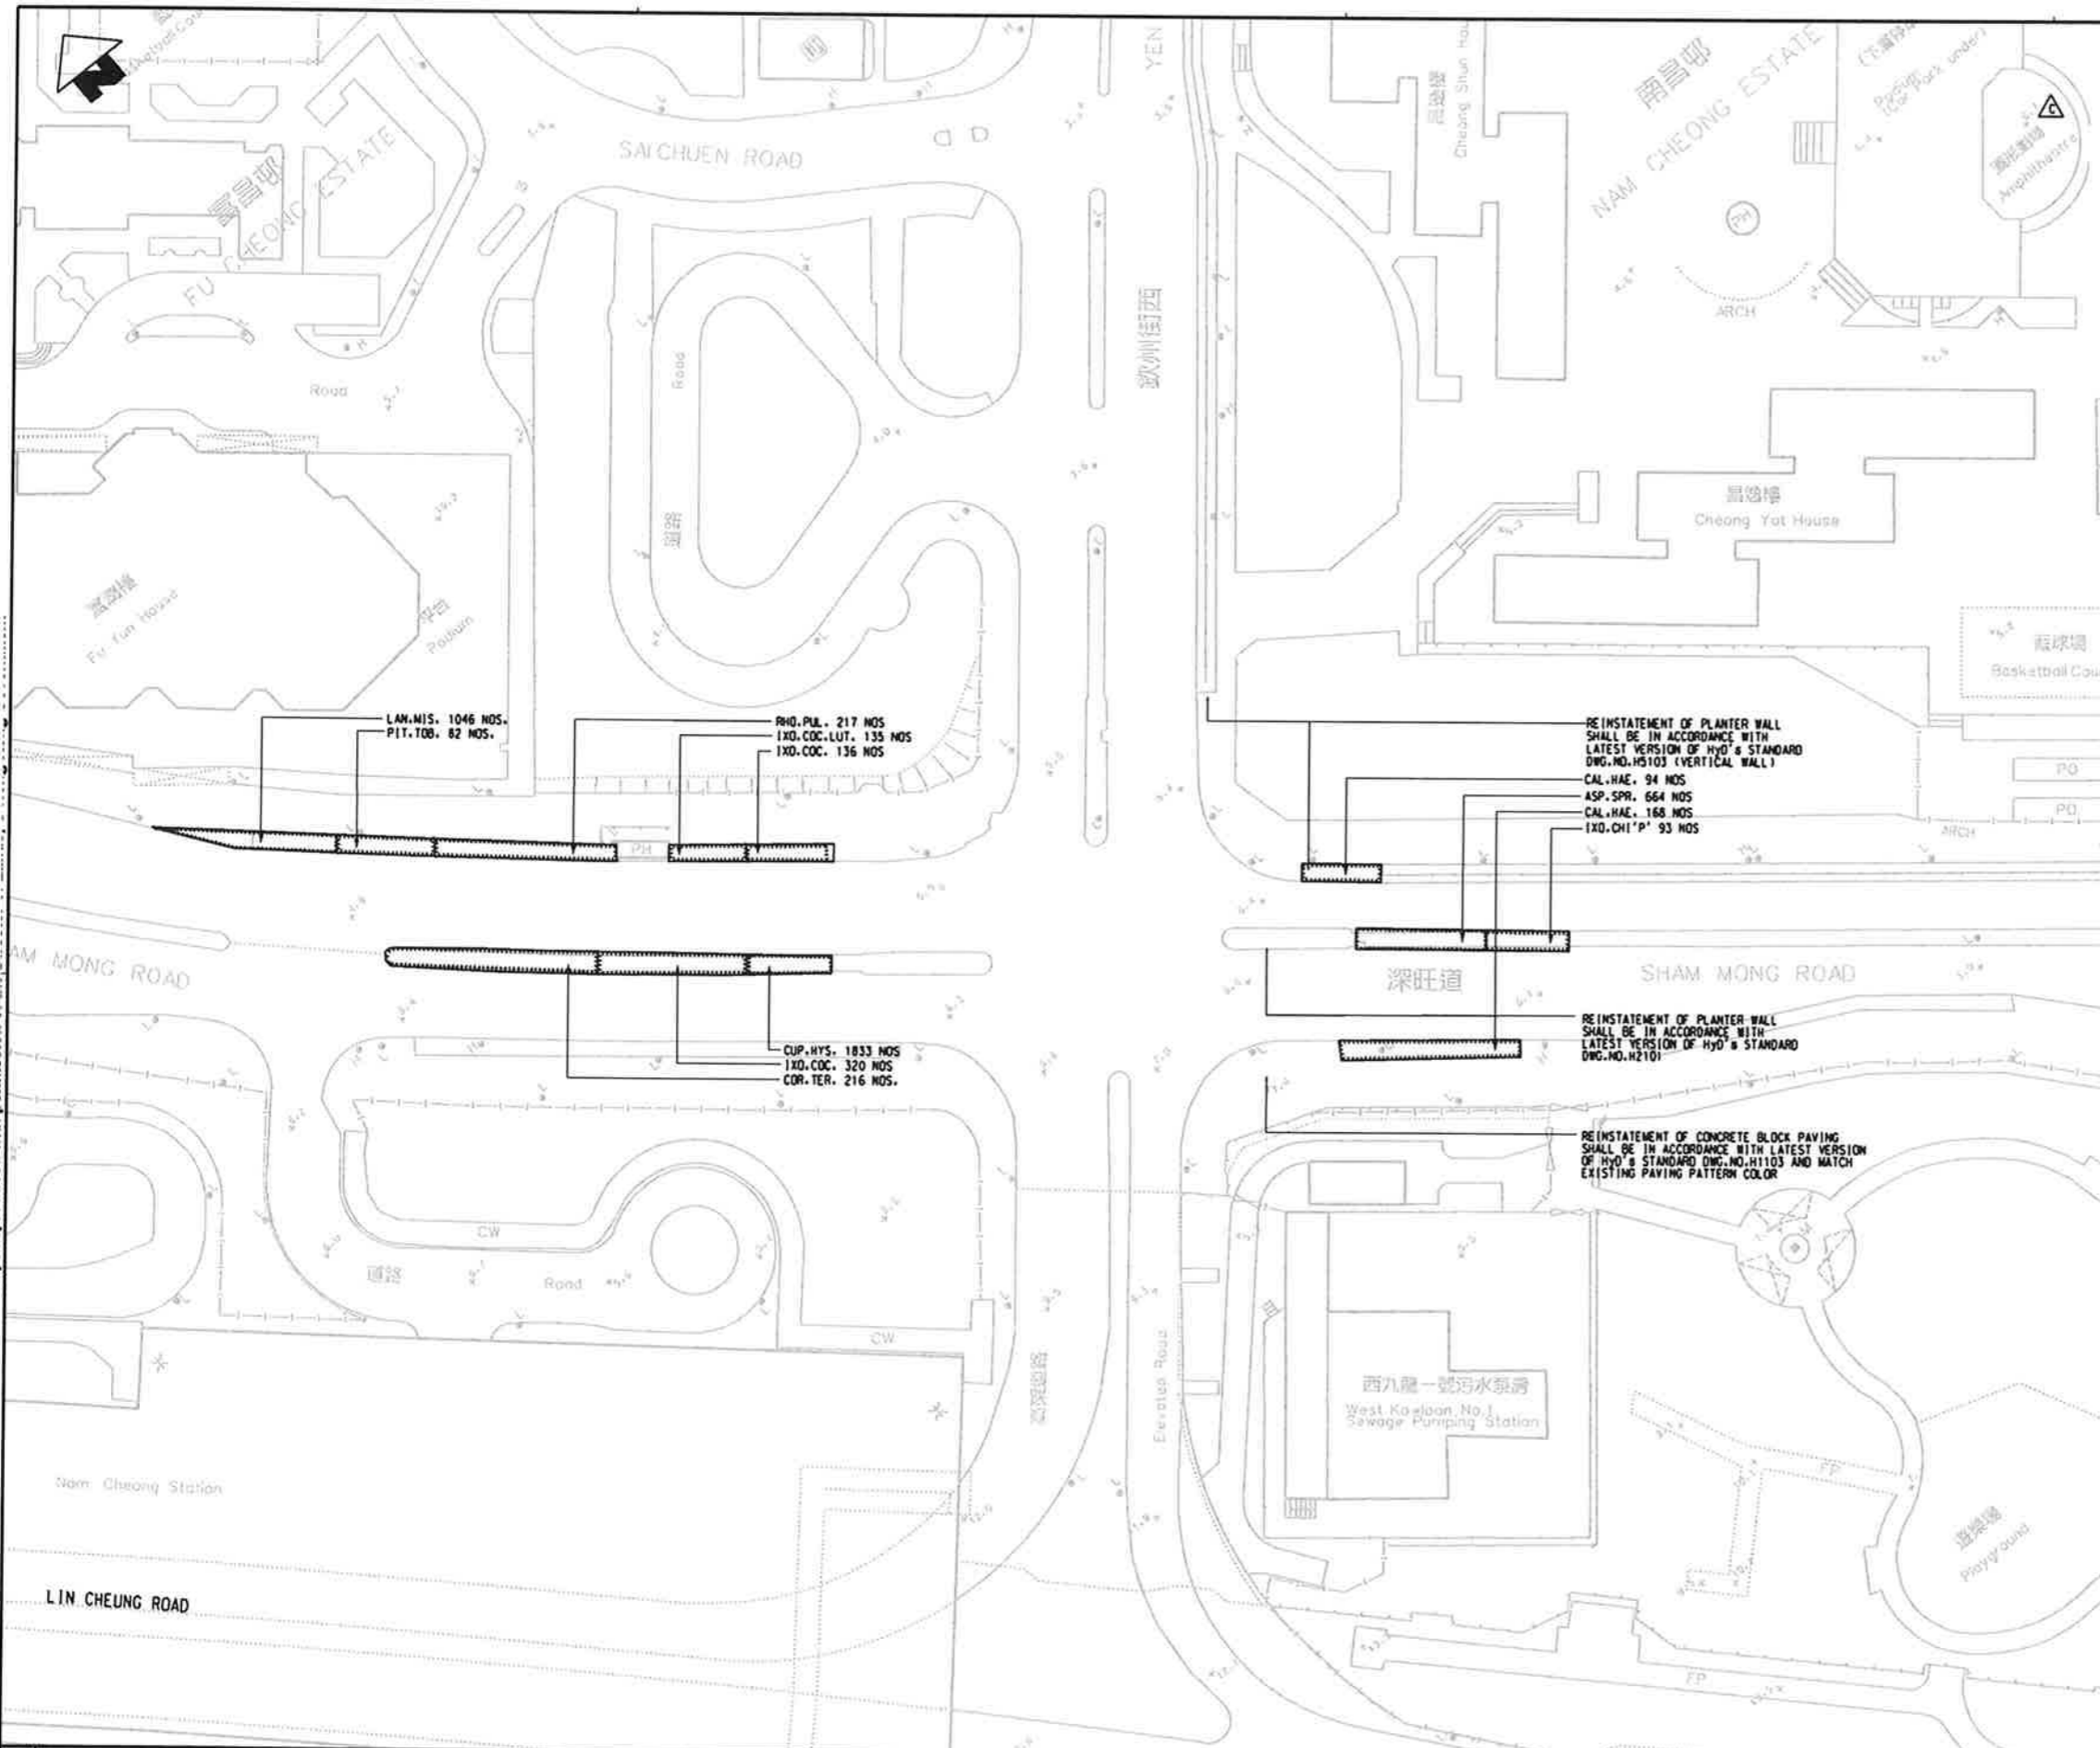


NOTES:
FOR GENERAL NOTE, REFER TO DWG. NO. 820/T/NCV/ATK/A58/800

LEGEND:
FOR GENERAL LEGEND, REFER TO DWG. NO. 820/T/NCV/ATK/A58/801

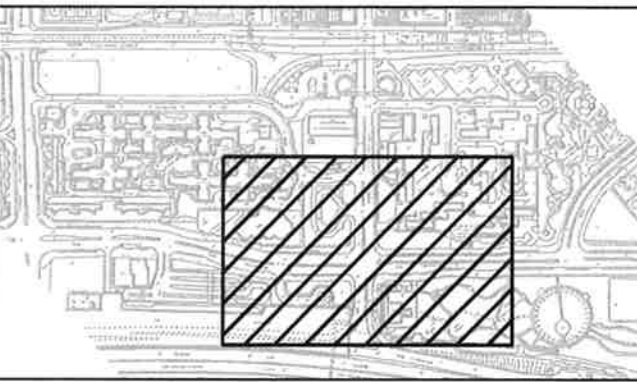

KEY LOCATION PLAN SCALE 1 : 5000

 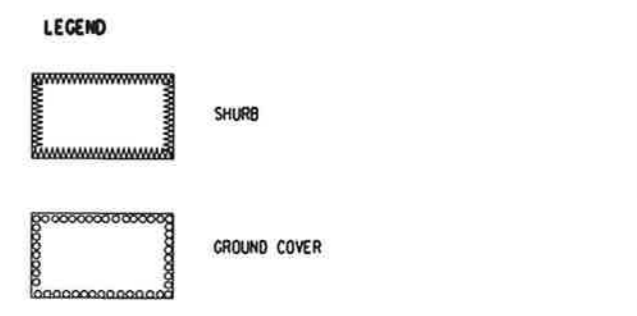

REV	DESCRIPTION	BY	DATE	APPROVED	REV	DESCRIPTION	BY	DATE	APPROVED
A	TENDER ADDENDUM NO.2				AC	SONOYOS	TM		

DRAWN	SK
DESIGNED	AC
CHECKED	KN
APPROVED	TM
DATE	30/NOV/2009

MTR

EXPRESS RAIL LINK

ORIGINATOR

ATKINS Supported by Arup, TFP, Farrells, DLS, Kenneth Ng

CAAD REF. 820-T-380-ATK-A58-882A.DGN



TITLE

CONTRACT 820
MEI LAI ROAD TO HOI TING ROAD TUNNELS
SHAM SHUI PO DISTRICT - DSD CULVERT MCI WORKS AREA
PLANTING PLAN
(SHEET 3 OF 11)


 
SCALE 1 : 500 (A1)


DRAWING NO. 820/T/380/ATK/A58/882

REV. A

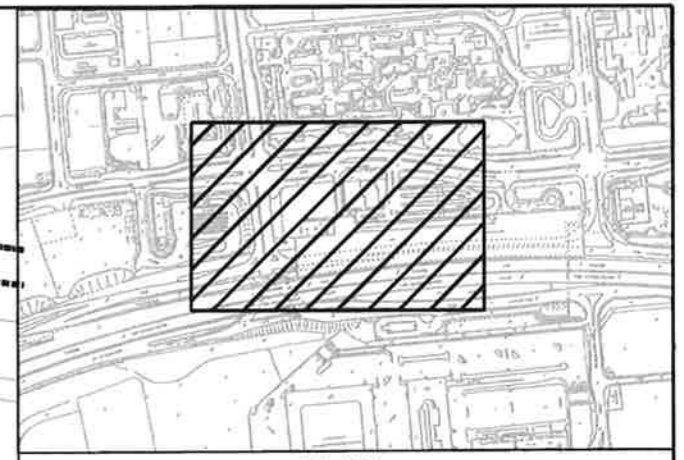
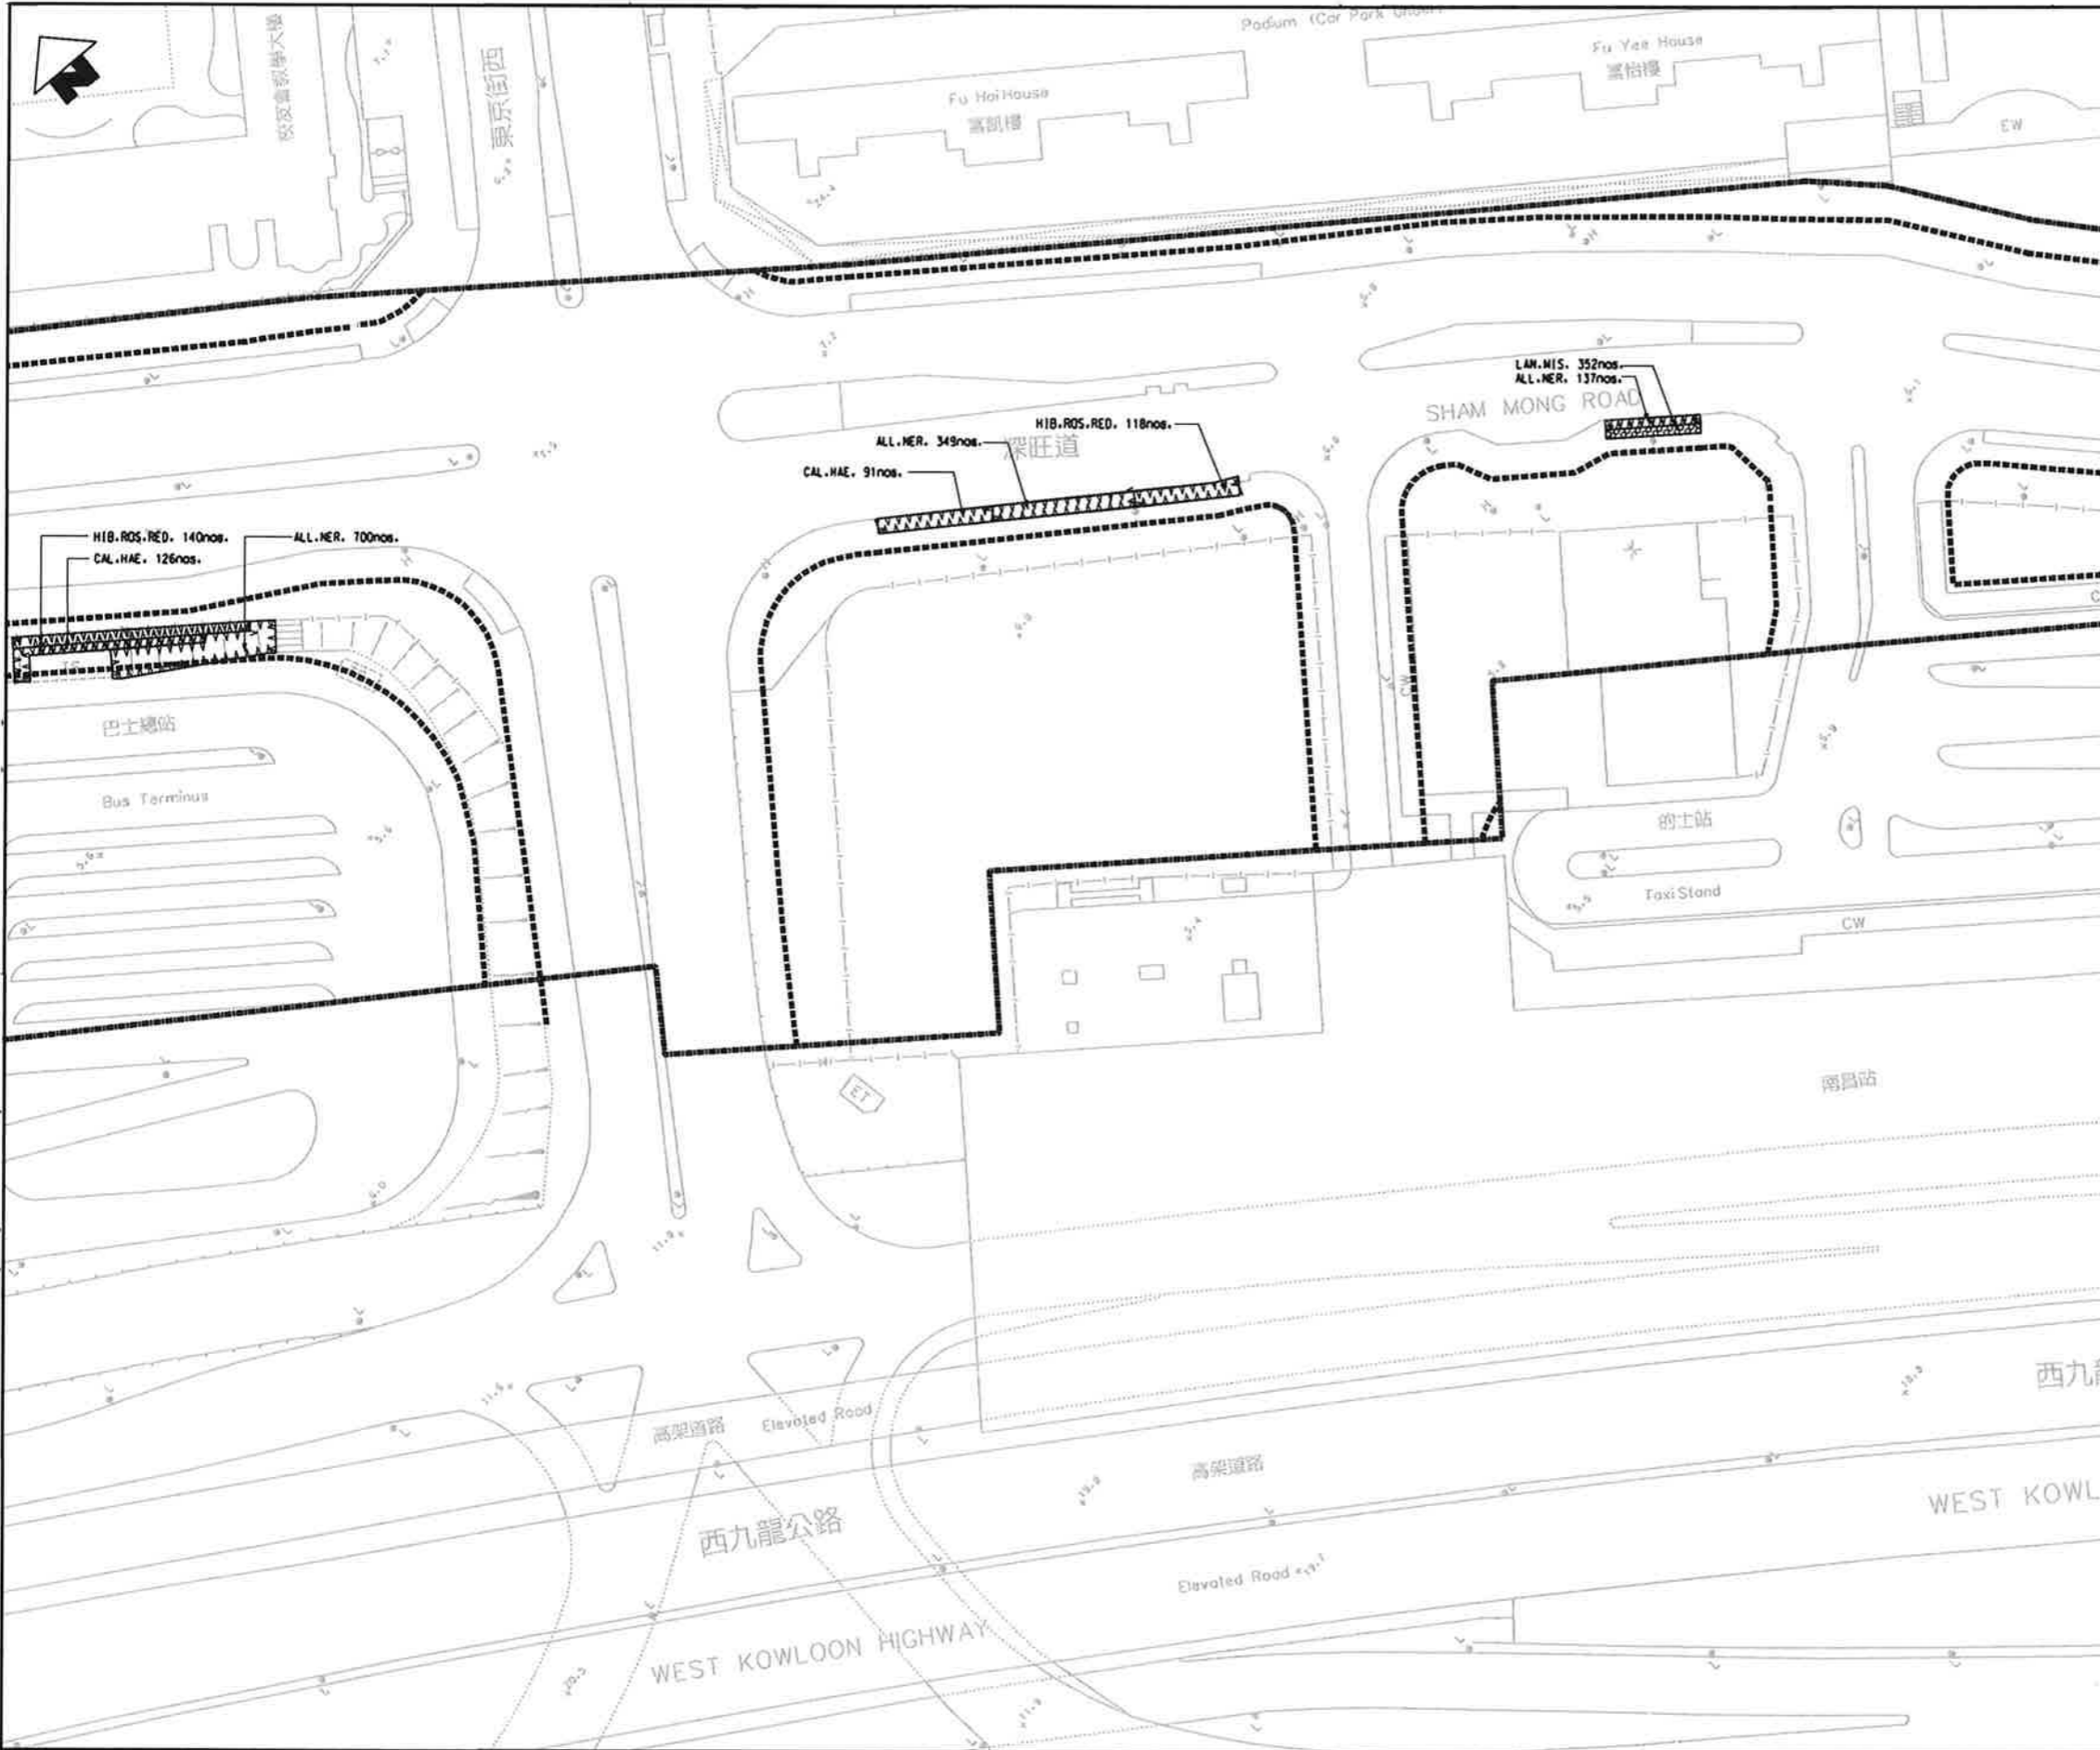


KEY PLAN SCALE 1:15000

 - LEGEND**
-  SHURB
 -  GROUND COVER




				DRAWN SK DESIGNED AC CHECKED KN APPROVED TM DATE 10/NOV/09 <small>FOR SCALE DRAWINGS, ALL DIMENSIONS SHALL BE VERIFIED ON SITE. © 2009 COMPASSION & LINER 2009 COPYRIGHT IN RESPECT OF THIS DRAWING / DOCUMENT IS OWNED BY THE NEW CORPORATION LIMITED OF HONG KONG. NO REPRODUCTION OR TRANSMISSION OF ANY PART OF THIS DRAWING IS PERMITTED WITHOUT THE PRIOR WRITTEN CONSENT OF THE NEW CORPORATION LIMITED.</small>	 EXPRESS RAIL LINK ORIGINATOR ATKINS Supported by Arup, TFP, Farrells, DLS, Kenneth Ng CADD REF. 820_T_380_ATK_A58_883A.dgn				CONTRACT 820 MEI LAI ROAD TO HOI TING ROAD TUNNELS SHAM SHUI PO DISTRICT PLANTING PLAN (SHEET 4 OF 11)			
REV	DESCRIPTION	BY	DATE	APPROVED	REV	DESCRIPTION	BY	DATE	APPROVED	SCALE	DRAWING NO.	REV.
A	TENDER ADDENDUM NO. 2	AC	30NOV09	TM						1 : 500 (A1)	820/T/380/ATK/A58/883	A

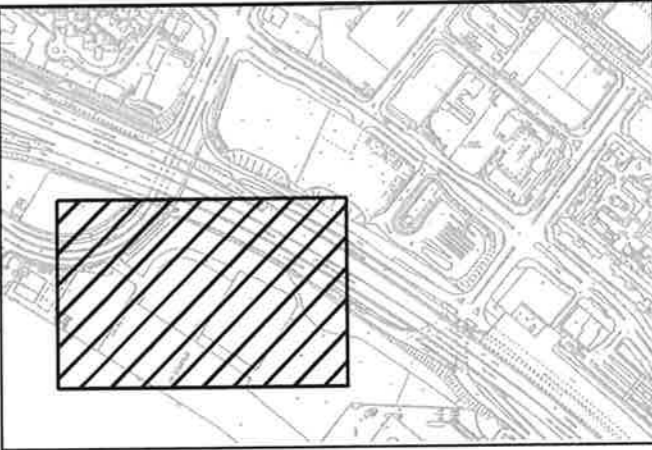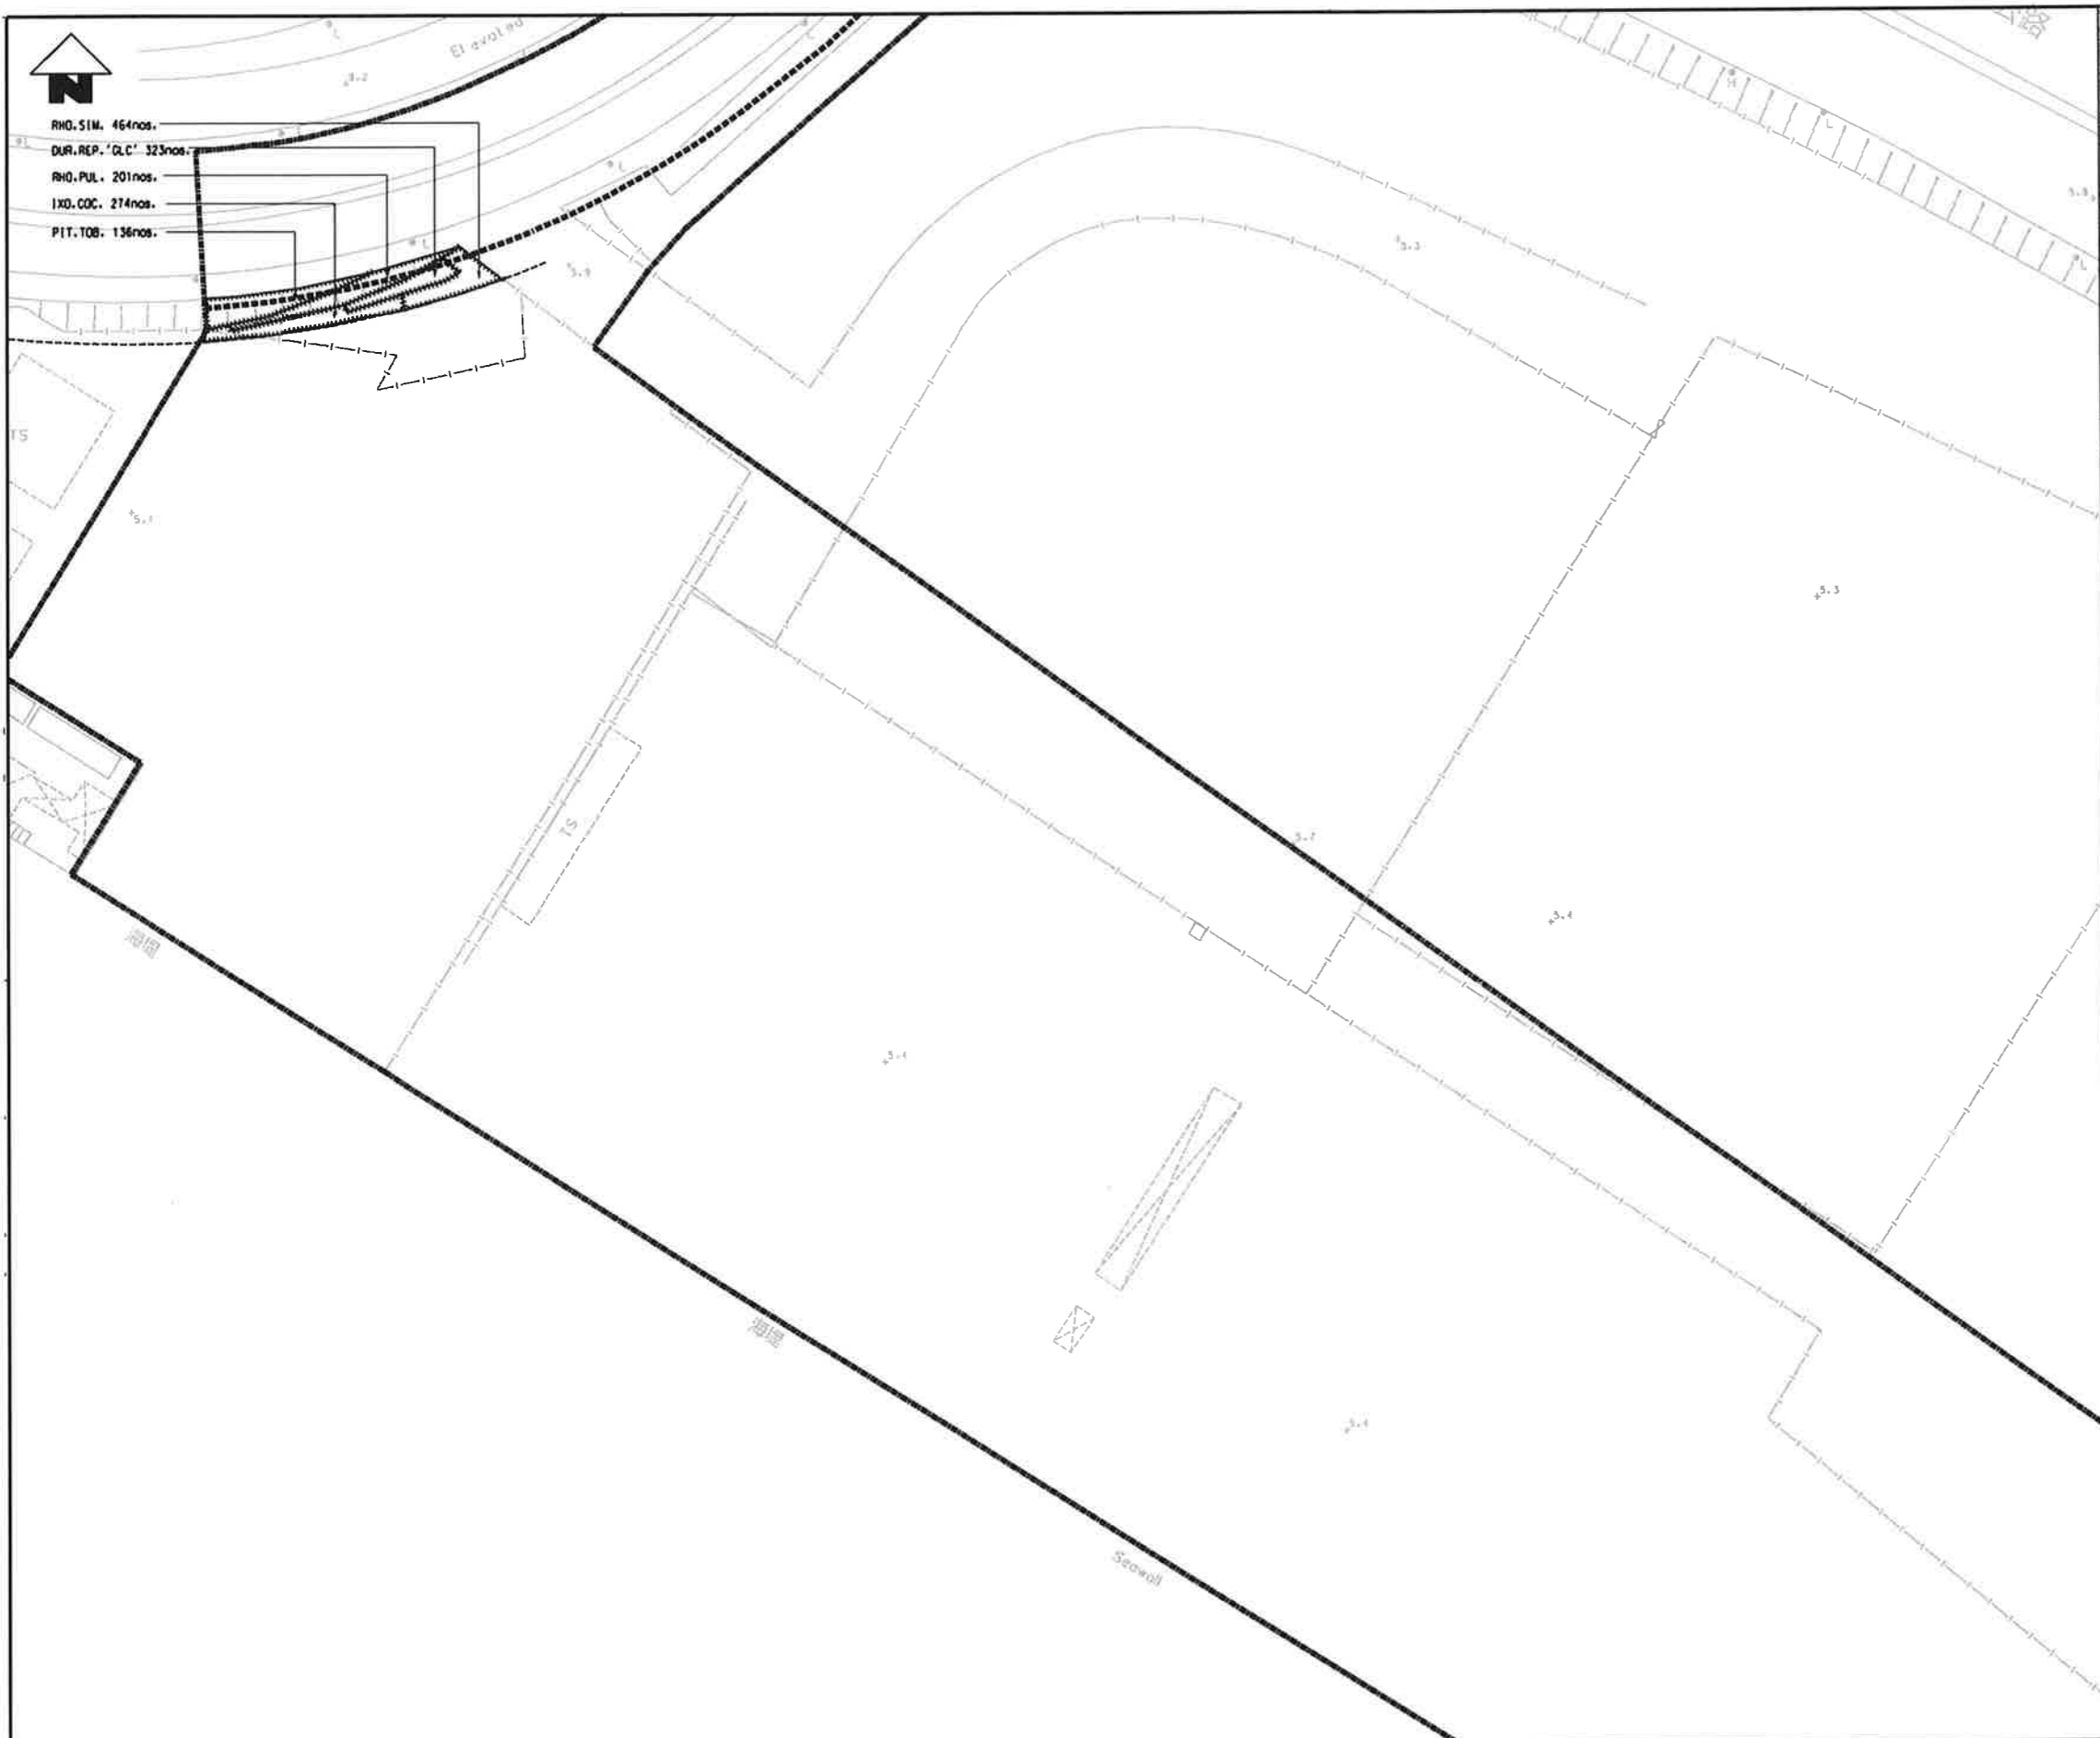

KEY PLAN SCALE 1:15000

LEGEND

 - SHRUB
- GROUND COVER



REV	DESCRIPTION	BY	DATE	APPROVED	REV	DESCRIPTION	BY	DATE	APPROVED
A	TENDER ADDENDUM NO.2	AC	DONDY09	TM					

DRAWN	SK
DESIGNED	AC
CHECKED	KN
APPROVED	TM
DATE	30/NOV/09

MTR
EXPRESS RAIL LINK

ORIGINATOR
ATKINS Supported by
Arup, TFP, Farrells, DLS
Kenneth Ng



CADD REF.
820_T_380_ATK_A58_884A.dgn

TITLE
CONTRACT 820
MEI LAI ROAD TO HOI TING ROAD TUNNELS
SHAM SHUI PO DISTRICT
PLANTING PLAN
(SHEET 5 OF 11)

SCALE
1 : 500 (A1)

DRAWING NO.
820/T/380/ATK/A58/884


REV. A

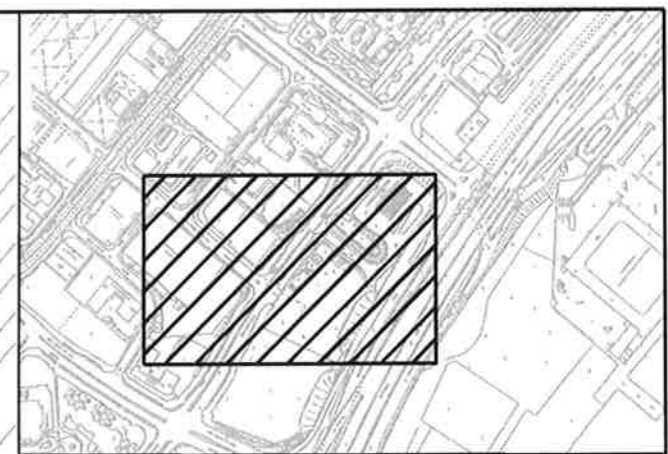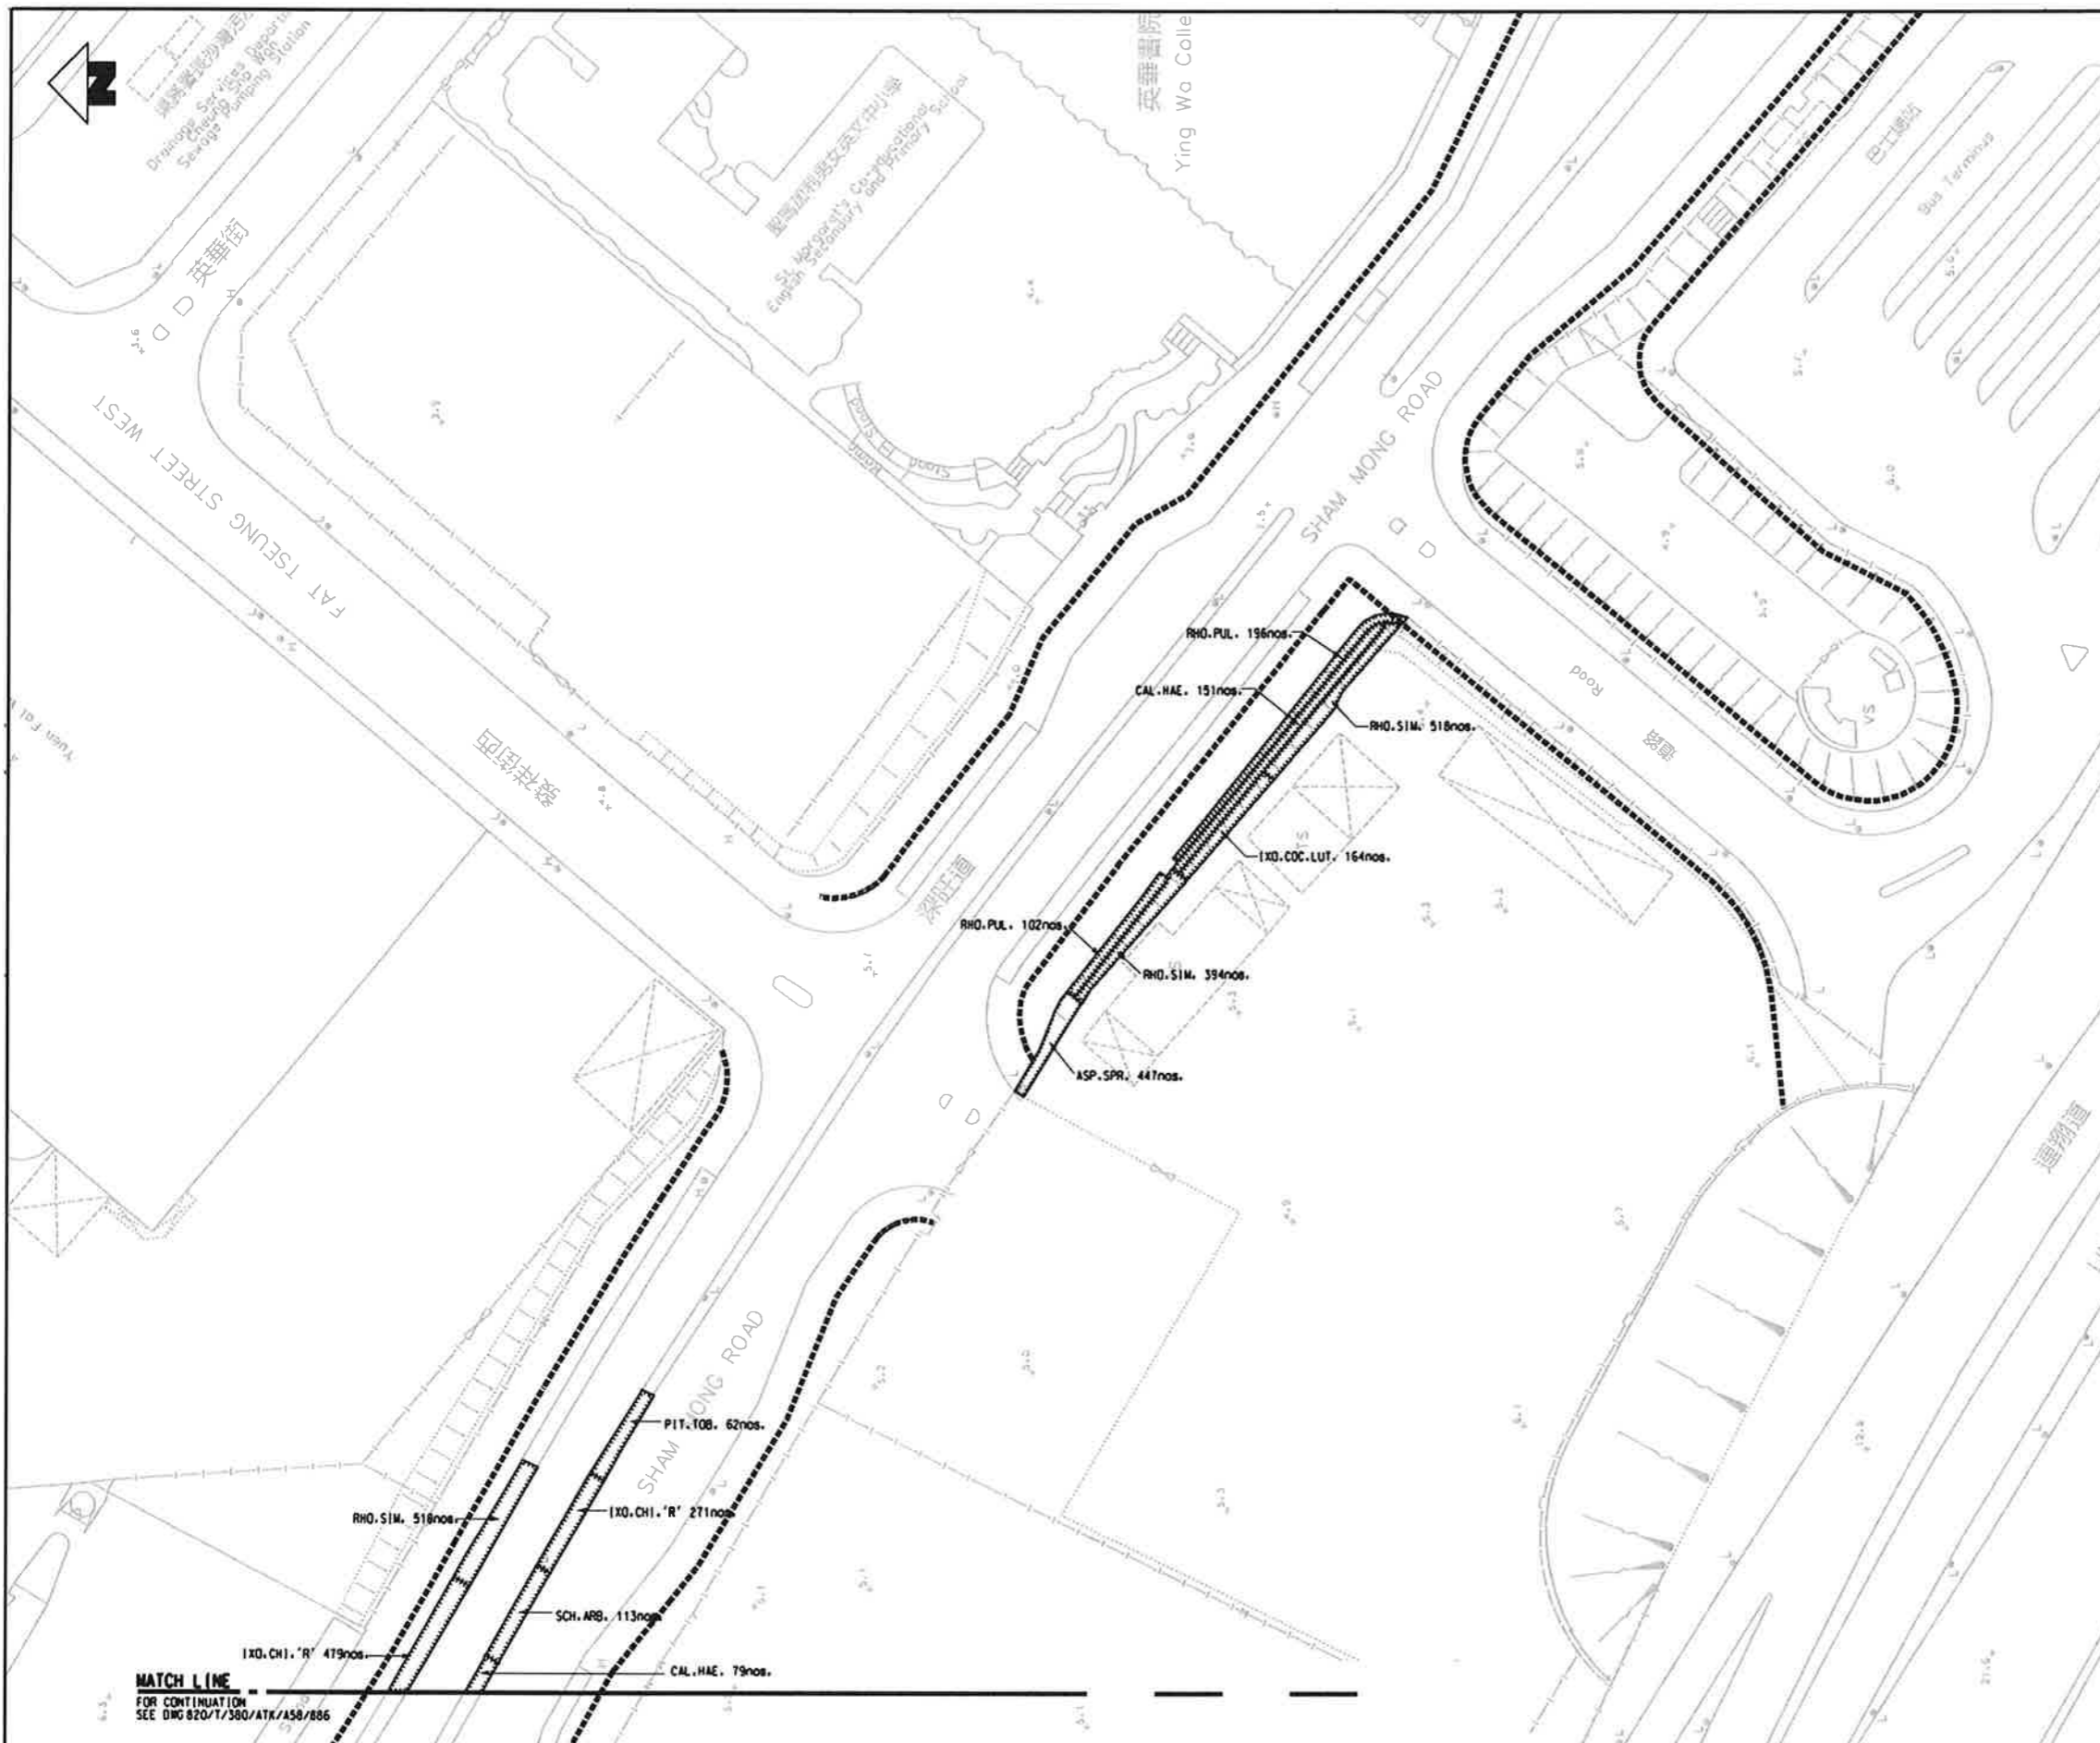

KEY PLAN SCALE 1:5000

LEGEND

	SHRUB
	GROUND COVER

 

		DRAWN SK		<p>EXPRESS RAIL LINK</p> <p>ATKINS Supported by Arup, TFP Farrells, DLS Kenneth Ng</p> <p>ORIGINATOR</p> <p>CADD REF. 820_T_380_ATK_A58_885A.dgn</p>					
		DESIGNED AC							
		CHECKED KN							
		APPROVED TM							
		DATE 30/NOV/09							
		BY DATE APPROVED		<p>BE NOT SCALE DRAWING. ALL DIMENSIONS SHALL BE INDICATED ON SITE.</p> <p>NO PART OF THIS DRAWING OR DOCUMENT IS TO BE REPRODUCED OR TRANSMITTED IN ANY FORM OR BY ANY MEANS, ELECTRONIC OR MECHANICAL, INCLUDING PHOTOCOPYING, RECORDING, OR BY ANY INFORMATION STORAGE AND RETRIEVAL SYSTEM, WITHOUT THE WRITTEN PERMISSION OF THE CONTRACTOR.</p>					
REV	DESCRIPTION	BY	DATE	APPROVED	REV	DESCRIPTION	BY	DATE	APPROVED
	A	TENDER ADDENDUM NO.2			AC	30/NOV/09	TM		

TITLE		CONTRACT 820	
		MEI LAI ROAD TO HOI TING ROAD TUNNELS	
		SHAM SHUI PO DISTRICT	
		PLANTING PLAN	
		(SHEET 6 OF 11)	
SCALE	1:400 (A1)	DRAWING NO.	820/T/380/ATK/A58/885
REV.	A		

MATCH LINE
FOR CONTINUATION
SEE DWG 820/T/380/ATK/A58/885

ALL.NER. 301nos.
SCH.ARB. 87nos.
RHO.PUL. 85nos.
DUR.REP. 615nos.

PIT.TOB. 98nos.
CAL.HAE. 109nos.
SCH.ARB. 212nos.
RHO.PUL. 165nos.

SCH.ARB.VAR. 148nos.
LAN.MIS. 450nos.
IXD.CHI.'P' 191nos.

IXD.COC. 150nos.
LAN.MIS. 562nos.

PIT.TOB. 148nos.
IXD.COC.LUT. 325nos.

ALL.NER. 388nos.

PIT.TOB. 121nos.
DUR.REP. 440nos.

PIT.TOB. 165nos.
IXD.COC. 362nos.

DUR.REP.'CL' 568nos.

SCH.ARB. 208nos.

PIT.TOB. 113nos.

SCH.ARB. 129nos.


IXD.CHI.'R' 261nos.

LAN.MIS. 680nos.
RHO.PUL. 187nos.
RHO.SIM. 700nos.

IXD.CHI.'P' 643nos.
LAN.MIS. 1009nos.


SCH.ARB.VAR. 149nos.

CAL.HAE. 154nos.
ALL.NER. 564nos.
PIT.TOB. 73nos.
IXD.CHI.'P' 208nos.
SCH.ARB. 288nos.

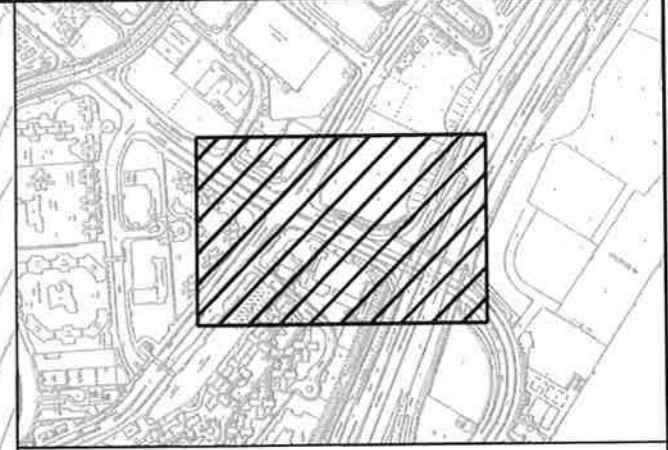


KEY PLAN SCALE 1:15000

 
LEGEND



SHURB

 

GROUND COVER

 

REV	DESCRIPTION	BY	DATE	APPROVED	REV	DESCRIPTION	BY	DATE	APPROVED
A	TENDER ADDENDUM NO.2	AC	30/NOV/09	TM					

DRAWN	SK
DESIGNED	AC
CHECKED	KN
APPROVED	TM
DATE	30/NOV/09

MTR



EXPRESS RAIL LINK

ORIGINATOR

ATKINS Supported by Arup, TFP Farrells, DLS Kenneth Ng

CADD REF. 820.T.380.ATK.A58.886A.dgn


TITLE		CONTRACT 820	
		MEI LAI ROAD TO HOI TING ROAD TUNNELS	
		SHAM SHUI PO DISTRICT	
		PLANTING PLAN	
		(SHEET 7 OF 11)	
SCALE	1 : 500 (A1)	DRAWING NO.	820/T/380/ATK/A58/886
REV.			A

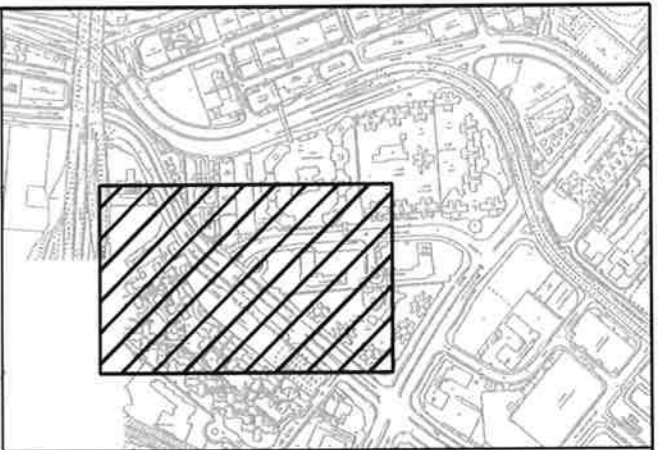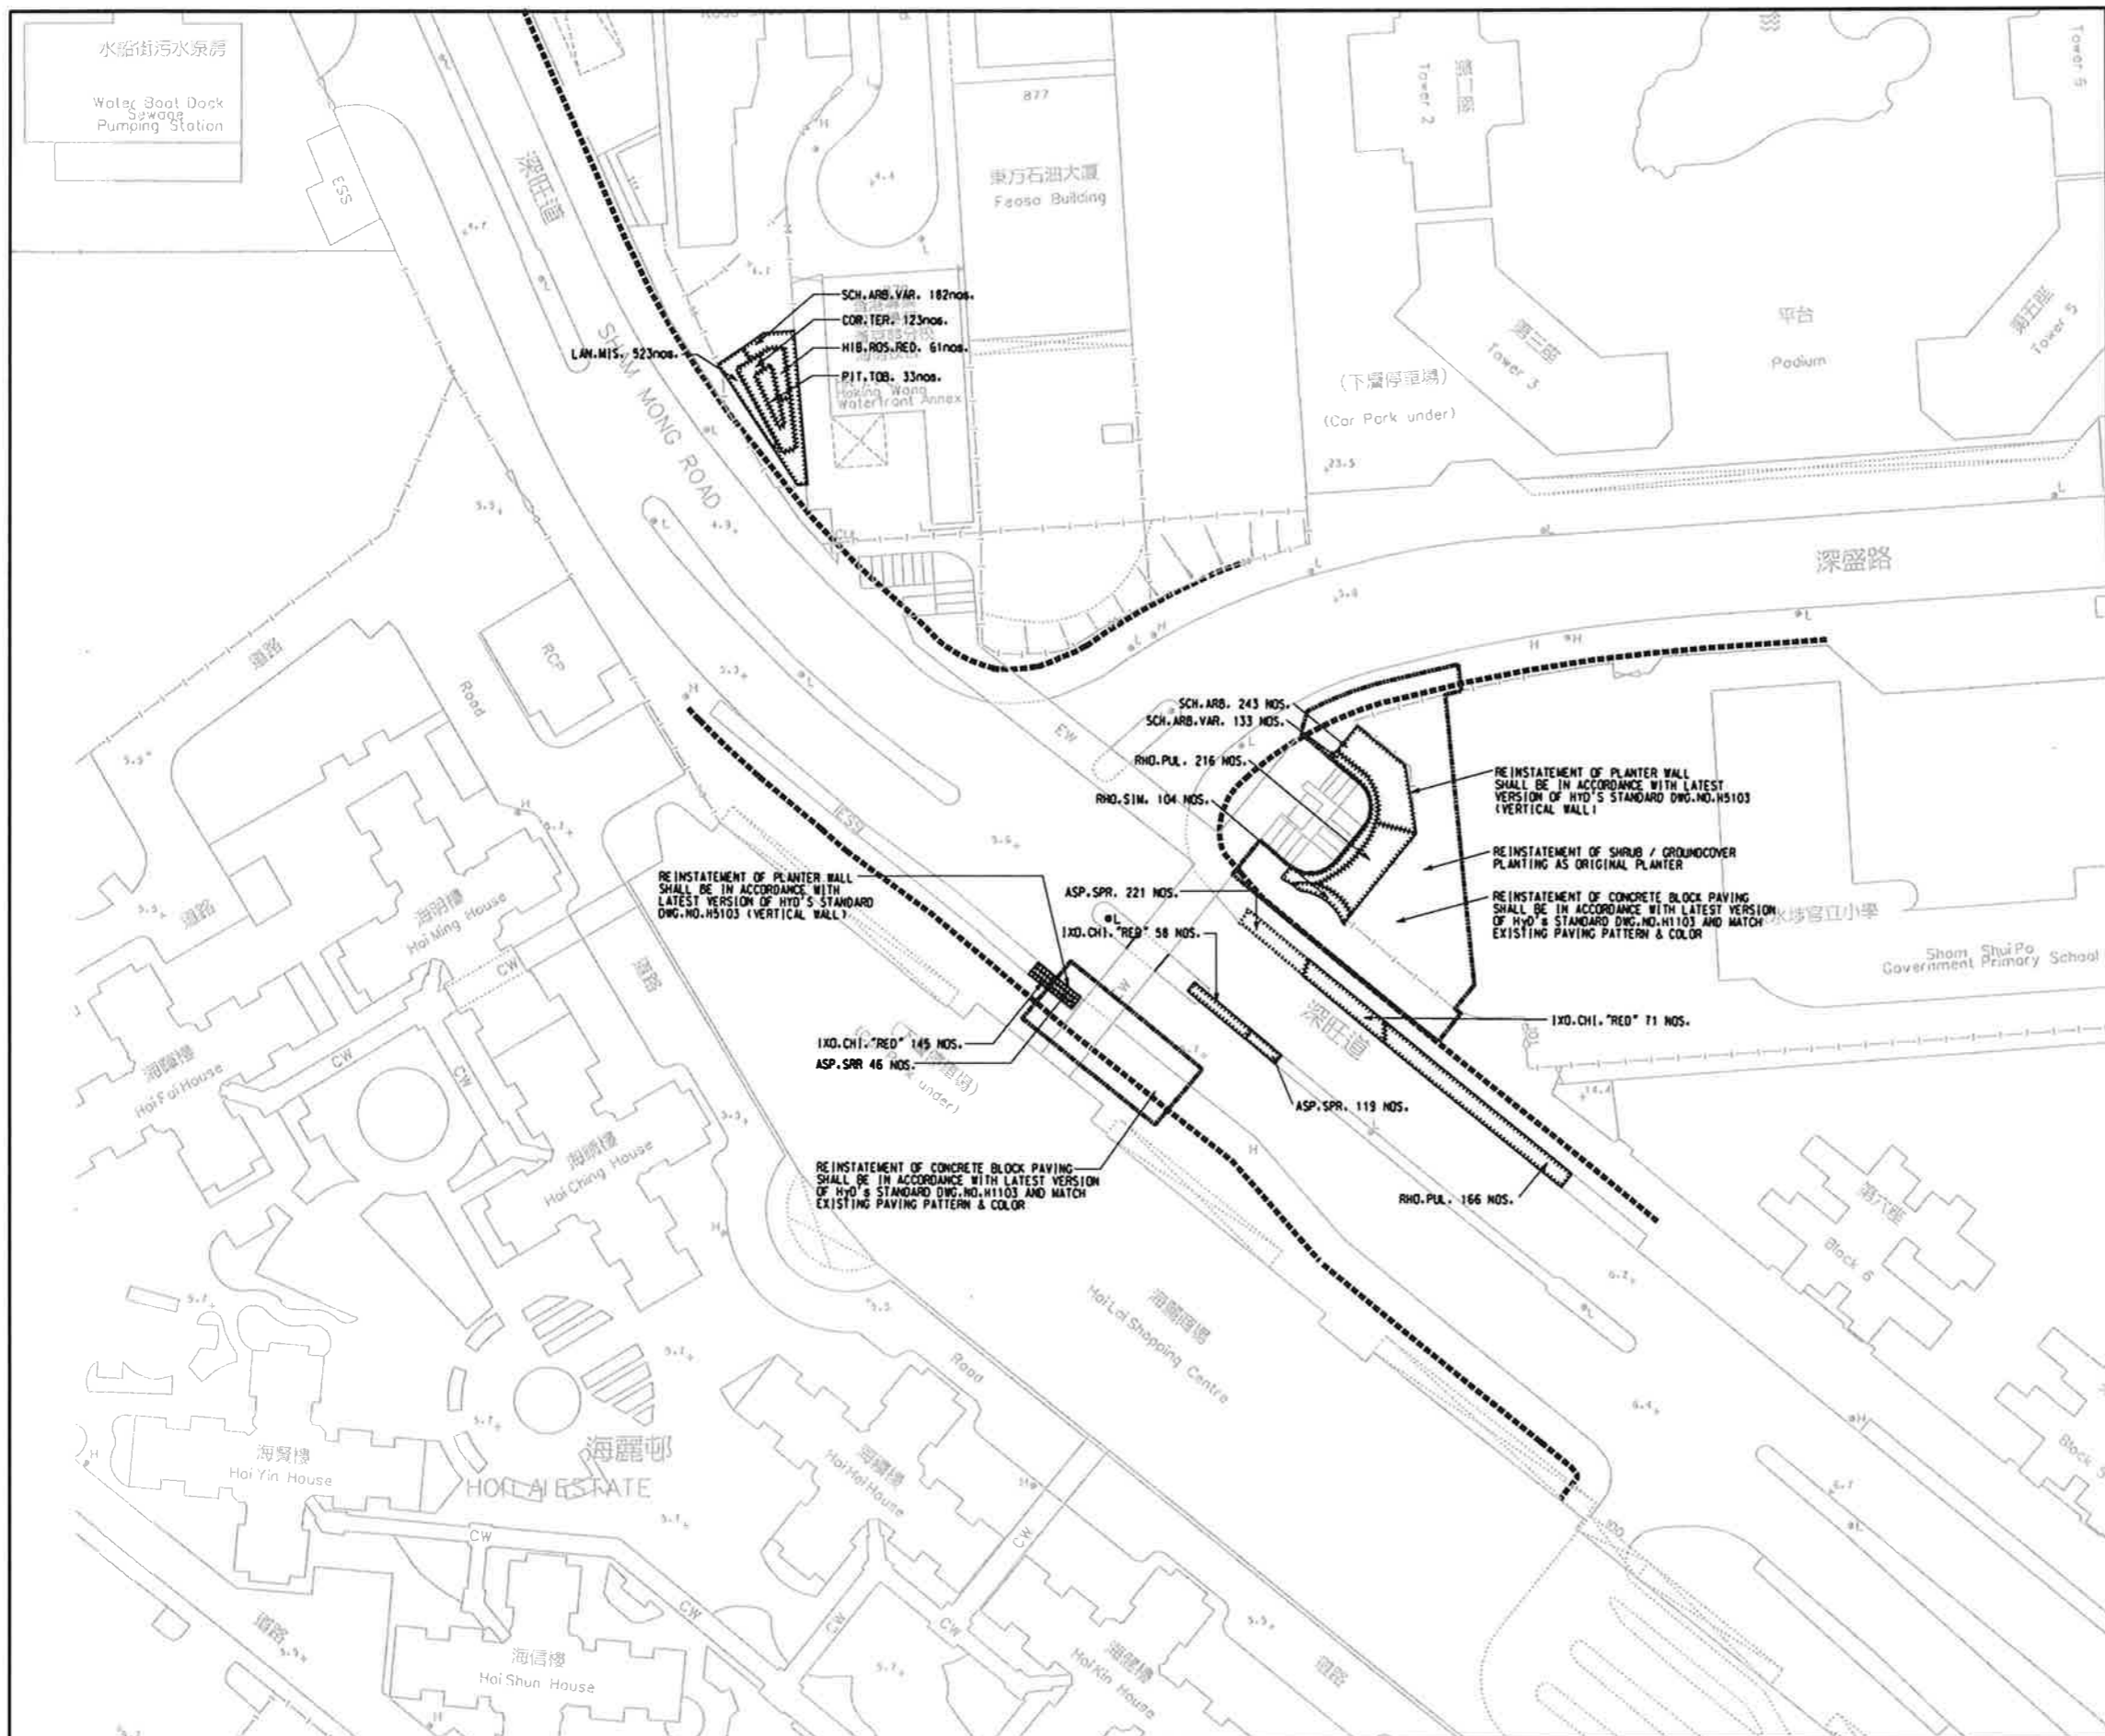



KEY PLAN SCALE 1:15000

LEGEND

 - SHRUB
- GROUND COVER




DRAWN SK		DESIGNED AC		CHECKED KN		APPROVED TM		DATE 30/NOV/09			
TENDER ADDENDUM NO.2		AC 30NOV09		TM				EXPRESS RAIL LINK Supported by Arup, TFP, Farrells, DLS Kenneth Ng		ORIGINATOR CADD REF. 820_T_380_ATK_A58_887A.dgn	
REV	DESCRIPTION	BY	DATE	APPROVED	REV	DESCRIPTION	BY	DATE	APPROVED	SCALE	TITLE CONTRACT 820 MEI LAI ROAD TO HOI TING ROAD TUNNELS SHAM SHUI PO DISTRICT / FOOTBRIDGE KF118 WORKS AREA PLANTING PLAN (SHEET 8 OF 11)
										1 : 500 (A1)	DRAWING NO. 820/T/380/ATK/A58/887

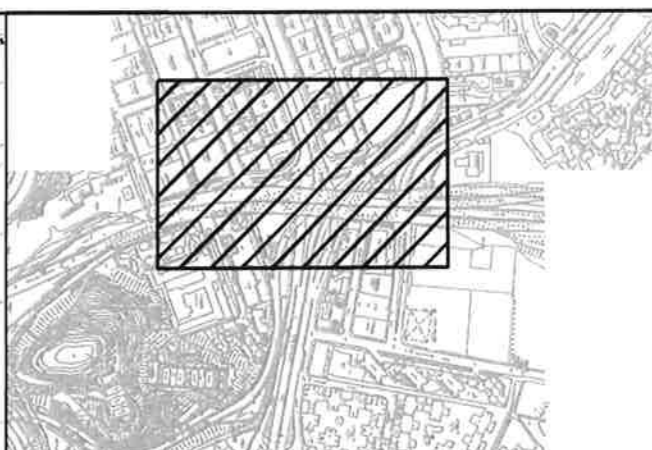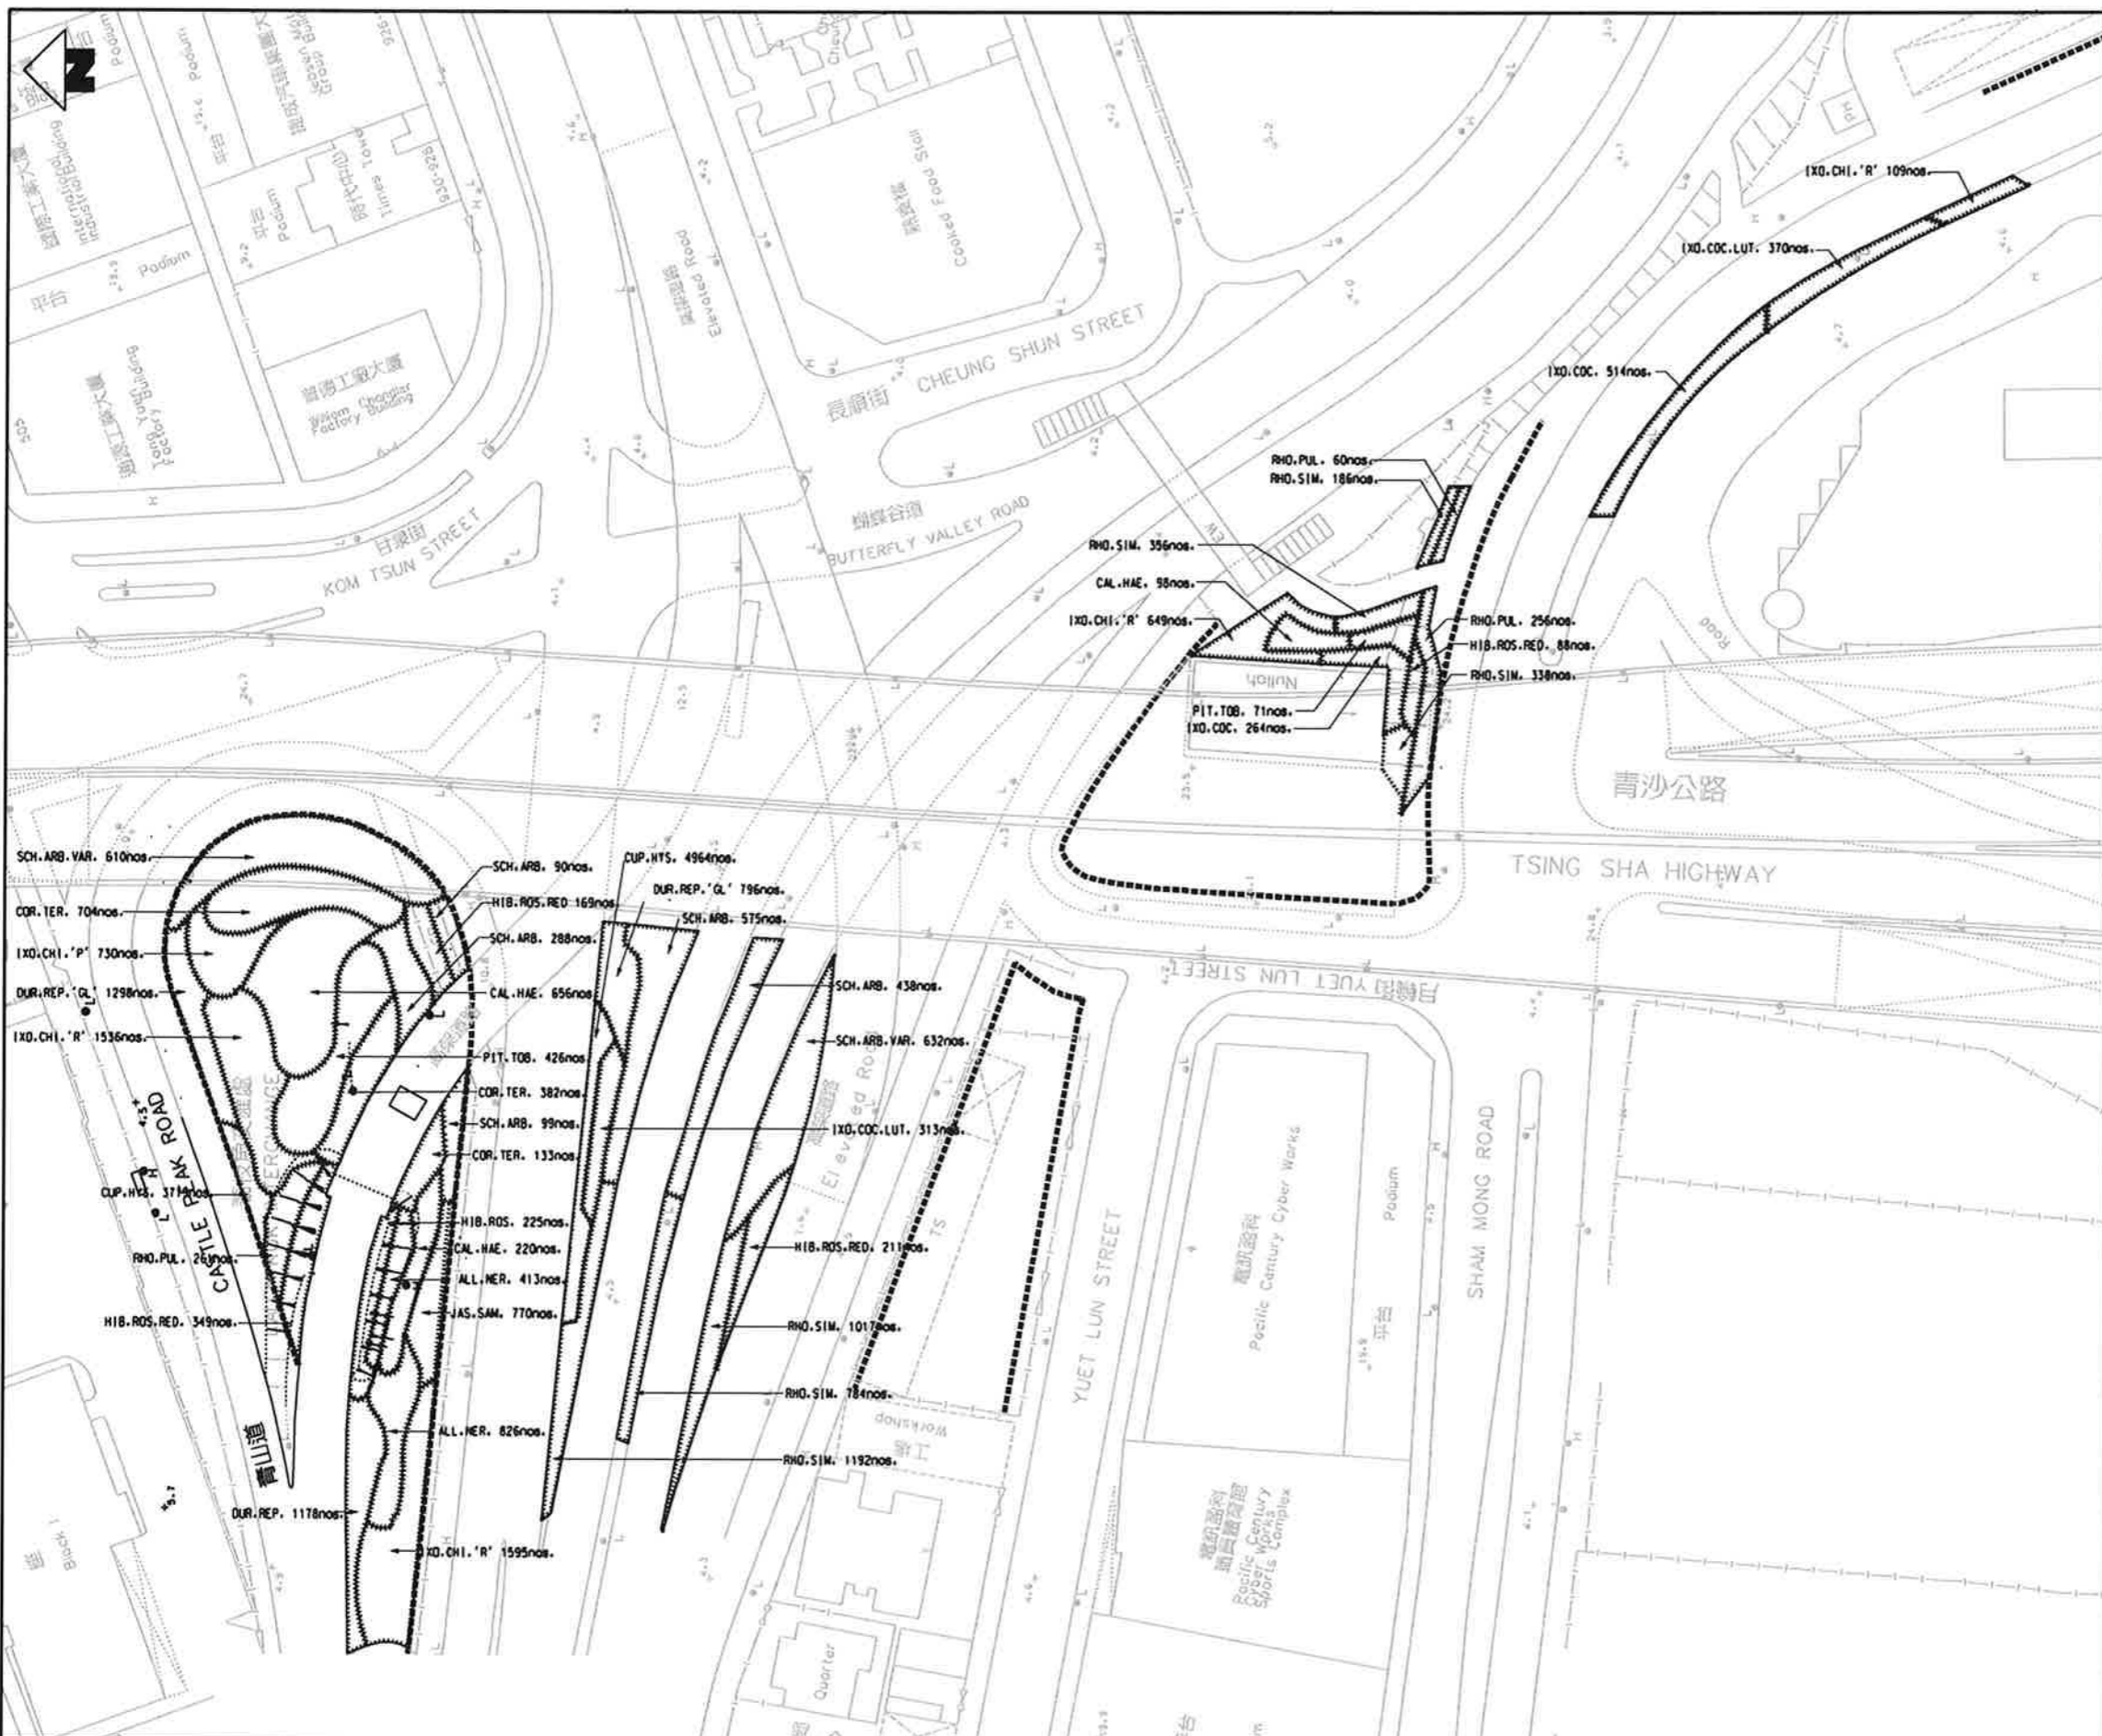


KEY PLAN SCALE 1:5000

 
- LEGEND**
- SHRUB
 - GROUND COVER



				<table border="1" style="width: 100%; border-collapse: collapse;"> <tr><td>DRAWN</td><td>SK</td></tr> <tr><td>DESIGNED</td><td>AC</td></tr> <tr><td>CHECKED</td><td>KN</td></tr> <tr><td>APPROVED</td><td>TN</td></tr> <tr><td>DATE</td><td>30/NOV/09</td></tr> </table>		DRAWN	SK	DESIGNED	AC	CHECKED	KN	APPROVED	TN	DATE	30/NOV/09	<p>EXPRESS RAIL LINK</p>		<p>CONTRACT 820 MEI LAI ROAD TO HOI TING ROAD TUNNELS SHAM SHUI PO DISTRICT PLANTING PLAN (SHEET 9 OF 11)</p>	
DRAWN	SK																		
DESIGNED	AC																		
CHECKED	KN																		
APPROVED	TN																		
DATE	30/NOV/09																		
				<p>ORIGINATOR</p> <p>ATKINS Supported by Arup, TFP, Farrells, DLS Kenneth Ng</p>		<p>SCALE 1 : 500 (A1)</p>													
<p>A TENDER ADDENDUM NO.2</p>				<p>AC 30NOV09 TM</p>		<p>DRAWING NO. 820/T/380/ATK/A58/888</p>		<p>REV. A</p>											
REV	DESCRIPTION	BY	DATE	APPROVED	REV	DESCRIPTION	BY	DATE	APPROVED	CAO REF.	820_T_380_ATK_A58_888A.dgn								

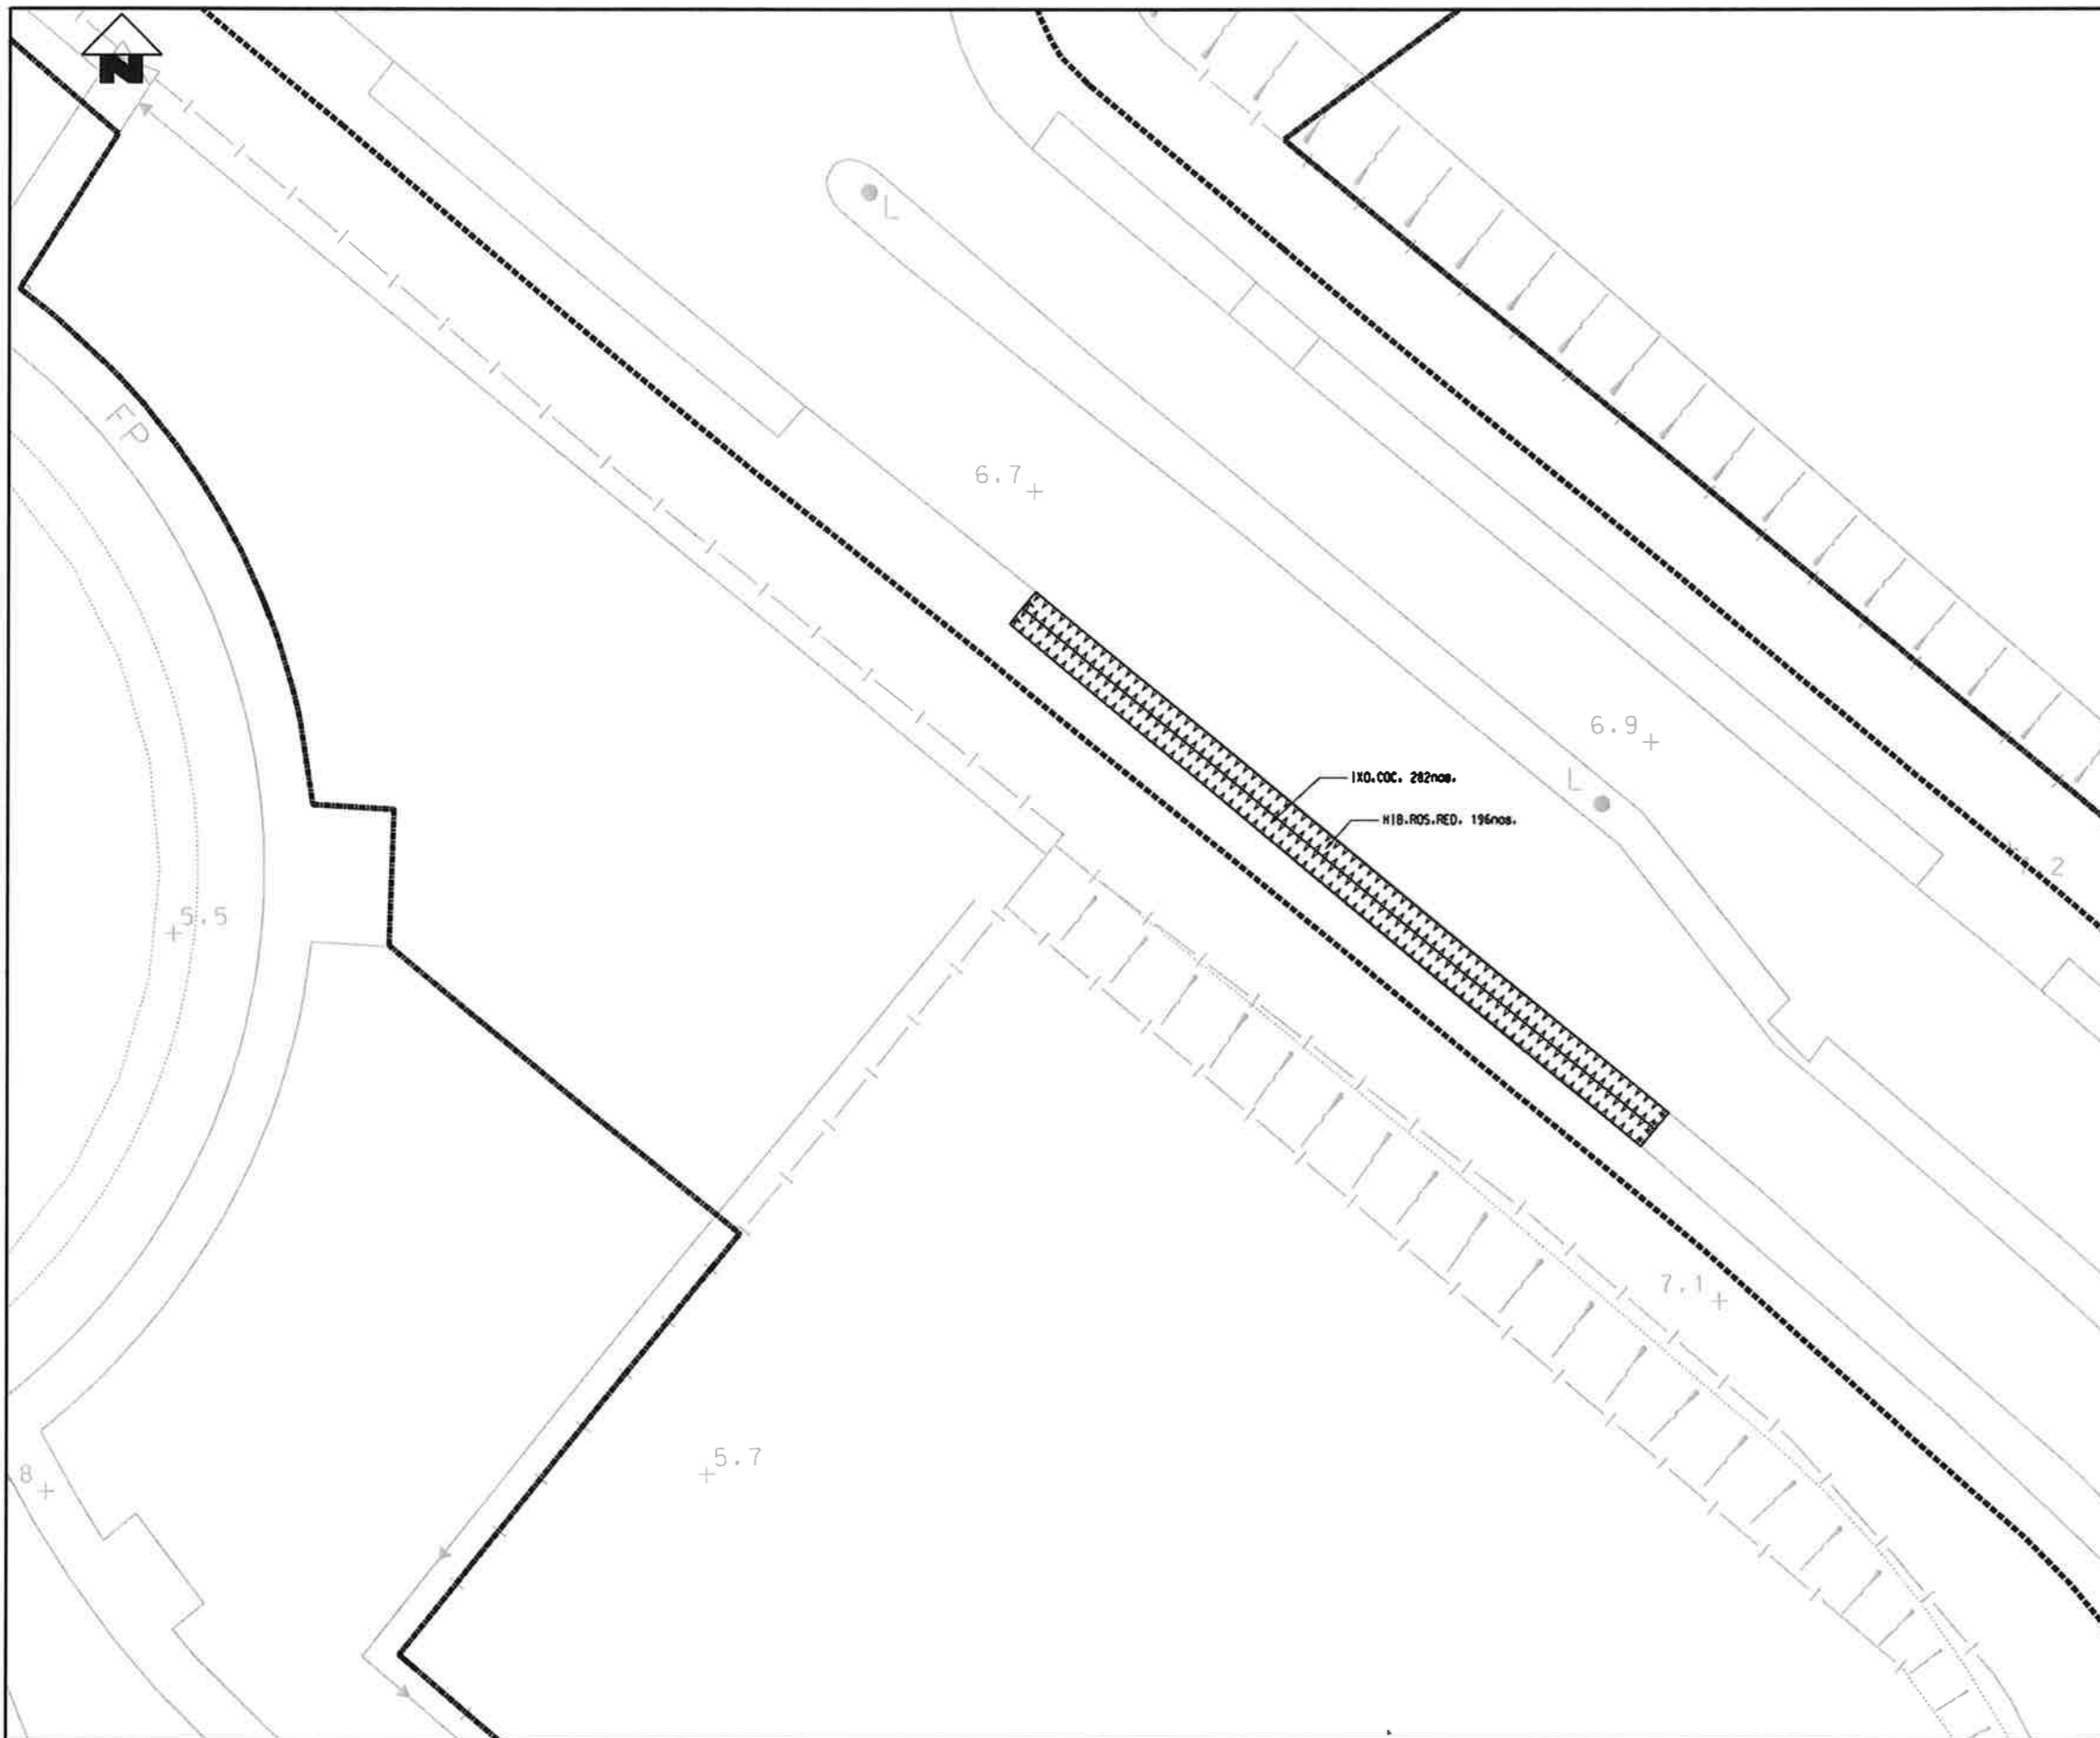

NOTES: FOR GENERAL LEGEND REFER TO
DWG. NO. 820/T/MCV/ATK/A58/801

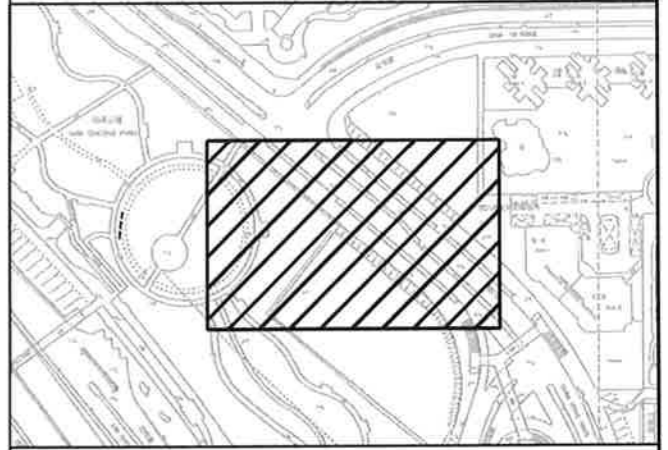


KEY PLAN SCALE 1:5000


LEGEND



 SHURB



GROUND COVER

 

REV	DESCRIPTION	BY	DATE	APPROVED	REV	DESCRIPTION	BY	DATE	APPROVED
					A	TENDER ADDENDUM NO.2	AC	30/NOV/09	TM

DRAWN	SK
DESIGNED	AC
CHECKED	KN
APPROVED	TM
DATE	30/NOV/2009

ORIGINATOR	ATKINS	Supported by Arup, TFP, Farrells, DLS Kenneth Ng
CADD REF.	821_T_370_ATK_A58_889A.dgn	

TITLE	CONTRACT 820 MEI LAI ROAD TO HOI TING ROAD TUNNELS SHAM SHUI PD DISTRICT PLANTING PLAN (SHEET 10 OF 11)		
SCALE	1 : 200 (A1)	DRAWING NO.	820/T/380/ATK/A58/889
REV.			A


Type	Botanical Name	Chinese Name	Standard	Spacing	Remarks	Quantity
SHRUB						
ALL.MER.	ALLAMANDA NERIFOLIA	...	450H X 400S	400	CONTAINER GROWN	3843
CAL.HAE.	CALLIANDRA HAEMATOCEPHALA	...	600H X 500S	700	CONTAINER GROWN	2020
COR.TER.	CORDYLINE TERMINALIS	...	500H X 500S	600	CONTAINER GROWN	1656
DUR.REP."GL"	DURANTA REPER "GOLDEN LEAVE"	...	300H X 300S	350	CONTAINER GROWN	5426
HTB.ROS.RED.	HYDRANGEA ROSA-SINENSIS "RED"	...	500H X 500S	600	CONTAINER GROWN	1361
TXD.CHI."P"	TXORA CHINENSIS "PINK"	...	600H X 350S	400	CONTAINER GROWN	1657
TXD.CHI."R"	TXORA CHINENSIS "RED"	...	600H X 350S	400	CONTAINER GROWN	5450
TXD.COC.	TXORA COCCINEA	...	500H X 450S	500	CONTAINER GROWN	2020
TXD.COC.LUT.	TXORA COCCINEA "LUTEA"	...	500H X 450S	500	CONTAINER GROWN	1352
JAS.SAM.	JASMINUM SAMBAC	...	300H X 350S	350	CONTAINER GROWN	1113
PIT.TOB.	PITTOSPORUM TOBIRA	...	750H X 600S	750	CONTAINER GROWN	1387
RHO.PUL.	RHODODENDRON PULCHRUM	...	600H X 500S	600	CONTAINER GROWN	2269
RHO.SIM.	RHODODENDRON SIMSII	...	400H X 350S	350	CONTAINER GROWN	6859
SCR.ARB.	SCHIFFLERIA ARBORTICOLA	...	600H X 500S	600	CONTAINER GROWN	3239
SCR.ARB.VAR.	SCHIFFLERIA ARBORTICOLA VARIEGATA	...	600H X 500S	600	CONTAINER GROWN	1854
GROUND COVER						
ASP.SPR.	ASPARGUS SPRENGERI	...	250H X 200S	300	CONTAINER GROWN	2457
CUP.HYS.	CUPHEA HYSSOPIFOLIA	...	200H X 150S	150	CONTAINER GROWN	5468
LAR.MIS.	LANTANA MISTA	...	200H X 250S	250	CONTAINER GROWN	4822

				DRAWN: SK DESIGNED: AC CHECKED: KN APPROVED: TM DATE: 30/NOV/09				EXPRESS RAIL LINK		ATKINS		Supported by Arup, TFP, Farrells, DLS Kenneth Ng		TITLE CONTRACT 820 MEI LAI ROAD TO HOI TING ROAD TUNNELS SHAM SHUI PO DISTRICT PLANTING PLAN (SHEET 11 OF 11)	
A TENDER ADDENDUM NO.2				AC	SONOVOS	TM	CADD REF: 820_T_380_ATK_A58_890A.dgn		SCALE: NTS		DRAWING NO: 820/T/380/ATK/A58/890		REV: A		


Maps reproduced with permission of the Director of Lands. © Hong Kong Government

PRINTED BY: USER# 2009/1/17 10:06:52

MODEL# BFL#

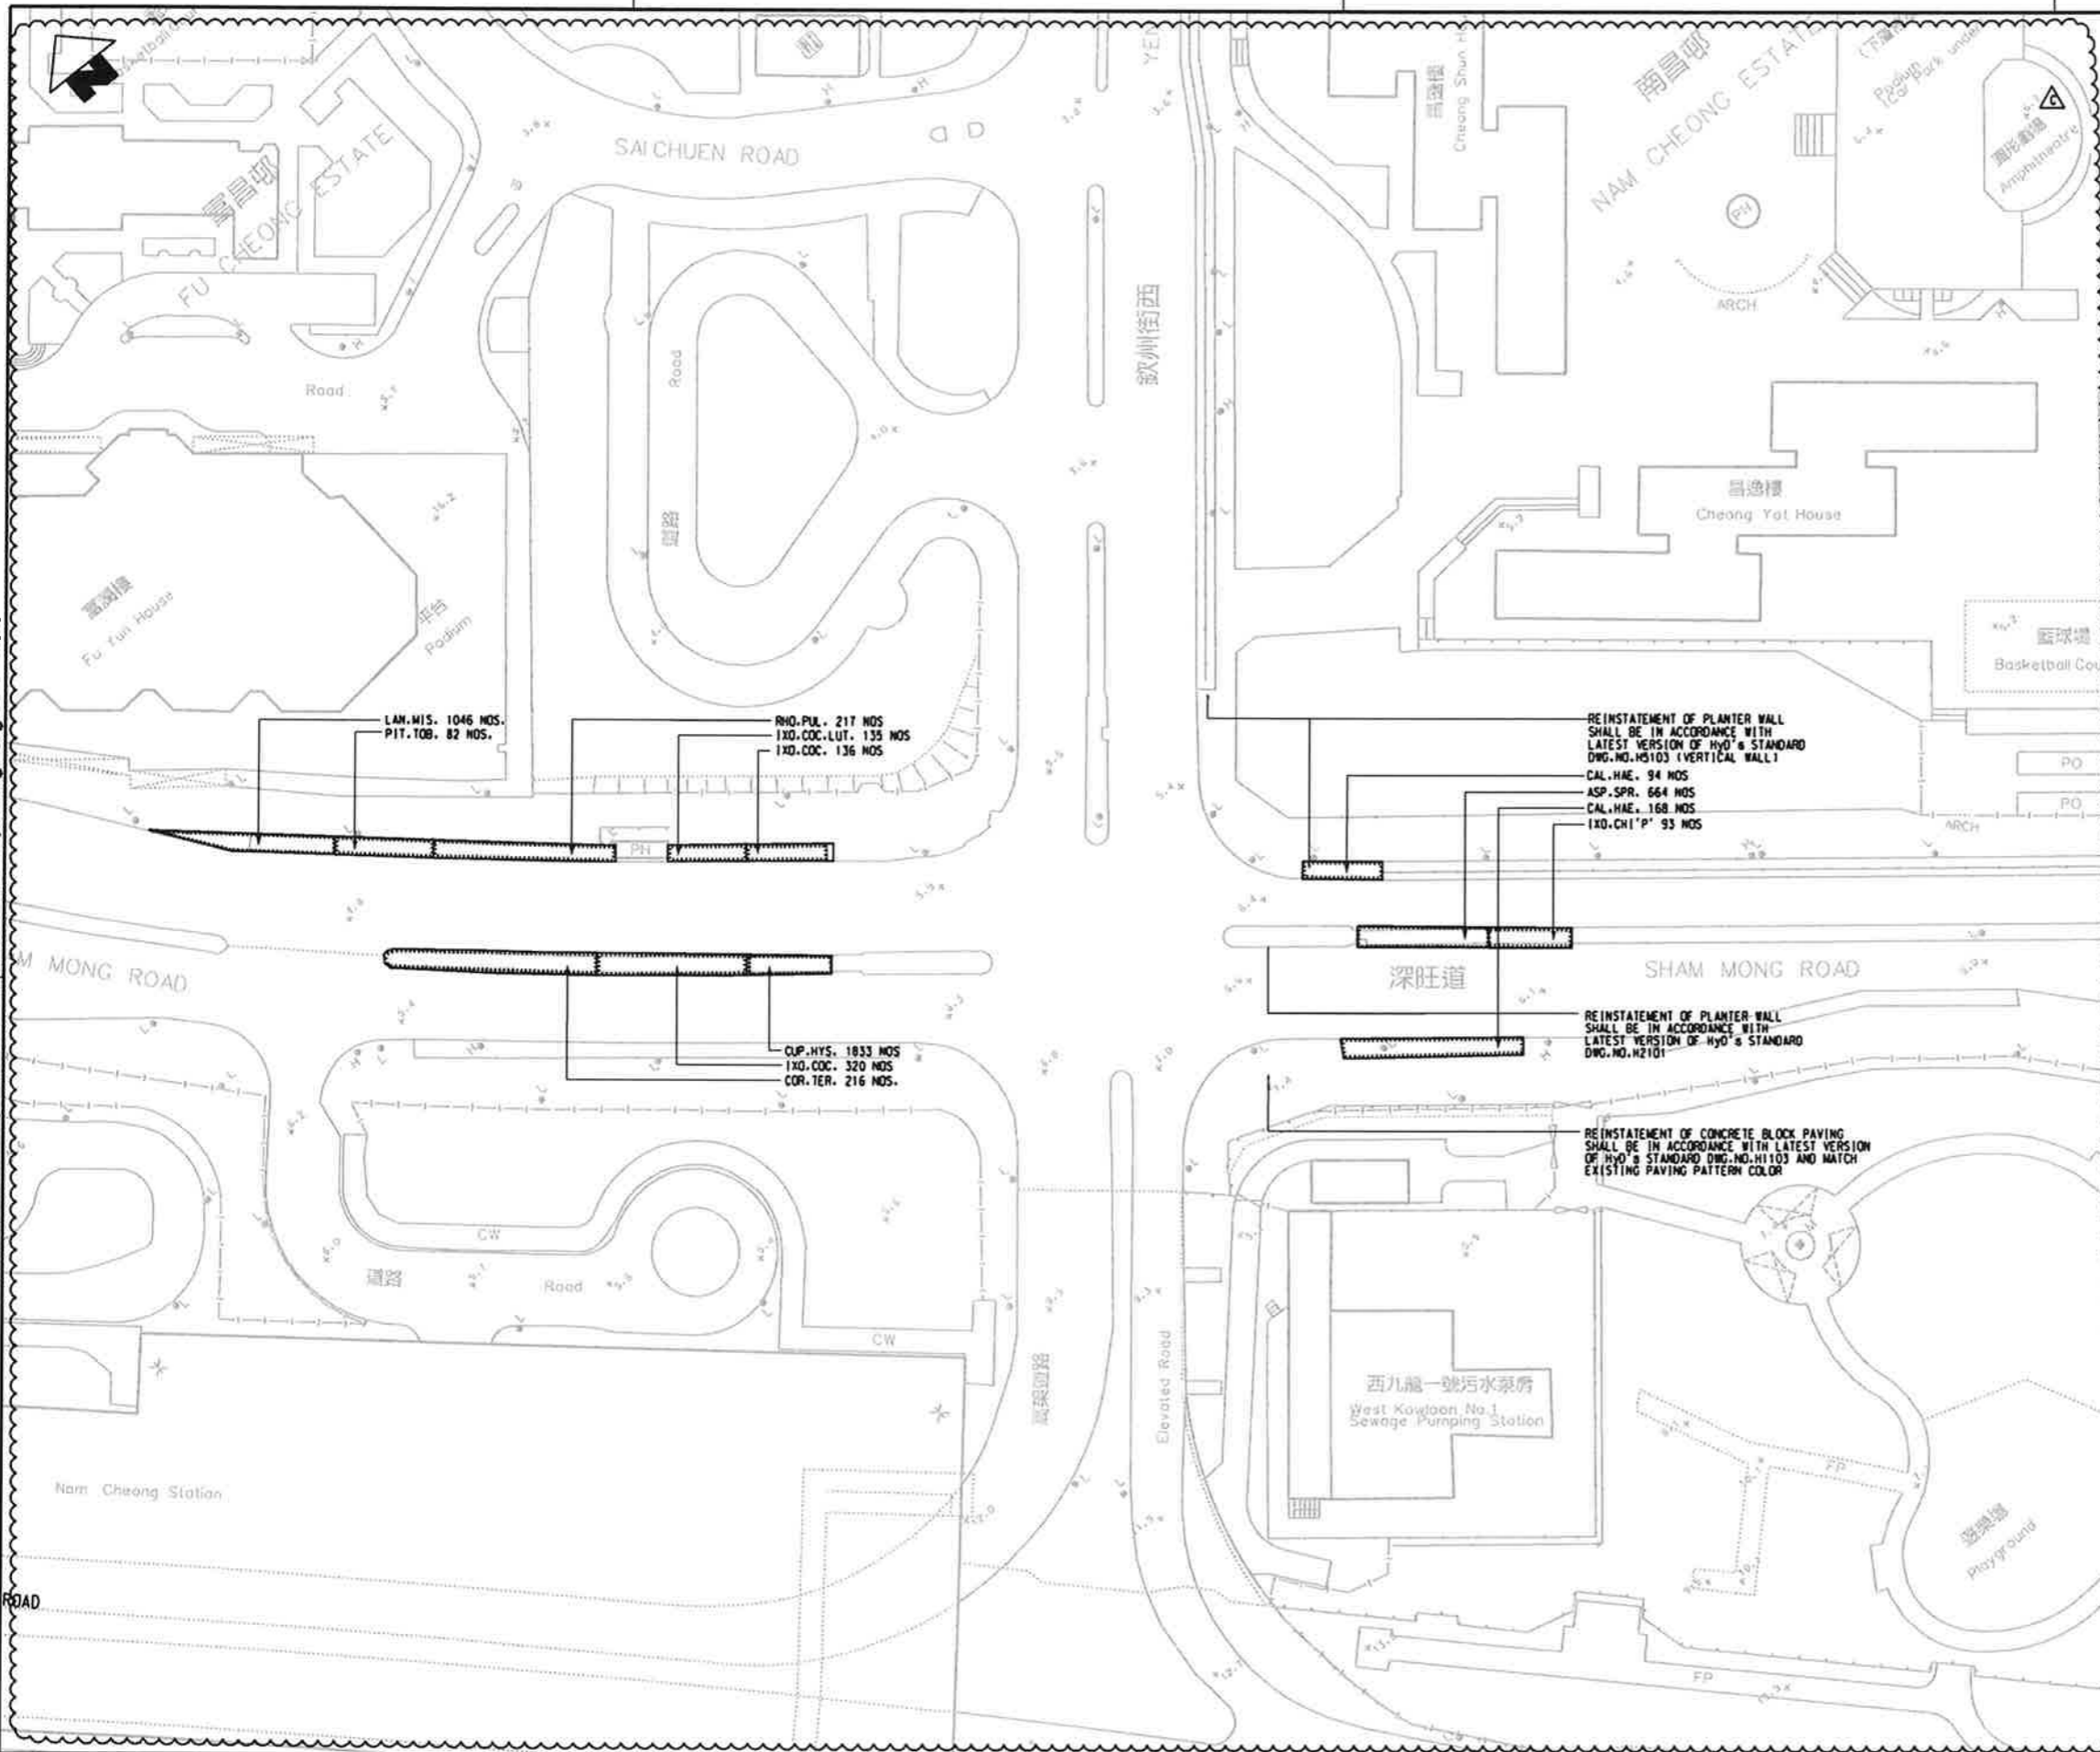


NOTES:
FOR GENERAL NOTE, REFER TO DWG. NO. 820/T/NCV/ATK/A58/800
LEGEND:
FOR GENERAL LEGEND, REFER TO DWG. NO. 820/T/NCV/ATK/A58/801

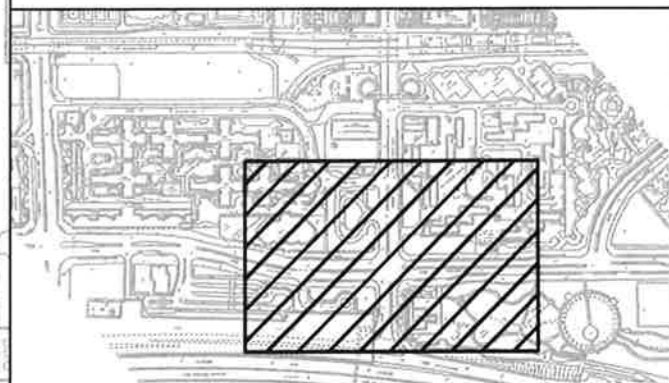

KEY LOCATION PLAN SCALE 1 : 5000

TYPE	BOTANICAL NAME	CHINESE NAME	STANDARD	SPA-CING	REMARKS	QUANTITY
種類	學名	中文名稱	規格	種植深度	註	數量
SHRUB 灌木類						
CALL.HAE	CALLIANDRA HAEMATOCEPHALA	紅絨球	600HX500S	700 mm	CONTAINER GROWN	262
COR.TER.	CORDYLINA TERMINALIS	珊瑚	900HX500S	600 mm	CONTAINER GROWN	314
IXO.COC.	IXORA COCCINEA	佛紅雞絲花	500HX450S	500 mm	CONTAINER GROWN	456
IXO.COC.LUT	IXORA COCCINEA 'LUTEA'	佛紅雞絲花	500HX450S	500 mm	CONTAINER GROWN	135
IXO.CHI.'P'	IXORA CHINENSIS 'PINK'	雞絲花 (粉紅)	600HX350S	400 mm	CONTAINER GROWN	93
PIT.TOB.	PITTOSPORUM TOBIRA	海桐花	750HX600S	750 mm	CONTAINER GROWN	82
RHO.PUL.	RHO.DENDRON PULCHRUM	雲牡丹	600HX500S	600 mm	CONTAINER GROWN	217
GROUND COVER 地被類						
ASP.SPR.	ASPARAGUS SPRENGERI	天冬	250HX400S	300 mm	CONTAINER GROWN	664
CUP.HYS.	CUPHEA HYSSOIFOLIA	香茅	200HX150S	150 mm	CONTAINER GROWN	1833
LAN.WIS.	LANTANA MISTA	黃馬蹄丹	200HX250S	250 mm	CONTAINER GROWN	1046

 

REV	DESCRIPTION	BY	DATE	APPROVED	REV	DESCRIPTION	BY	DATE	APPROVED
C	TENDER ADDENDUM NO.2	TT	30NOV09	TM					
B	TENDER ADDENDUM NO.1	TT	30OCT09	TM					
A	TENDER ISSUE	AC	11SEP09	TM					

DRAWN AC
DESIGNED AC
CHECKED KN
APPROVED TM

DATE 11/SEP/2009

ORIGINATOR
ATKINS Supported by Arup, TFP Farrells, DLS Kenneth Ng


CADD REF. 820.T.380.ATK.A58.829C.DGN

MTR


EXPRESS RAIL LINK

CONTRACT 820
MEI LAI ROAD TO HOI TING ROAD TUNNELS
PLANTING PLAN
DSD CULVERT YC2 WORKS AREA

SCALE 1 : 500 (A1)
DRAWING NO. 820/T/380/ATK/A58/829
REV. C

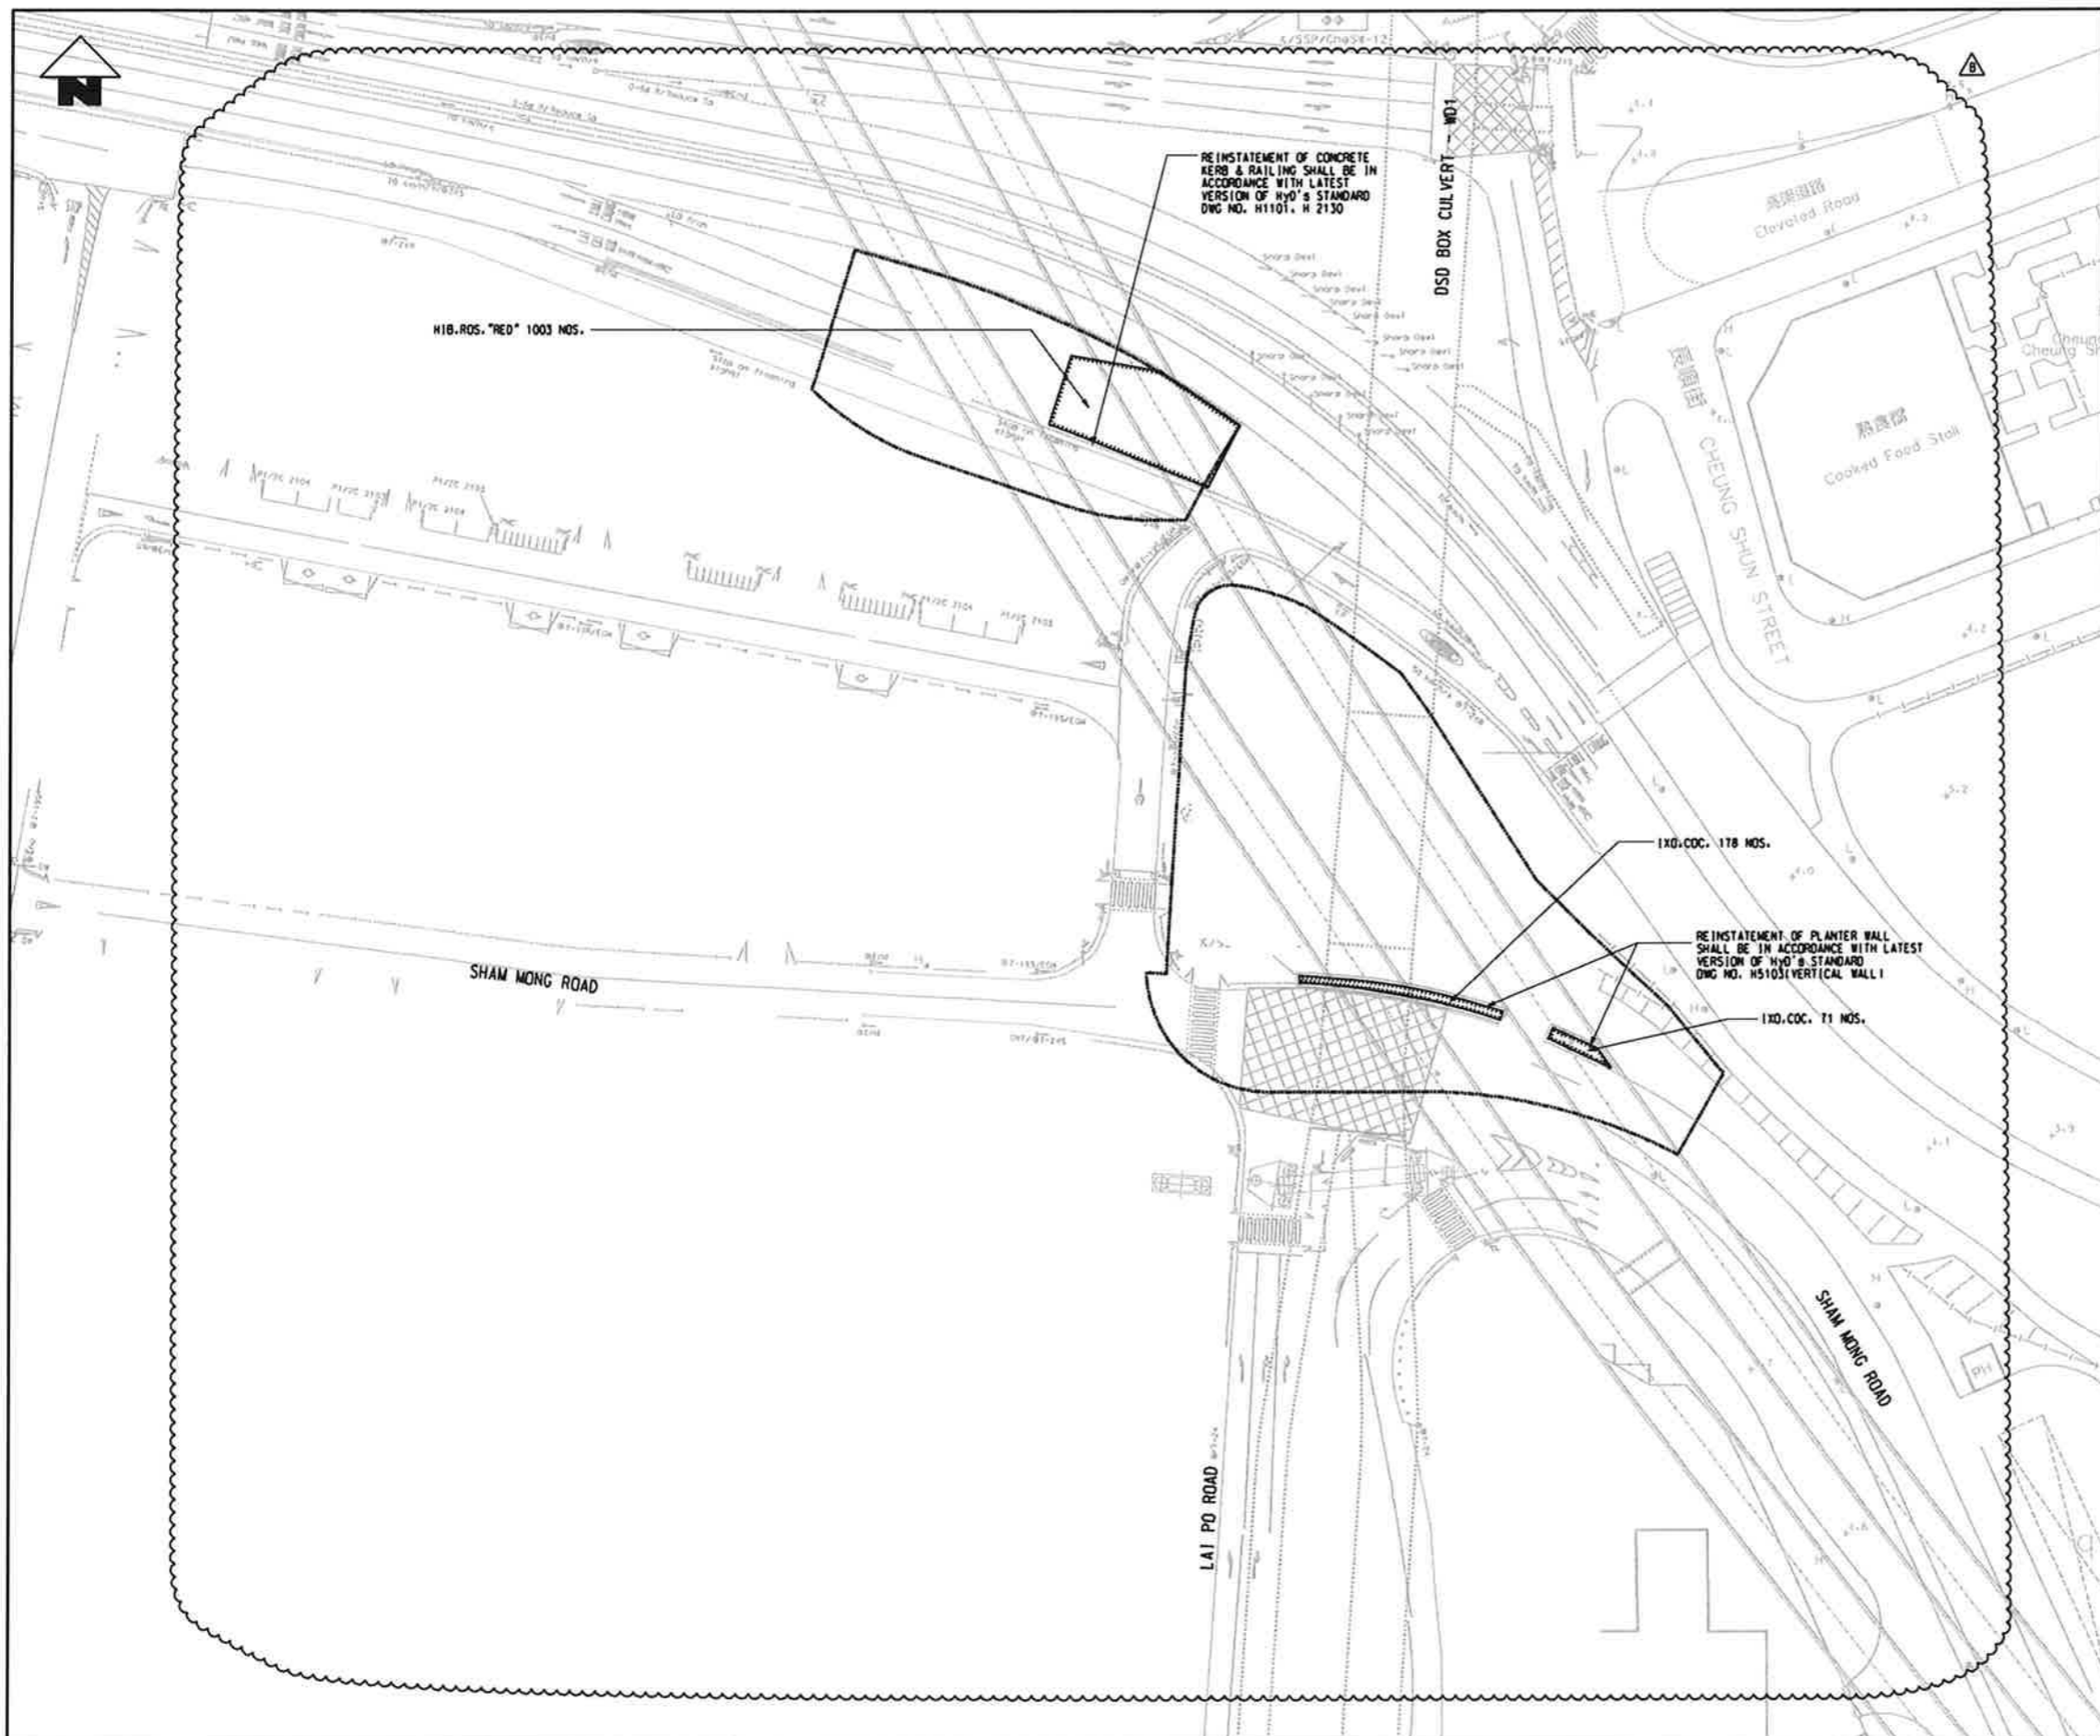


NOTES:
FOR GENERAL NOTE, REFER TO DWG. NO. 822/T/380/ATK/A58/800
LEGEND:
FOR GENERAL LEGEND, REFER TO DWG. NO. 822/T/380/ATK/A58/801

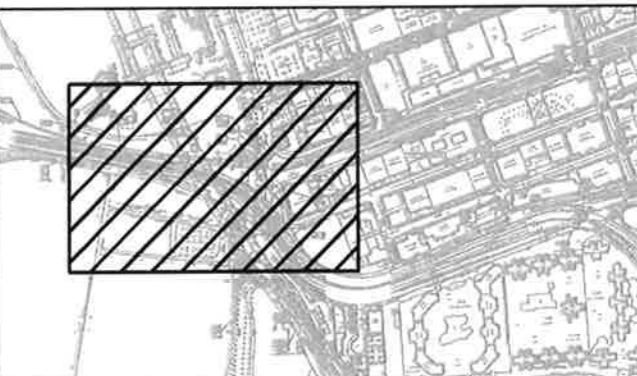

KEY LOCATION PLAN SCALE 1 : 5000

TYPE	BOTANICAL NAME	CHINESE NAME	STANDARD	SPA-CING	REMARKS	QUANTITY
種類	學名	中文名稱	規格	種植規格	註	數量
SHRUB	灌木類					
IXO. COC.	IXORA COCCINEA	樹紅地錦花	500X450S	500 mm	CONTAINER GROWN	249
HIB. ROS. 'RED'	HIBISCUS ROSA-SINENSIS 'RED'	大麗花	600X500S	600 mm	CONTAINER GROWN	1003

 


REV	DESCRIPTION	BY	DATE	APPROVED	REV	DESCRIPTION	BY	DATE	APPROVED
B	TENDER ADDENDUM NO. 2	AC	30NOV09	TM					
A	TENDER ISSUE	AC	11SEP09	TM					

DRAWN	AC
DESIGNED	AC
CHECKED	KN
APPROVED	TM
DATE	11/SEP/2009

MTR
EXPRESS RAIL LINK
ORIGINATOR
ATKINS Supported by Arup, TFP Farrells, DLS Kenneth Ng
CADD REF. 820.T_380.ATK.A58.830B.DGN


TITLE	CONTRACT 820 MEI LAI ROAD TO HOI TING ROAD TUNNELS LANDSCAPE PLAN SHAM MONG ROAD / YUET LUN STREET WORKS AREA		
SCALE	1 : 500 (A1)	DRAWING NO.	820/T/380/ATK/A58/830
REV.	B		

maps reproduced with permission of the Director of Land, & Housing Government

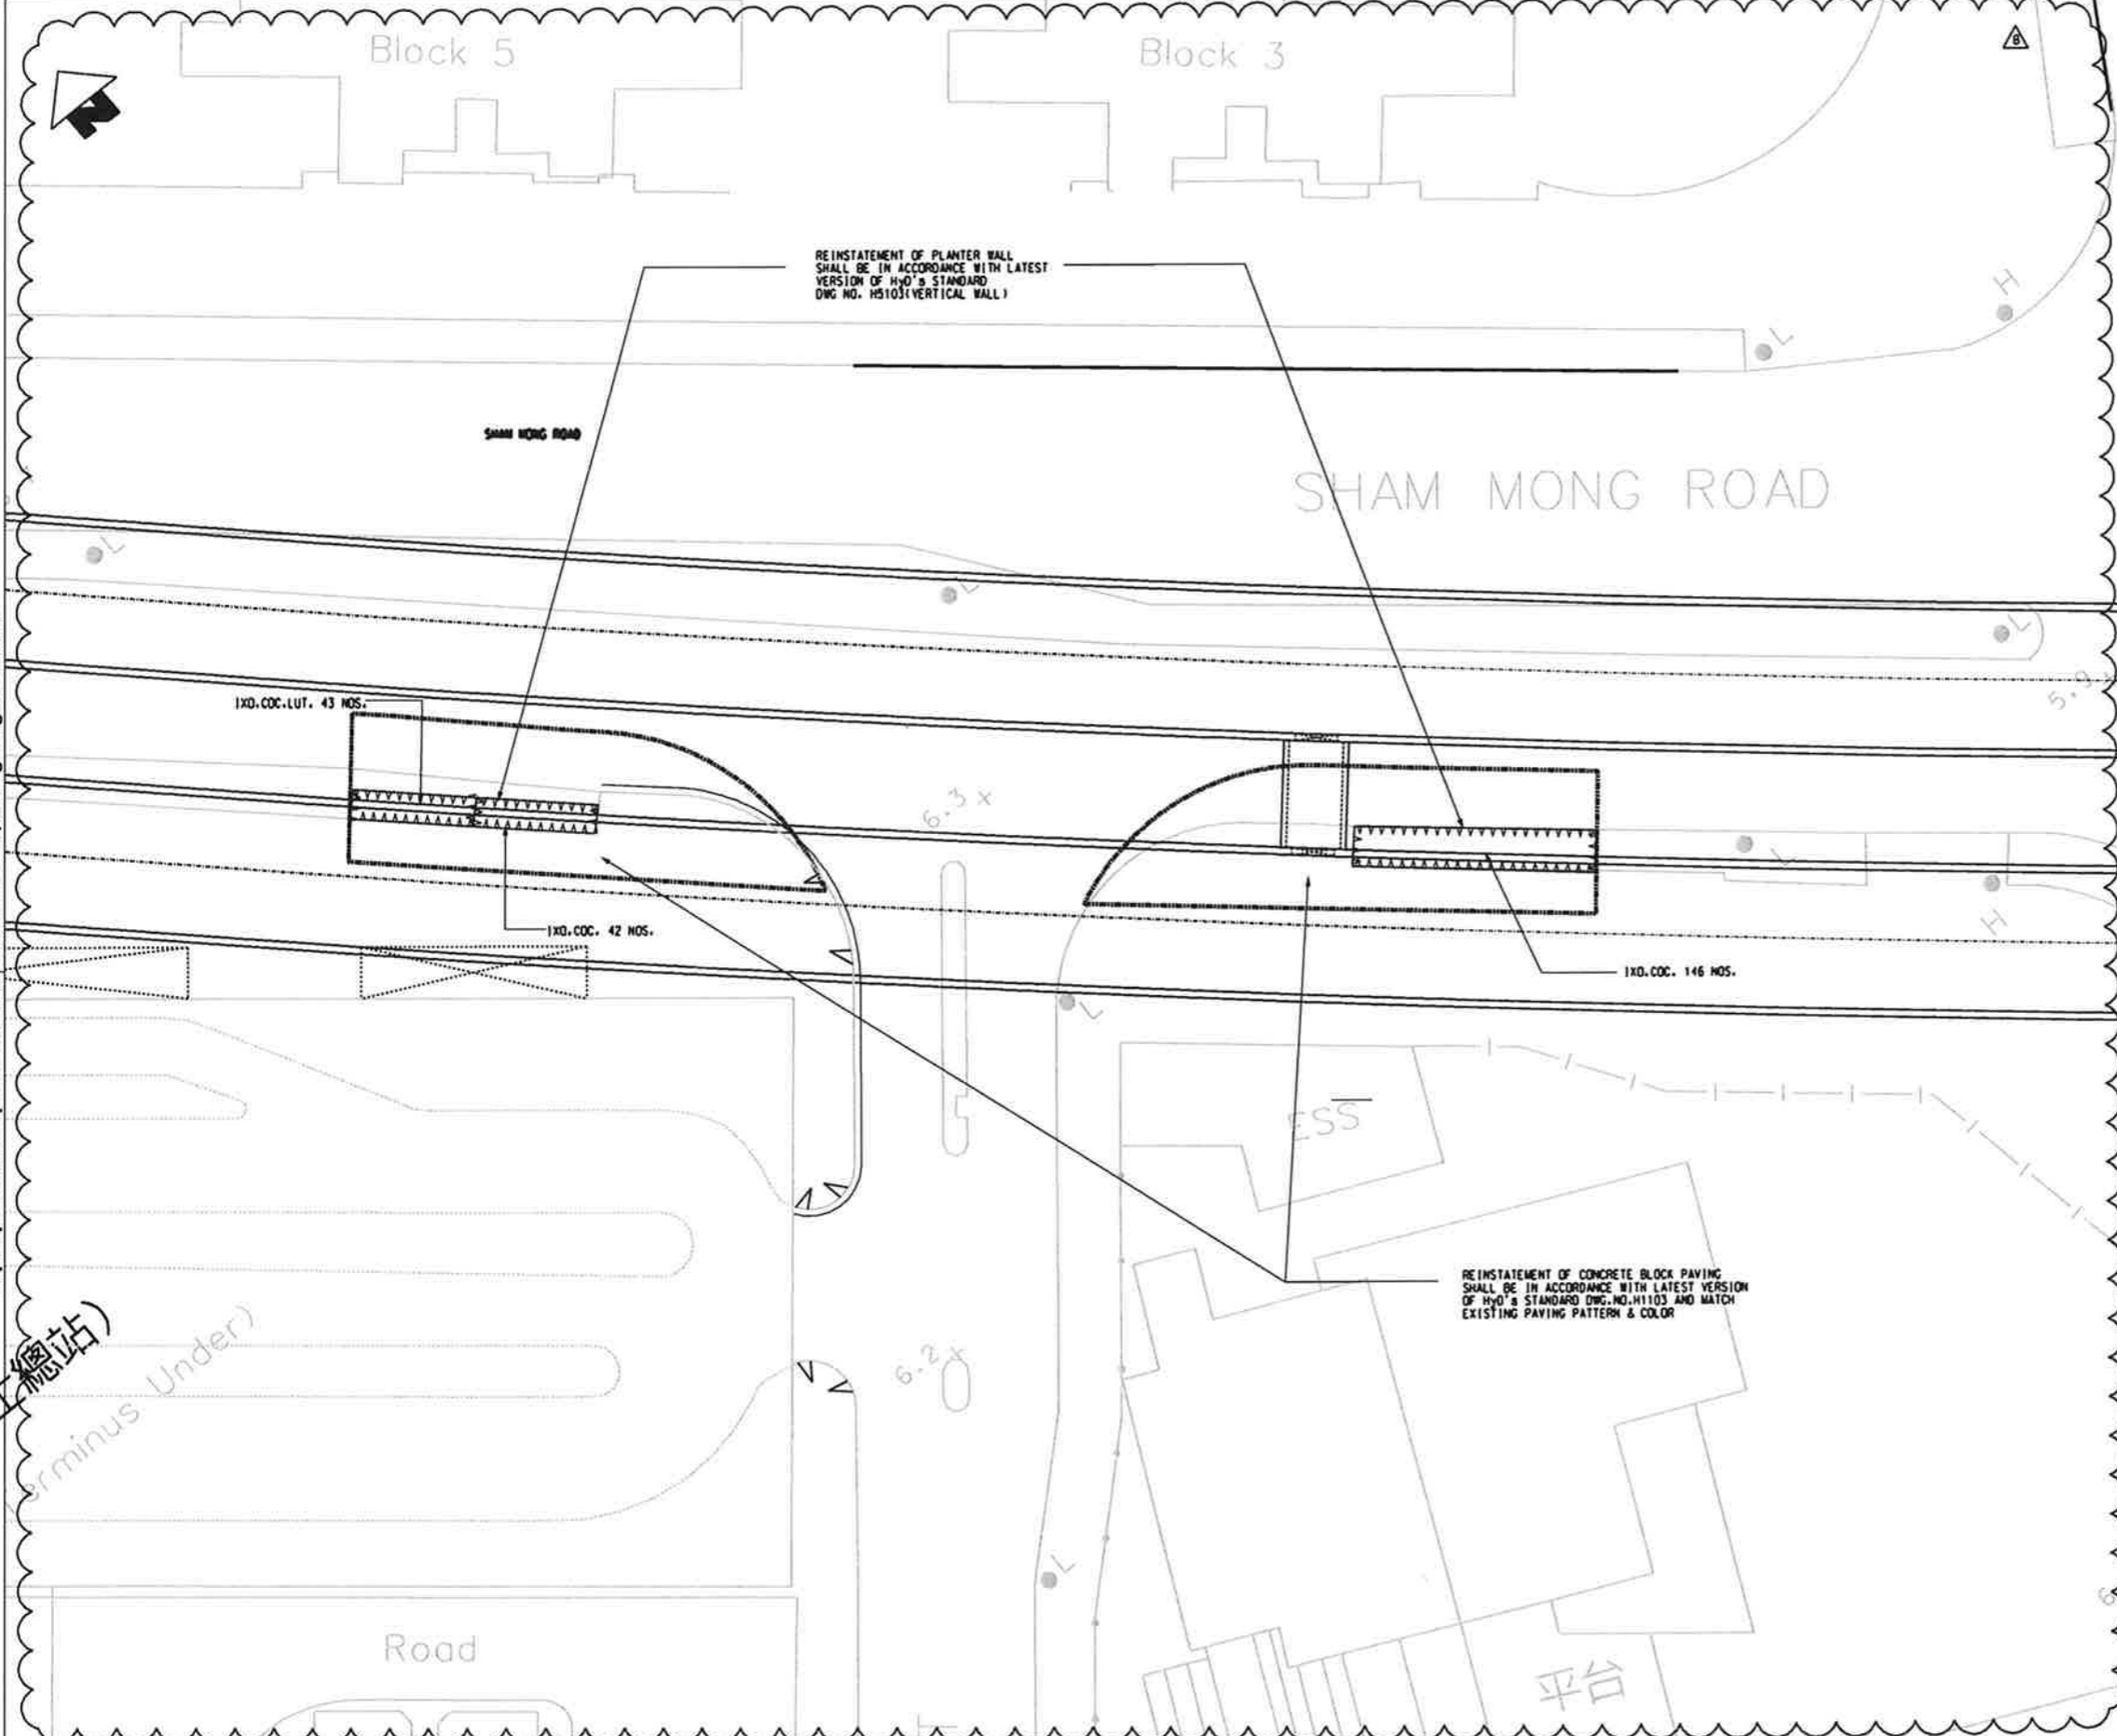


NOTES:
FOR GENERAL NOTE, REFER TO DWG. NO. 822/T/380/ATK/A58/800

LEGEND:
FOR GENERAL LEGEND, REFER TO DWG. NO. 822/T/380/ATK/A58/801

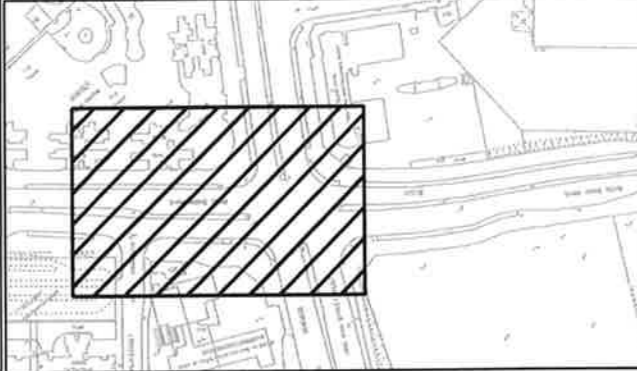

TYPE	BOTANICAL NAME	CHINESE NAME	STANDARD	SPA-CING	REMARKS	QUAN-TITY
種類	學名	中文名稱	規格	種植間距	註	數量
SHRUB	龍牙木					
1XO.COC.	IXORA COCCINEA	樹紅龍船花	500X450S	500 mm	CONTAINER GROWN	146
1XO.COC.LUT	IXORA COCCINEA 'LUTEA'	黃花龍船花	500X450S	500 mm	CONTAINER GROWN	43

 

(車站)
Terminus Under

REV	DESCRIPTION	BY	DATE	APPROVED	REV	DESCRIPTION	BY	DATE	APPROVED
B	TENDER ADDENDUM NO. 1	SK	30OCT09	TM					
A	TENDER ISSUE	AC	05OCT09	TM					

DRANN	AC
DESIGNED	AC
CHECKED	KN
APPROVED	TM
DATE	11/SEP/2009

MTR

EXPRESS RAIL LINK

ORIGINATOR

ATKINS Supported by Anup, TFP, Farrells, DLS, Kenneth Ng

CADD REF. 820_T_380_ATK_A58_831B.DGN


TITLE

CONTRACT C802
MEI LAI ROAD TO HOI TING ROAD TUNNELS
LANDSCAPE PLAN
NEAR AOJA MARINE

SCALE 1:500 (A)


DRAWING NO. 820/T/380/ATK/A58/831

REV. B

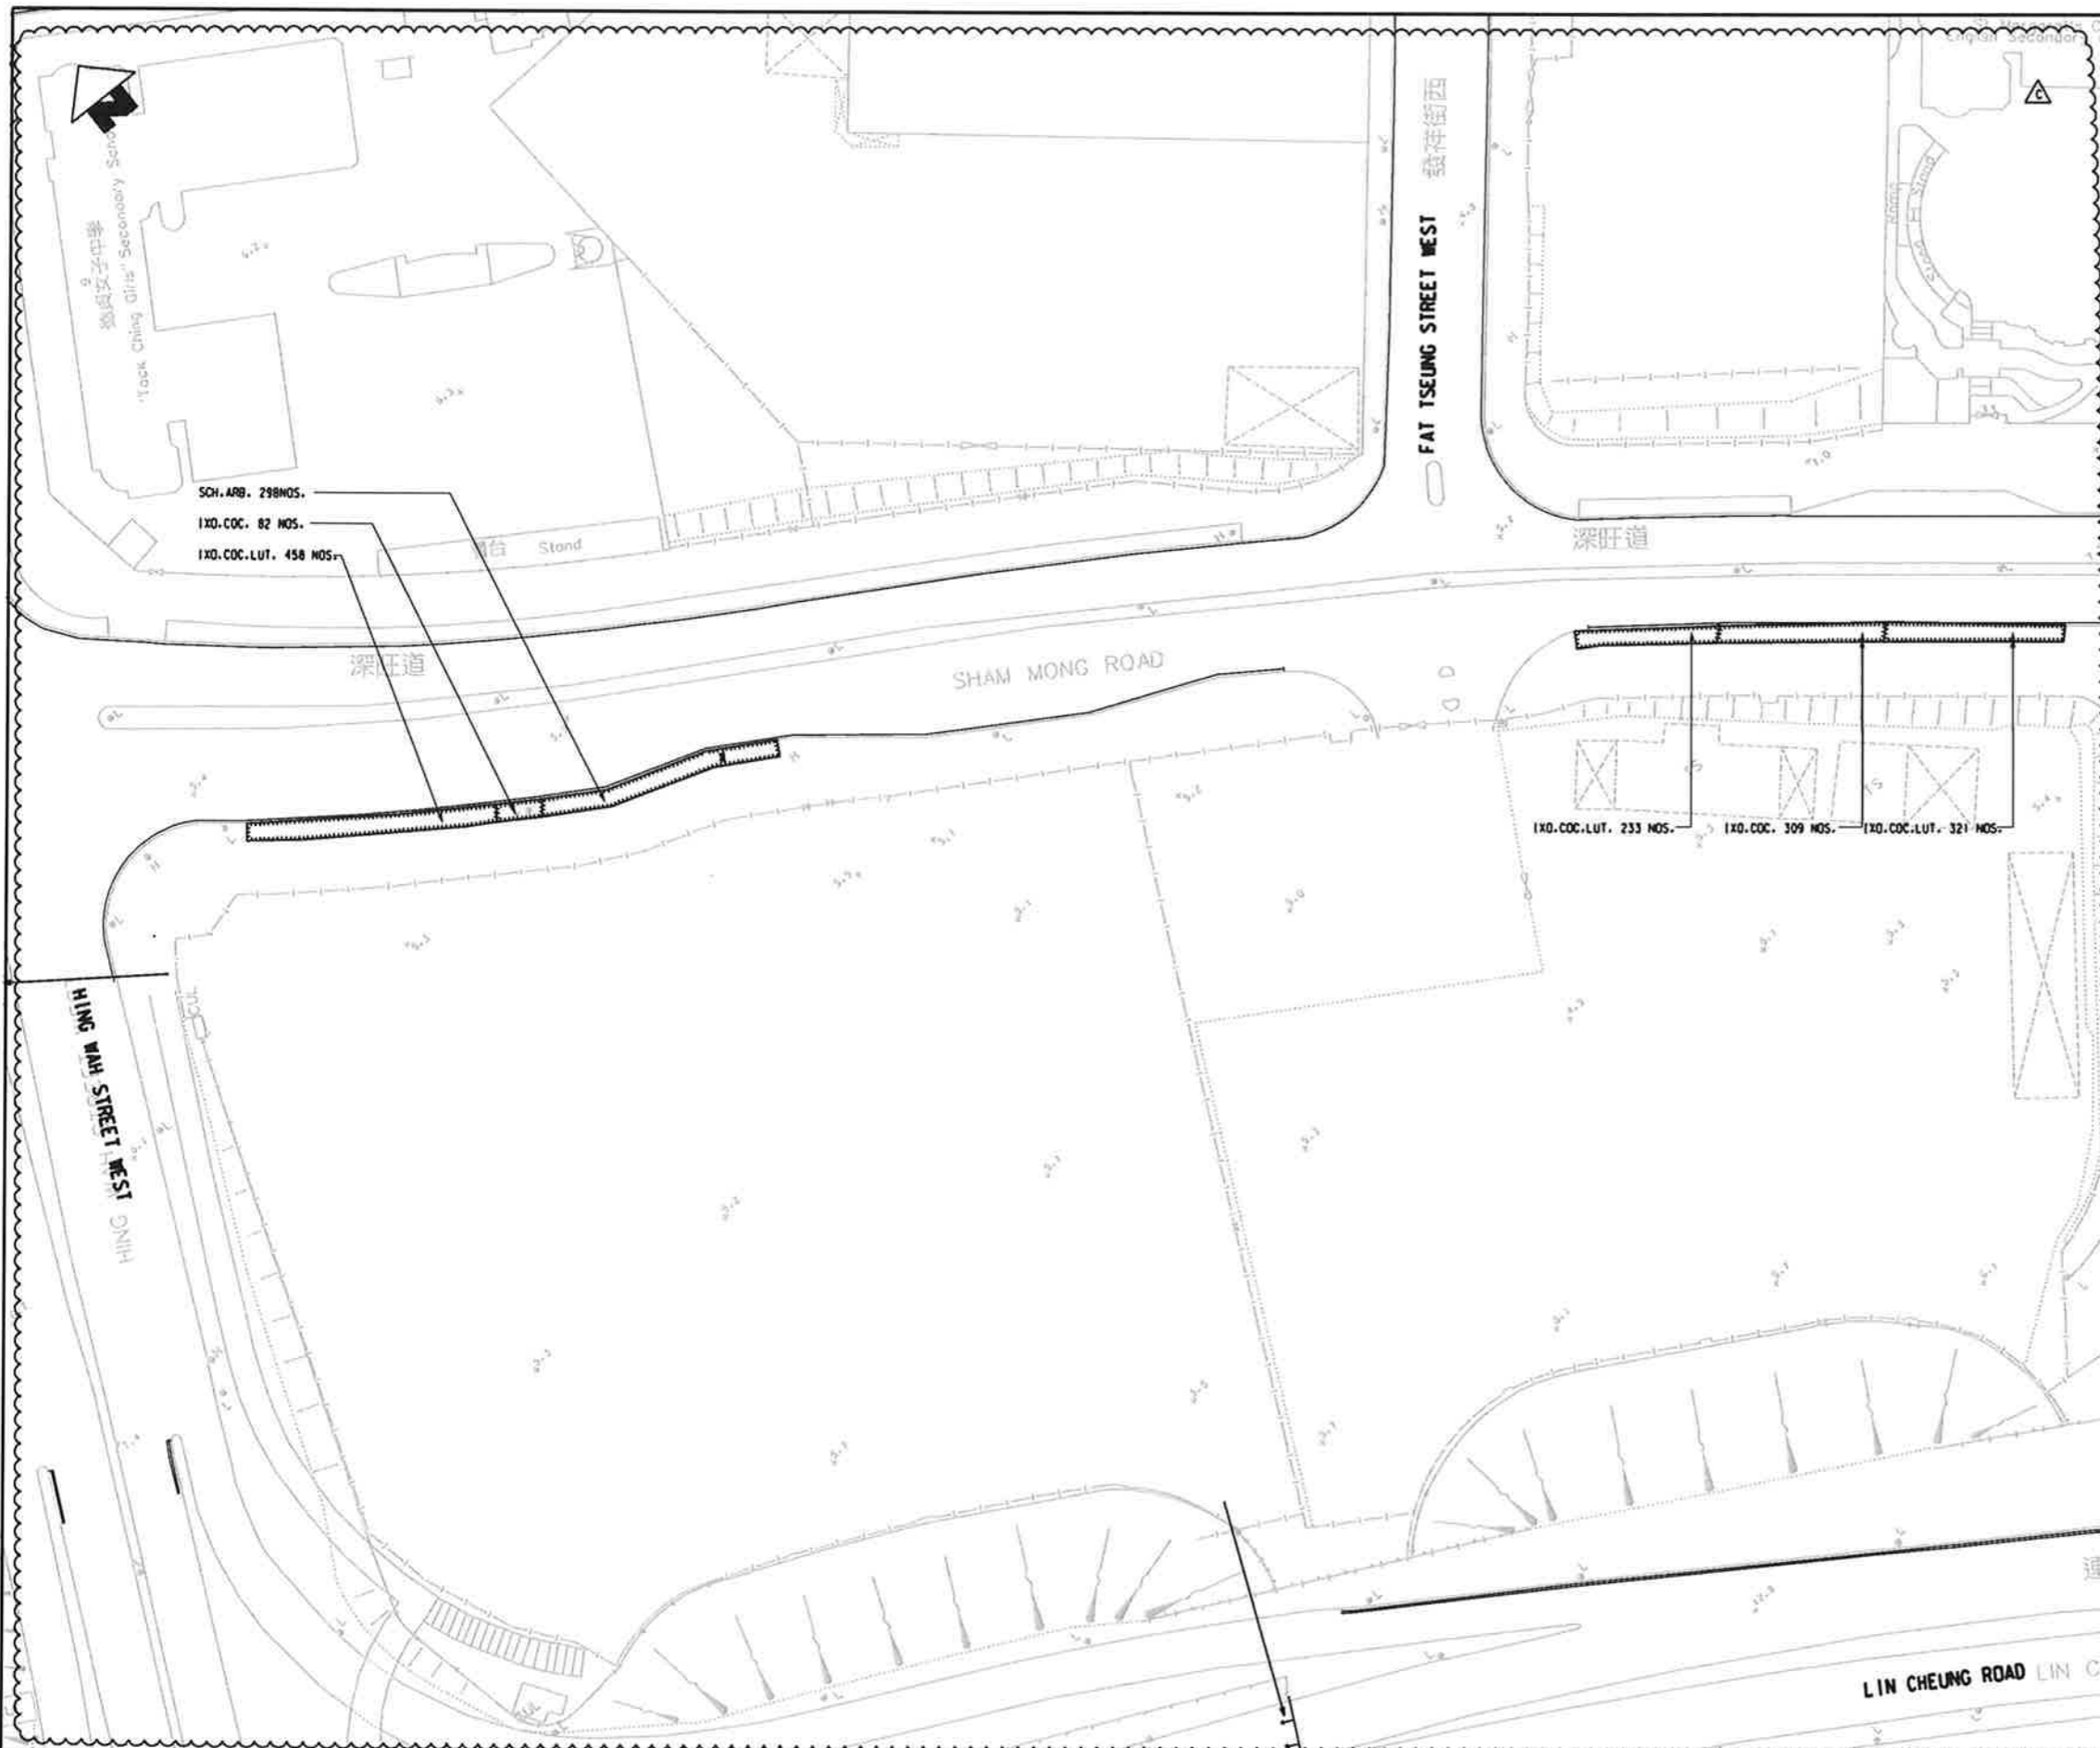


NOTES:
FOR GENERAL NOTE, REFER TO DWG. NO. 822/T/380/ATK/A58/800

LEGEND:
FOR GENERAL LEGEND, REFER TO DWG. NO. 822/T/380/ATK/A58/801

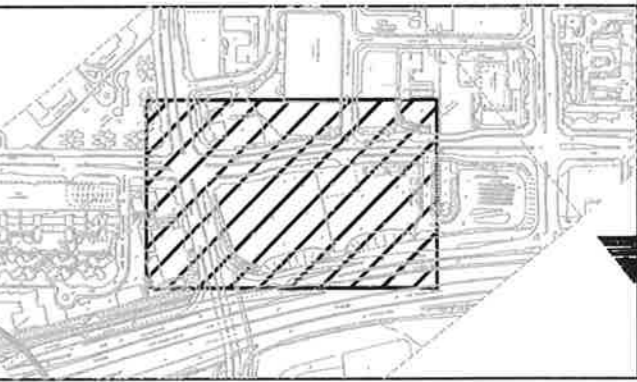

KEY LOCATION PLAN SCALE 1 : 5000

TYPE	BOTANICAL NAME	CHINESE NAME	STANDARD	SPA-CING	REMARKS	QUANTITY
種類	學名	中文名稱	規格	種植深度	註	數量
SHRUB	灌木類					
SCH.ARB.	SCHEFFLERA ARBORICOLA	八角木	600X500S	600 mm	CONTAINER GROWN	298
IXD.COC.LUT	IXORA COCCINEA 'LUTEA'	黃花地膽花	500X450S	500 mm	CONTAINER GROWN	1012
IXD.COC.	IXORA COCCINEA	珊瑚地膽花	500X450S	500 mm	CONTAINER GROWN	391

 

DRAMN	AC					
DESIGNED	AC					
CHECKED	KN					
APPROVED	TM					
C	TENDER ADDENDUM NO.2	TT	30NOV09	TM	DATE	11/SEP/2009
B	TENDER ADDENDUM NO.1	TT	30OCT09	TM		
A	TENDER ISSUE	AC	11SEP09	TM		

EXPRESS RAIL LINK

ORIGINATOR

ATKINS Supported by Arup, TFP, Farrells, DLS, Kenneth Ng

CADD REF. 820_T_380_ATK_A58_833C.DGN

TITLE

CONTRACT 820
MEI LAI ROAD TO HOI TING ROAD TUNNELS
LANDSCAPE PLAN
AT SHAM MONG ROAD
/ HING WAH STREET WEST

SCALE 1 : 500 (A1)

DRAWING NO. 820/T/380/ATK/A58/833

REV. C

ABBREVIATIONS

ASD	ARCHITECTURAL SERVICES DEPARTMENT	SS	STAINLESS STEEL
APPROX	APPROXIMATELY	SHS	SQUARE HOLLOW SECTION
CONC	CONCRETE	THK	THICK
C/S	CEMENT/SAND	TSL	TOP OF SOIL LEVEL
DIA	DIAMETER	TW	TOP OF WALL LEVEL
DN	DOWN	TYP	TYPICAL
DWG	DRAWING	UP	UP
FFL	FINISHED FLOOR LEVEL	UNO	UNLESS NOTED OTHERWISE
GA	GENERAL ARRANGEMENT	W	WIDE
GL	GRID LINE	W/	WITH
GMS	GALVANIZED MILD STEEL	XRL	EXPRESS RAIL LINK
HyD	HIGHWAY'S DEPARTMENT		
LCSO	LEISURE CULTURAL SERVICES DEPARTMENT		
MIN.	MINIMUM		
NTR	MASS TRANSIT RAILWAY		
m	METRE(S) (OR m)		
mm	MILLIMETRE(S) (OR mm)		
M & E	MECHANICAL and ELECTRICAL		
M & W	MATERIAL AND WORKMANSHIP		
mPD	LEVEL IN METRES RELATIVE TO HONGKONG PRINCIPAL DATUM		
NCV	NAM CHEONG VENTILATION BUILDING		
nos.	NUMBERS		
N.T.S.	NOT TO SCALE		
RC	REINFORCED CONCRETE		
REF	REFERENCE		
RHS	RECTANGLE HOLLOW SECTION		

NOTES

GENERAL NOTES:





 
 


 

 
 
1. GENERAL
 - 1.1 USE ONLY FIGURED DIMENSION. NO DIMENSION SHALL BE OBTAINED BY SCALING FROM DRAWINGS.
 - 1.2 ALL LEVELS INDICATED ON PLAN, SECTIONAL DWGS ARE FFL UNO.
2. HARDSCAPE
 - 2.1 FOR SPECIAL COPING AND SKIRTING DETAIL, REFER TO THE LANDSCAPE DWGS.
 - 2.2 ALL FIXING / FABRICATION DETAIL OF SPECIAL GRANITE PAVING AND FINISHES SHALL HAVE THE APPROVAL OF THE ENGINEER PRIOR TO COMMENCEMENT.
 - 2.3 FINISHES SPECIFIED IN THESE DRAWINGS ARE SUBJECT TO AVAILABILITY FROM SUPPLIER. SAMPLES TO BE FORWARDED TO THE ENGINEERS FOR APPROVAL PRIOR TO CONSTRUCTION.
 - 2.4 ALL PAVING DESIGN DETAILS, MATERIAL AND FINISHES TO BE SPECIFIED AS IN THE LANDSCAPE DRAWINGS, UNLESS NOTED OTHERWISE.
3. ARCHITECTURAL WORKS
 - 3.1 FOR WATERPROOFING OF STRUCTURAL SLAB, REFER TO GENERAL SPECIFICATION AND ARCHITECTURAL DRAWINGS.
 - 3.2 ALL LANDSCAPE FINISHED INTERFACING WITH THE ARCHITECTURAL BUILDING WORKS SHALL BE REFERRED TO ARCHITECTURAL DRAWINGS.
 - 3.3 ALL ABWF TO BE DETAILED AS IN THE ARCHITECTURAL DWGS, UNO.
4. STRUCTURAL WORKS
 - 4.1 FOR ALL STRUCTURAL WORKS AND STEEL REINFORCING SPECIFICATION, REFER TO STRUCTURAL ENGINEERS DRAWINGS.
 - 4.2 FOR CONCRETE STRENGTH AND MORTAR MIX, REFER TO M & W SPECIFICATION.
5. ELECTRICAL
 - 5.1 FOR ALL ELECTRICAL WORKS INCLUDING PROVISIONS FOR ELECTRICAL CONDUIT, CONNECTION BOXES AND ANY OTHER ADDITIONAL ELECTRICAL ITEMS, REFER TO THE E&M DRAWINGS.
 - 5.2 FOR ALL LANDSCAPE LIGHTING FIXTURES, REFER TO THE LANDSCAPE DRAWINGS UNO.
6. DRAINAGE
 - 6.1 FOR ALL PAVED DECK, DRAINAGE, CLOSED BOTTOM PLANTER DRAINAGE REFER TO DRAWINGS.
 - 6.2 FOR ALL DRAINAGE RUN AND CATCHMENT DETAILS, REFER TO DRAWINGS.
 - 6.3 FALL DIRECTION TO BE MATCHED WITH EXISTING LEVEL AND PROPOSED ROAD WORK LEVEL.
7. MATERIALS AND FINISHES
 - 7.1 FOR LANDSCAPE MATERIALS AND FINISHES, CONTRACTOR SHALL SUBMIT SAMPLE FOR ENGINEERS APPROVAL.
 - 7.2 SELECTED ALTERNATIVE MATERIALS AND FINISHES SHALL BE SUBJECT TO FINAL APPROVAL BY THE ENGINEER.
 - 7.3 ALL WOOD TO BE STRAIGHT AND TO BE TREATED WITH MINIMUM TWO TIMES CLEAR UNDERCOATS AND THREE TIMES FINISH COATS.
 - 7.4 ALL HARDWARE AND FASTENERS TO BE STAINLESS STEEL GRADE 316.
 - 7.5 ALL PAVER INCLUDING COLOUR, SIZE, AND TEXTURE TO BE MATCHED WITH EXISTING SITE CONDITION WITHIN HYD'S AREA. CONTRACTOR SHOULD SUBMIT SAMPLE PRIOR TO CONSTRUCTION.
8. FABRICATION WORKS
 - 8.1 FOR ALL METAL AND STEEL FABRICATION WORK REFERRED TO IN THESE DRAWINGS, SHOP DRAWINGS SHALL BE SUBMITTED FOR ENGINEER'S REVIEW. A SAMPLE FOR THE WORK WHERE REQUIRED SHALL BE FORWARDED TO THE ENGINEERS FOR FINAL APPROVAL.
9. SOFTSCAPE
 - 9.1 ALL RETAINED TREE SHALL BE RETAINED ON SITE WITH PROPER PROTECTION AS PER PARTICULAR SPECIFICATION FOR TREE.
 - 9.2 ALL PLANTING WORKS SHALL REFER TO PARTICULAR SPECIFICATION.

Maps reproduced with permission of the Director of Lands, © Hong Kong Government


 
 



 
 


PLOT DWN: 2009/00/19 4:58:56 2009/00/19 4:58:56 082337

				<table border="1"> <tr><td>DRAWN</td><td>BEN</td></tr> <tr><td>DESIGNED</td><td>AC</td></tr> <tr><td>CHECKED</td><td>KN</td></tr> <tr><td>APPROVED</td><td>TM</td></tr> <tr><td>DATE</td><td>29/MAY/2009</td></tr> </table>				DRAWN	BEN	DESIGNED	AC	CHECKED	KN	APPROVED	TM	DATE	29/MAY/2009			CONTRACT 820 MEI LAI ROAD TO HOI TIN ROAD TUNNELS GENERAL NOTES AND ABBREVIATIONS	
DRAWN	BEN																				
DESIGNED	AC																				
CHECKED	KN																				
APPROVED	TM																				
DATE	29/MAY/2009																				
				<table border="1"> <tr><td>ORIGINATOR</td><td colspan="3">ATKINS</td><td colspan="2">Supported by Arup, TFP, Farrells, DLS, Kenneth Ng</td></tr> <tr><td>CAOD REF.</td><td colspan="3">820_T_NCV_ATK_A58_8006.DGN</td><td colspan="2"></td></tr> </table>				ORIGINATOR	ATKINS			Supported by Arup, TFP, Farrells, DLS, Kenneth Ng		CAOD REF.	820_T_NCV_ATK_A58_8006.DGN					SCALE: NTS DRAWING NO.: 820/T/NCV/ATK/A58/800 REV: B	
ORIGINATOR	ATKINS			Supported by Arup, TFP, Farrells, DLS, Kenneth Ng																	
CAOD REF.	820_T_NCV_ATK_A58_8006.DGN																				
REV	DESCRIPTION	BY	DATE	APPROVED	REV	DESCRIPTION	BY	DATE	APPROVED												
B	TENDER ADDENDUM NO.1	AC	30OCT09	TM	DO NOT SCALE DRAWING. ALL DIMENSIONS SHALL BE RECHECKED ON SITE. © 2009 COPYRIGHT BY ATKINS AND FARRELLS. ALL RIGHTS RESERVED. IN RESPECT OF THIS DRAWING / DOCUMENT IS OWNED BY THE MTR CORPORATION LIMITED. NO PART OF THIS DRAWING / DOCUMENT IS TO BE REPRODUCED OR TRANSMITTED IN ANY FORM OR BY ANY MEANS, ELECTRONIC OR MECHANICAL, INCLUDING PHOTOCOPYING, RECORDING, OR BY ANY INFORMATION STORAGE AND RETRIEVAL SYSTEM, WITHOUT THE WRITTEN CONSENT OF THE MTR CORPORATION LIMITED.																
A	TENDER ISSUE	AC	05OCT09	TM																	


 
 
GENERAL LEGEND FOR LANDSCAPE DETAIL PLAN

-  BOUNDARY LINE
-  EXTENT OF WORKS AREA
-  PLANTER
-  CONCRETE PAVING
-  600 X 400 X 75mm THK
GRASS CELL PAVING FOR PARKING
COLOR: GREEN
-  100 X 200 X 60mm THK
CONCRETE BLOCK TYPE A
FOR PEDESTRAIN
MULTI COLORED GREY/RED
-  100 X 200 X 80mm THK
CONCRETE BLOCK TYPE B
FOR DRIVEWAY
MULTI COLORED GREY/RED
-  200 mm THK
LOOSE LAID GRAVEL IN 30-50mm
-  CONCRETE KERB (HYD STANDARD DETAIL-TYPE K1)
125 X 1000 X 250mm DEEP
CUSTOM MADE BY CONTRACTOR TO HYD STANDARD
-  GMS FENCE WALL
TYPE 1
COLOR: BROWN
CUSTOM MADE BY CONTRACTOR
-  GMS SECURITY GATE 1
COLOR: BROWN
CUSTOM MADE BY CONTRACTOR
-  GMS SECURITY GATE 2
COLOR: BROWN
CUSTOM MADE BY CONTRACTOR



 

GENERAL LEGEND FOR PLANTING PLAN

-  FEATURE PLANT
-  SHRUB
-  GROUND COVER
-  GRASS
-  BAMBOO
-  EXISTING TRANSPLANTED
TREE TO BE PLANTED
IN FINAL LOCATION
BY OTHERS
-  EXISTING TREES TO BE
RETAINED AND PROTECTED
-  TREES FOR TRANSPLANT TO BE PROTECTED
AND FENCED FOR UP TO 180 DAYS TO BE
REMOVED BY OTHERS
-  TREE PROTECTION
FENCE AND AREA
-  COMPENSATION TREE


GENERAL LEGEND FOR LANDSCAPE UTILITY PLAN

-  IRRIGATION WATER POINT
(5.5 BOX IN GRADE 316 & HAIRLINE FINISH)
CUSTOM MADE BY CONTRACTOR
-  FALL DIRECTION
-  POLE LIGHTING

GENERAL LEGEND FOR SOILING PLAN

-  300mm DEPTH PLANTING SOIL MIX
ABOVE MIN. 900mm DEPTH SUB SOIL
-  150mm DEPTH PLANTING SOIL
FOR GRASS CRETE
-  TOP OF SOIL LEVEL
-  100mm DEPTH GROWING MEDIUM
FOR GREEN ROOF
(MIN 15 % NATURAL COMPOST)

REV	DESCRIPTION	BY	DATE	APPROVED	REV	DESCRIPTION	BY	DATE	APPROVED


 MTR EXPRESS RAIL LINK		TITLE CONTRACT 820 MEI LAI ROAD TO HOI TING ROAD TUNNELS GENERAL LEGEND
DATE 29/MAY/2009	CADD REF. 820_T_NCV_ATK_A58_801C.DGN	SCALE NTS
DRAWN BEN	DESIGNED AC	DRAWING NO. 820/T/NCV/ATK/A58/801
CHECKED KN	APPROVED TM	REV. C

DO NOT SCALE DRAWING. ALL DIMENSIONS SHALL BE
 VERIFIED ON SITE.
 © THE CORPORATION LIMITED 2009. COPYRIGHT IN
 RESPECT OF THIS DRAWING / DOCUMENT IS OWNED BY THE
 MTR CORPORATION LIMITED OF HONG KONG. NO
 REPRODUCTION OF THE DRAWING / DOCUMENT OR ANY PART
 OF EITHER OR HEREAS IS PERMITTED WITHOUT THE PRIOR
 WRITTEN CONSENT OF THE MTR CORPORATION LIMITED.


Maps reproduced with permission of the Director of Lands, © Hong Kong Government



+5.1

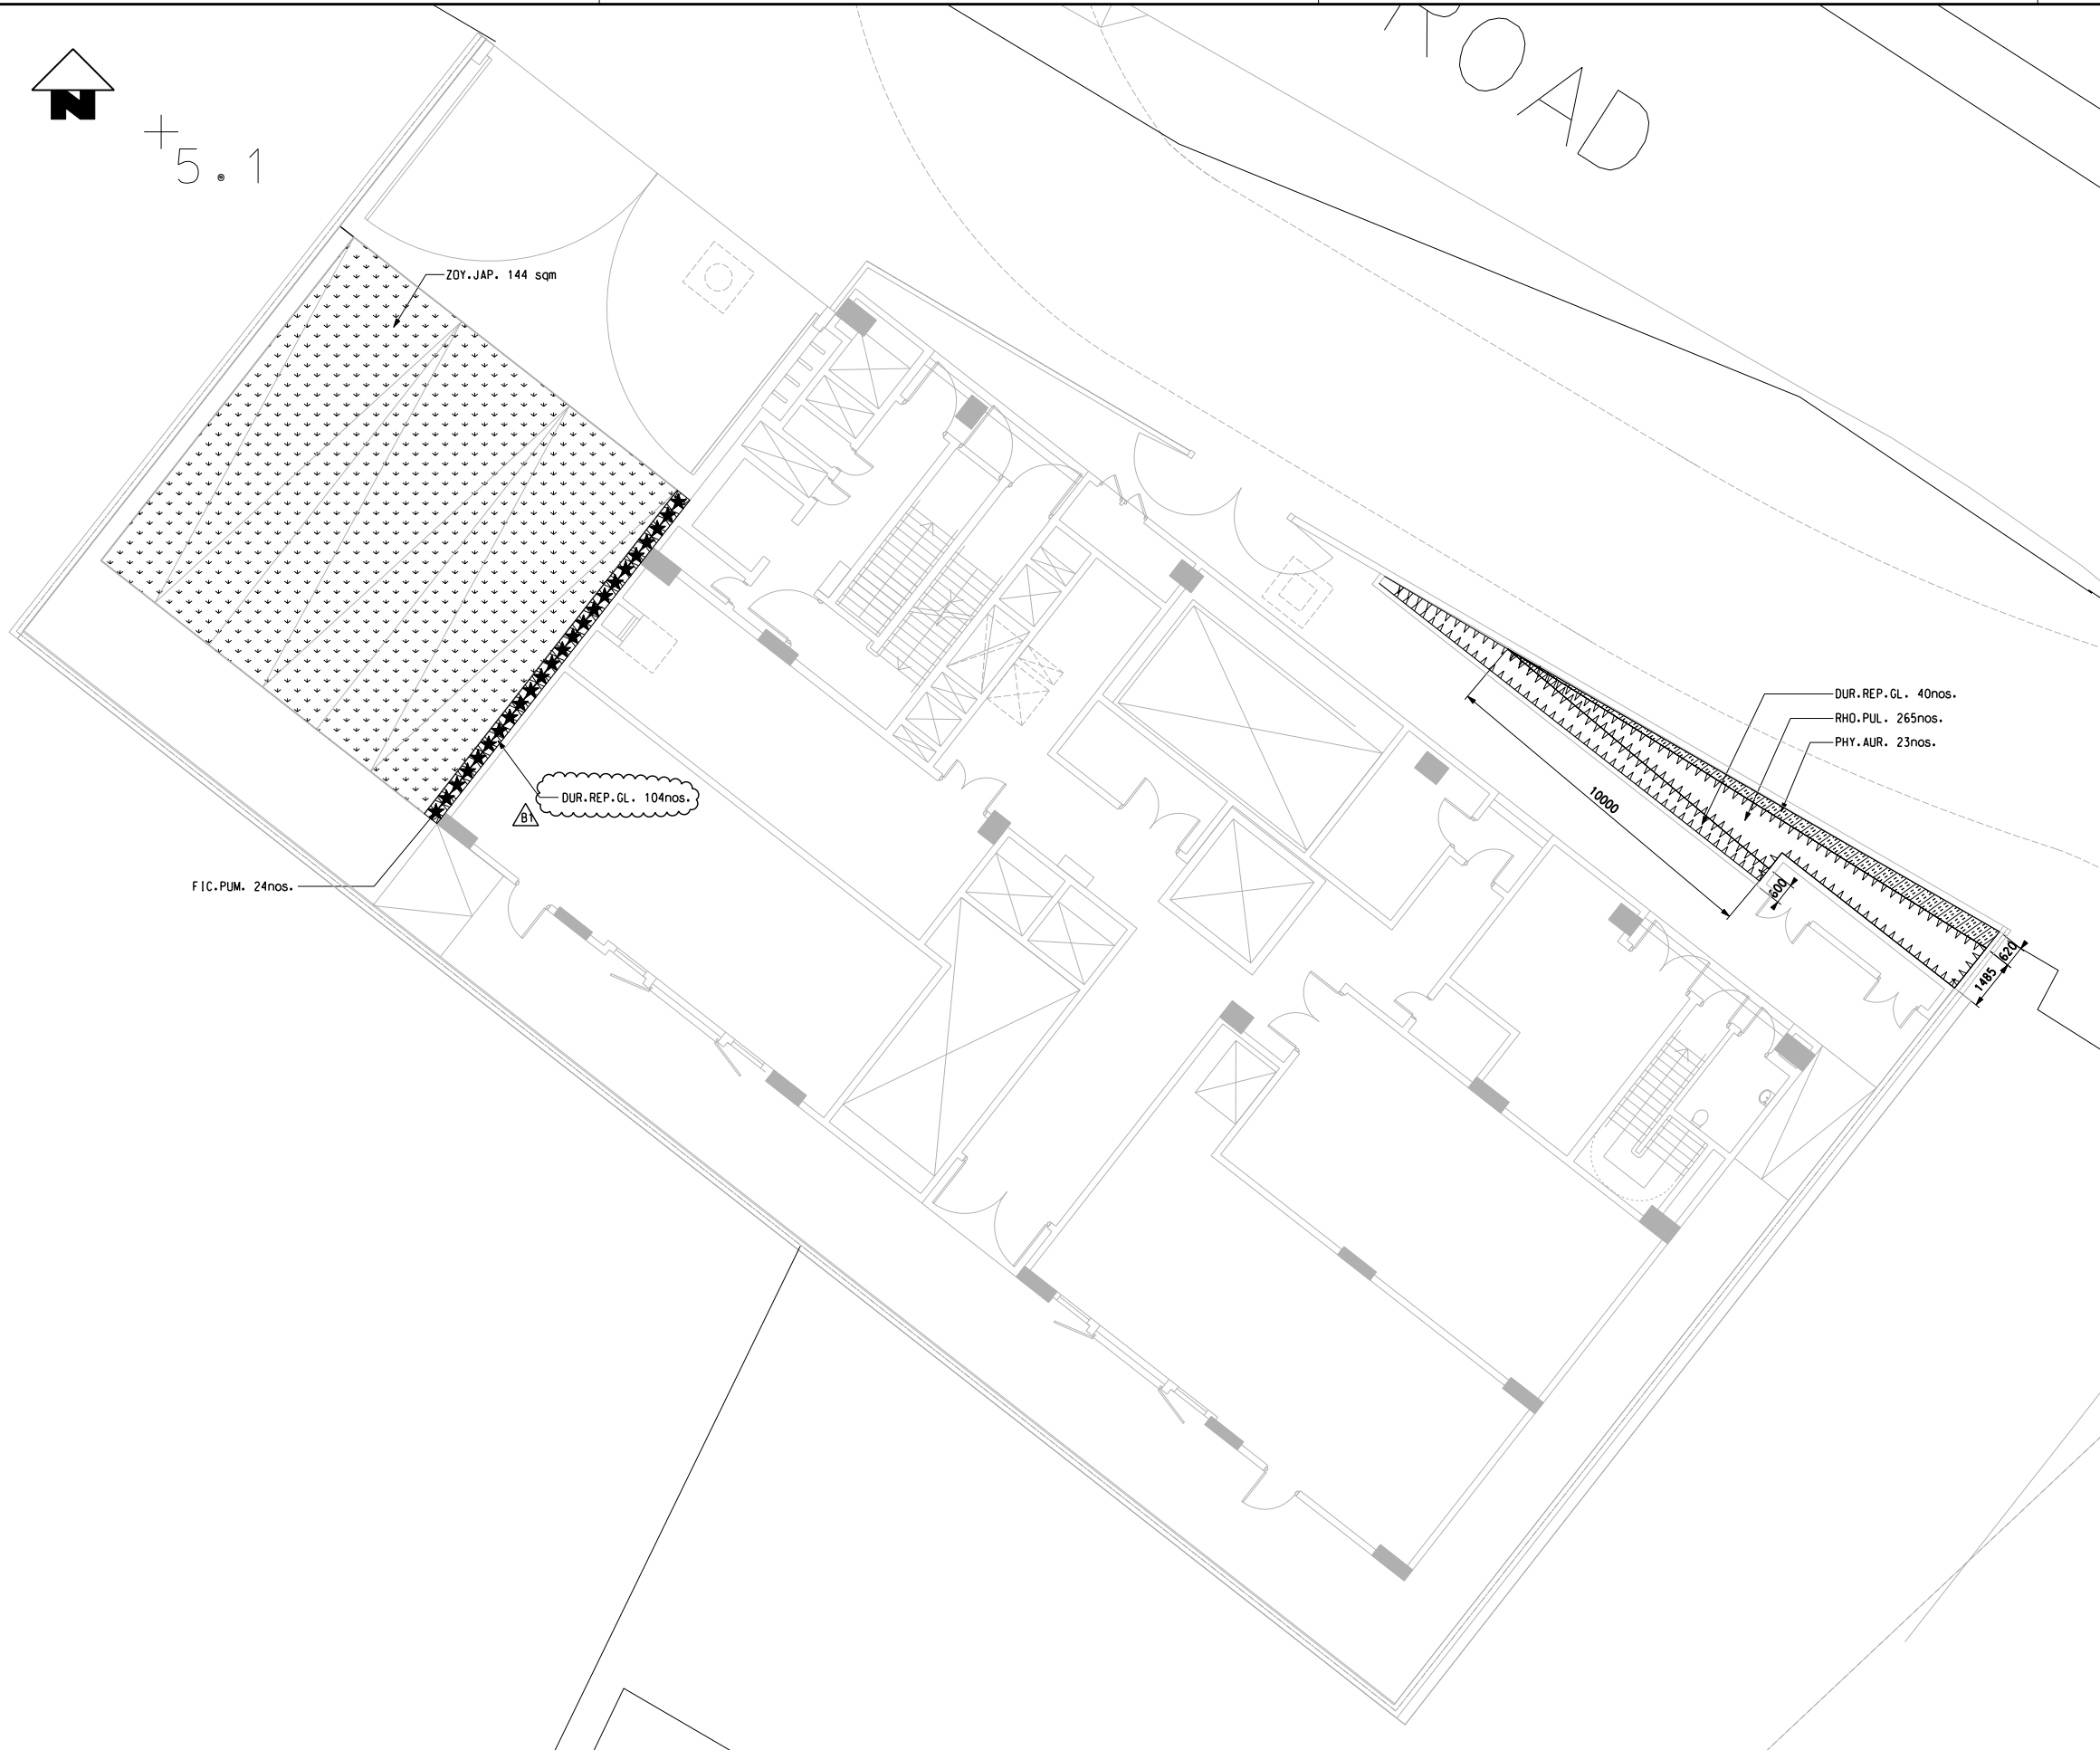


NOTES:
FOR GENERAL NOTE, REFER TO DWG.NO. 820/W/NCV/ATK/A58/800
LEGEND:
FOR GENERAL LEGEND, REFER TO DWG.NO. 820/W/NCV/ATK/A58/801

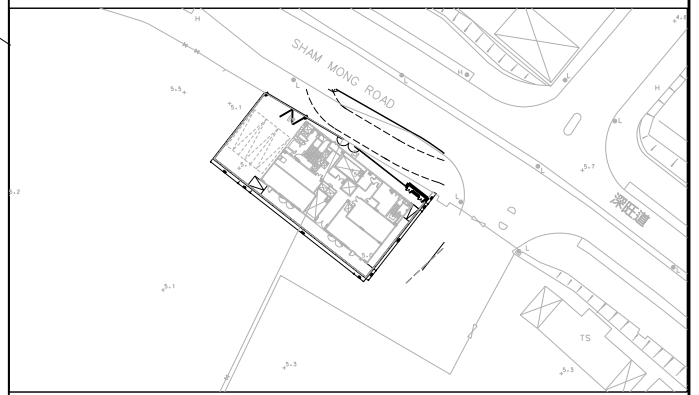

KEY LOCATION PLAN SCALE 1 : 1000

TYPE	BOTANICAL NAME	CHINESE NAME	STANDARD	SPACING	REMARKS	QTY.
BAMBOO 竹類						
PHY.AUR.	PHYLLOSTACHYS AUREA	籬漢竹	1500H	500	CONTAINER GROWN	23
SHRUB 灌木類						
DUR.REP.GL.	DURANTA REPEN 'GOLDEN LEAF'	金蓮翹	300 x 300	250	POTTED	144
RHO.PUL.	RHODODENDRON PULCHRUM	紫杜鵑	600 x 500	500	POTTED	265
GRASS 草地類						
ZOY.JAP.	ZOYSIA JAPONICA	台灣草	300 x 300	-	-	144 sqm
CLIMBER 爬藤類						
FIC.PUM.	FICUS PUMILA	藤荔	250H	500	5NOS OF SHOOTS	24

 

REV	DESCRIPTION	BY	DATE	APPROVED	REV	DESCRIPTION	BY	DATE	APPROVED
B1	REVISION TO PLANTING SCHEDULE	AC	MAY10	TM					
A	WORKING DRAWING ISSUE	AC	MAY10	TM					


DO NOT SCALE DRAWINGS. ALL DIMENSIONS SHALL BE VERIFIED ON SITE.
© MTR CORPORATION LIMITED 2009 COPYRIGHT IN RESPECT OF THIS DRAWING / DOCUMENT IS OWNED BY THE MTR CORPORATION LIMITED OF HONG KONG. NO REPRODUCTION OF THE DRAWING / DOCUMENT OR ANY PART BY WHATEVER MEANS IS PERMITTED WITHOUT THE PRIOR WRITTEN CONSENT OF THE MTR CORPORATION LIMITED.

MTR
EXPRESS RAIL LINK
ORIGINATOR
ATKINS Supported by Arup, TFP Farrells, DLS Kenneth Ng
CADD REF. 820_W_NCV_ATK_A58_843B1.DGN

TITLE		CONTRACT 820 MEI LAI ROAD TO HOI TING ROAD TUNNELS NAM CHEONG VENTILATION BUILDING (VB7) LANDSCAPE PLANTING PLAN	
SCALE	DRAWING NO.	REV.	
1 : 100 (A1)	820/W/NCV/ATK/A58/843	B1	


FILENAME: \$FILES

Maps reproduced with permission of the Director of Lands, © Hong Kong Government

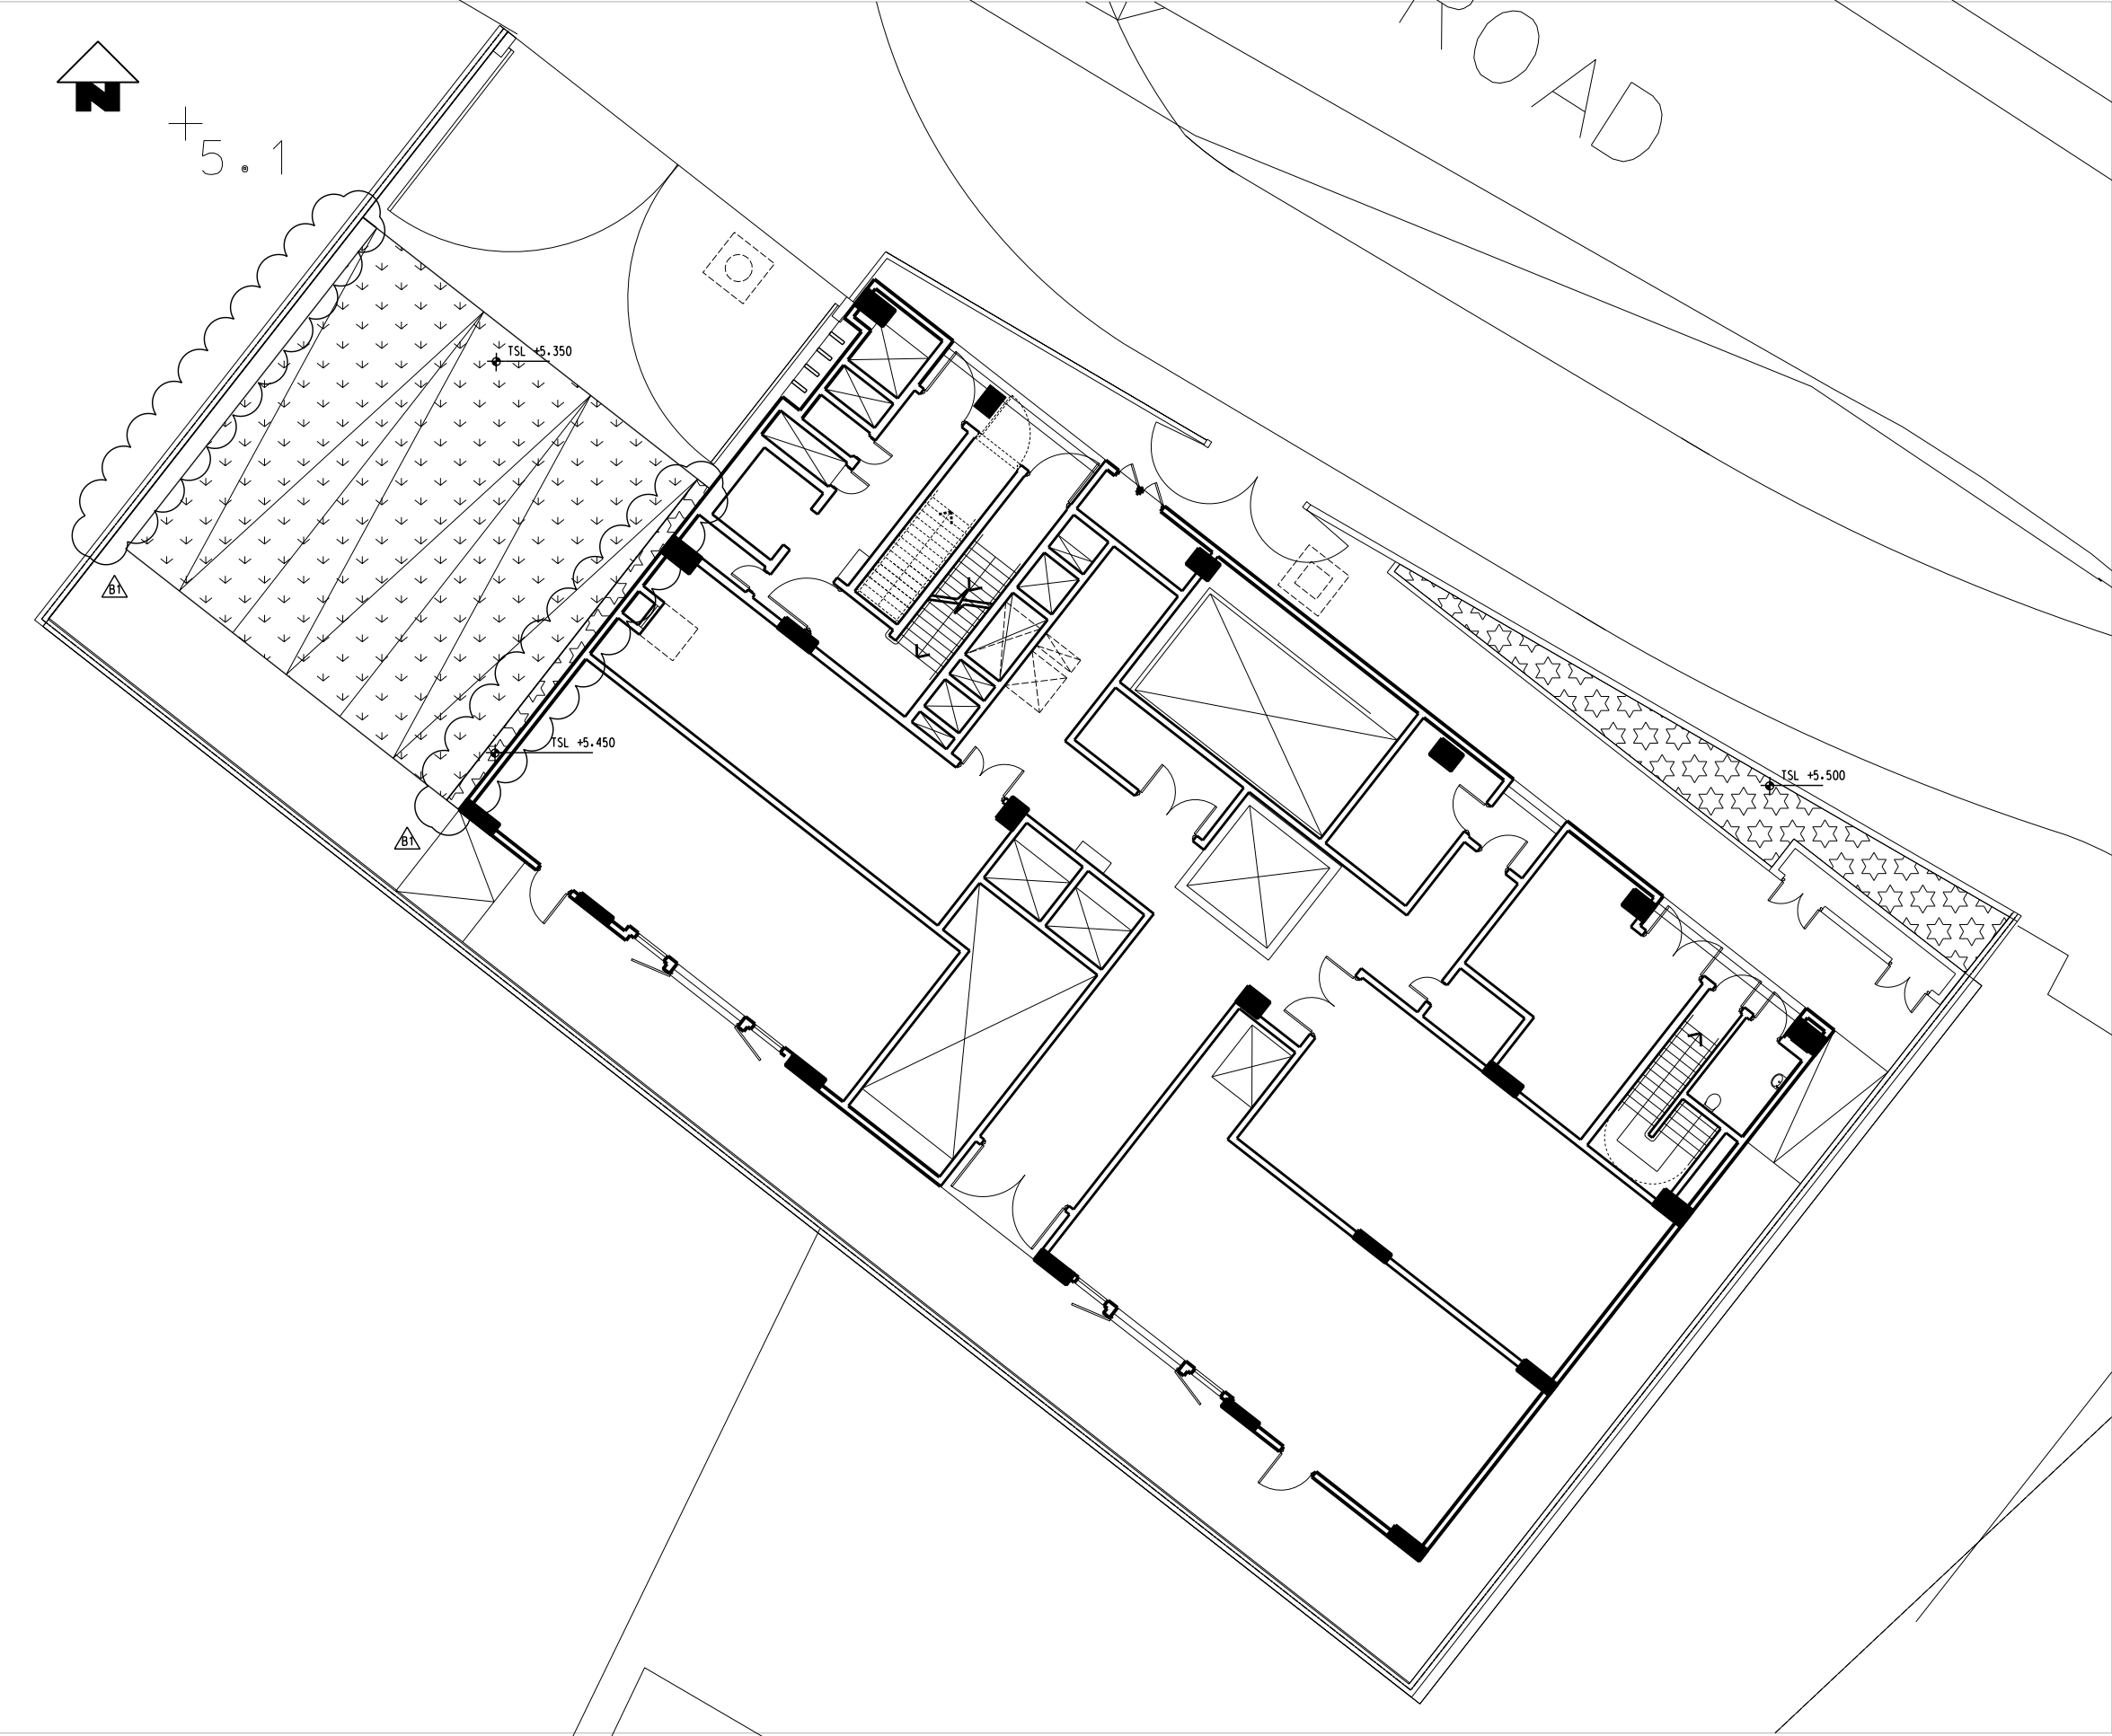


NOTES:
FOR GENERAL NOTE, REFER TO DWG. NO. 820/W/NCV/ATK/A58/800

LEGEND:
FOR GENERAL LEGEND, REFER TO DWG. NO. 820/W/NCV/ATK/A58/801

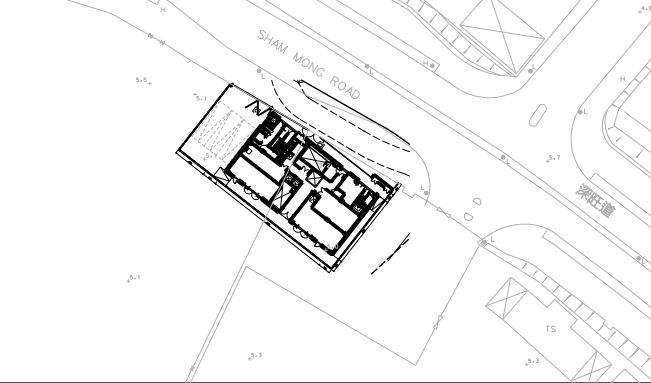

KEY LOCATION PLAN SCALE 1 : 1000

 - 600 mm DEPTH PLANTING SOIL MIX ABOVE MIN. 600 mm DEPTH SUB-BASE
AREA : 34.16 sqm
- 60 mm DEPTH PLANTING SOIL MIX FOR GRASS CRETE
AREA : 144 sqm



REV	DESCRIPTION	BY	DATE	APPROVED
B1	REVISION TO SOILING	AC	MAY10	TM
A	WORKING DRAWING ISSUE	AC	MAY10	TM

DRAWN	BEN
DESIGNED	AC
CHECKED	KN
APPROVED	TM
DATE	27/APR/2009

DO NOT SCALE DRAWINGS. ALL DIMENSIONS SHALL BE VERIFIED ON SITE.
© MTR CORPORATION LIMITED 2009. COPYRIGHT IN RESPECT OF THIS DRAWING DOCUMENT IS OWNED BY THE MTR CORPORATION LIMITED OF HONG KONG. NO REPRODUCTION OF THE DRAWING DOCUMENT OR ANY PART BY WHATEVER MEANS IS PERMITTED WITHOUT THE PRIOR WRITTEN CONSENT OF THE MTR CORPORATION LIMITED.

MTR

EXPRESS RAIL LINK

ORIGINATOR

ATKINS Supported by Arup, TFP Farrells, DLS Kenneth Ng



CADD REF. 820_W_NCV_ATK_A58_844B1.DGN

TITLE	CONTRACT 820 MEI LAI ROAD TO HOI TING ROAD TUNNELS NAM CHEONG VENTILATION BUILDING (VB7) LANDSCAPE SOILING PLAN
SCALE	1 : 100 (A1)
DRAWING NO.	820/W/NCV/ATK/A58/844
REV.	B1


FILES

Maps reproduced with permission of the Director of Lands, © Hong Kong Government

PROJECT FILE: 820/T/NCV/ATK/A58/845

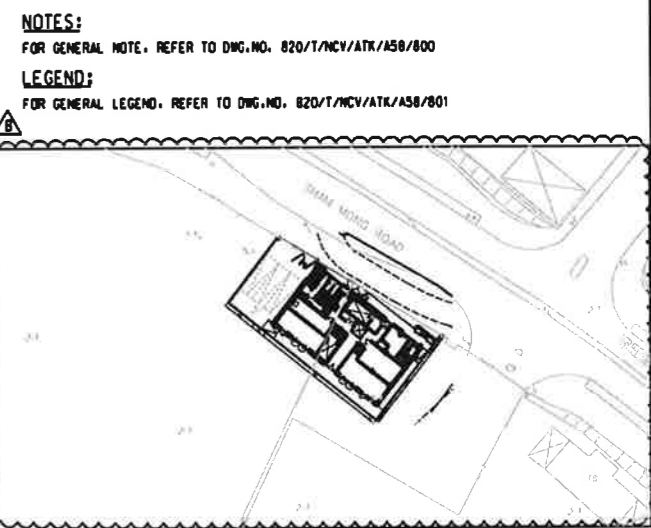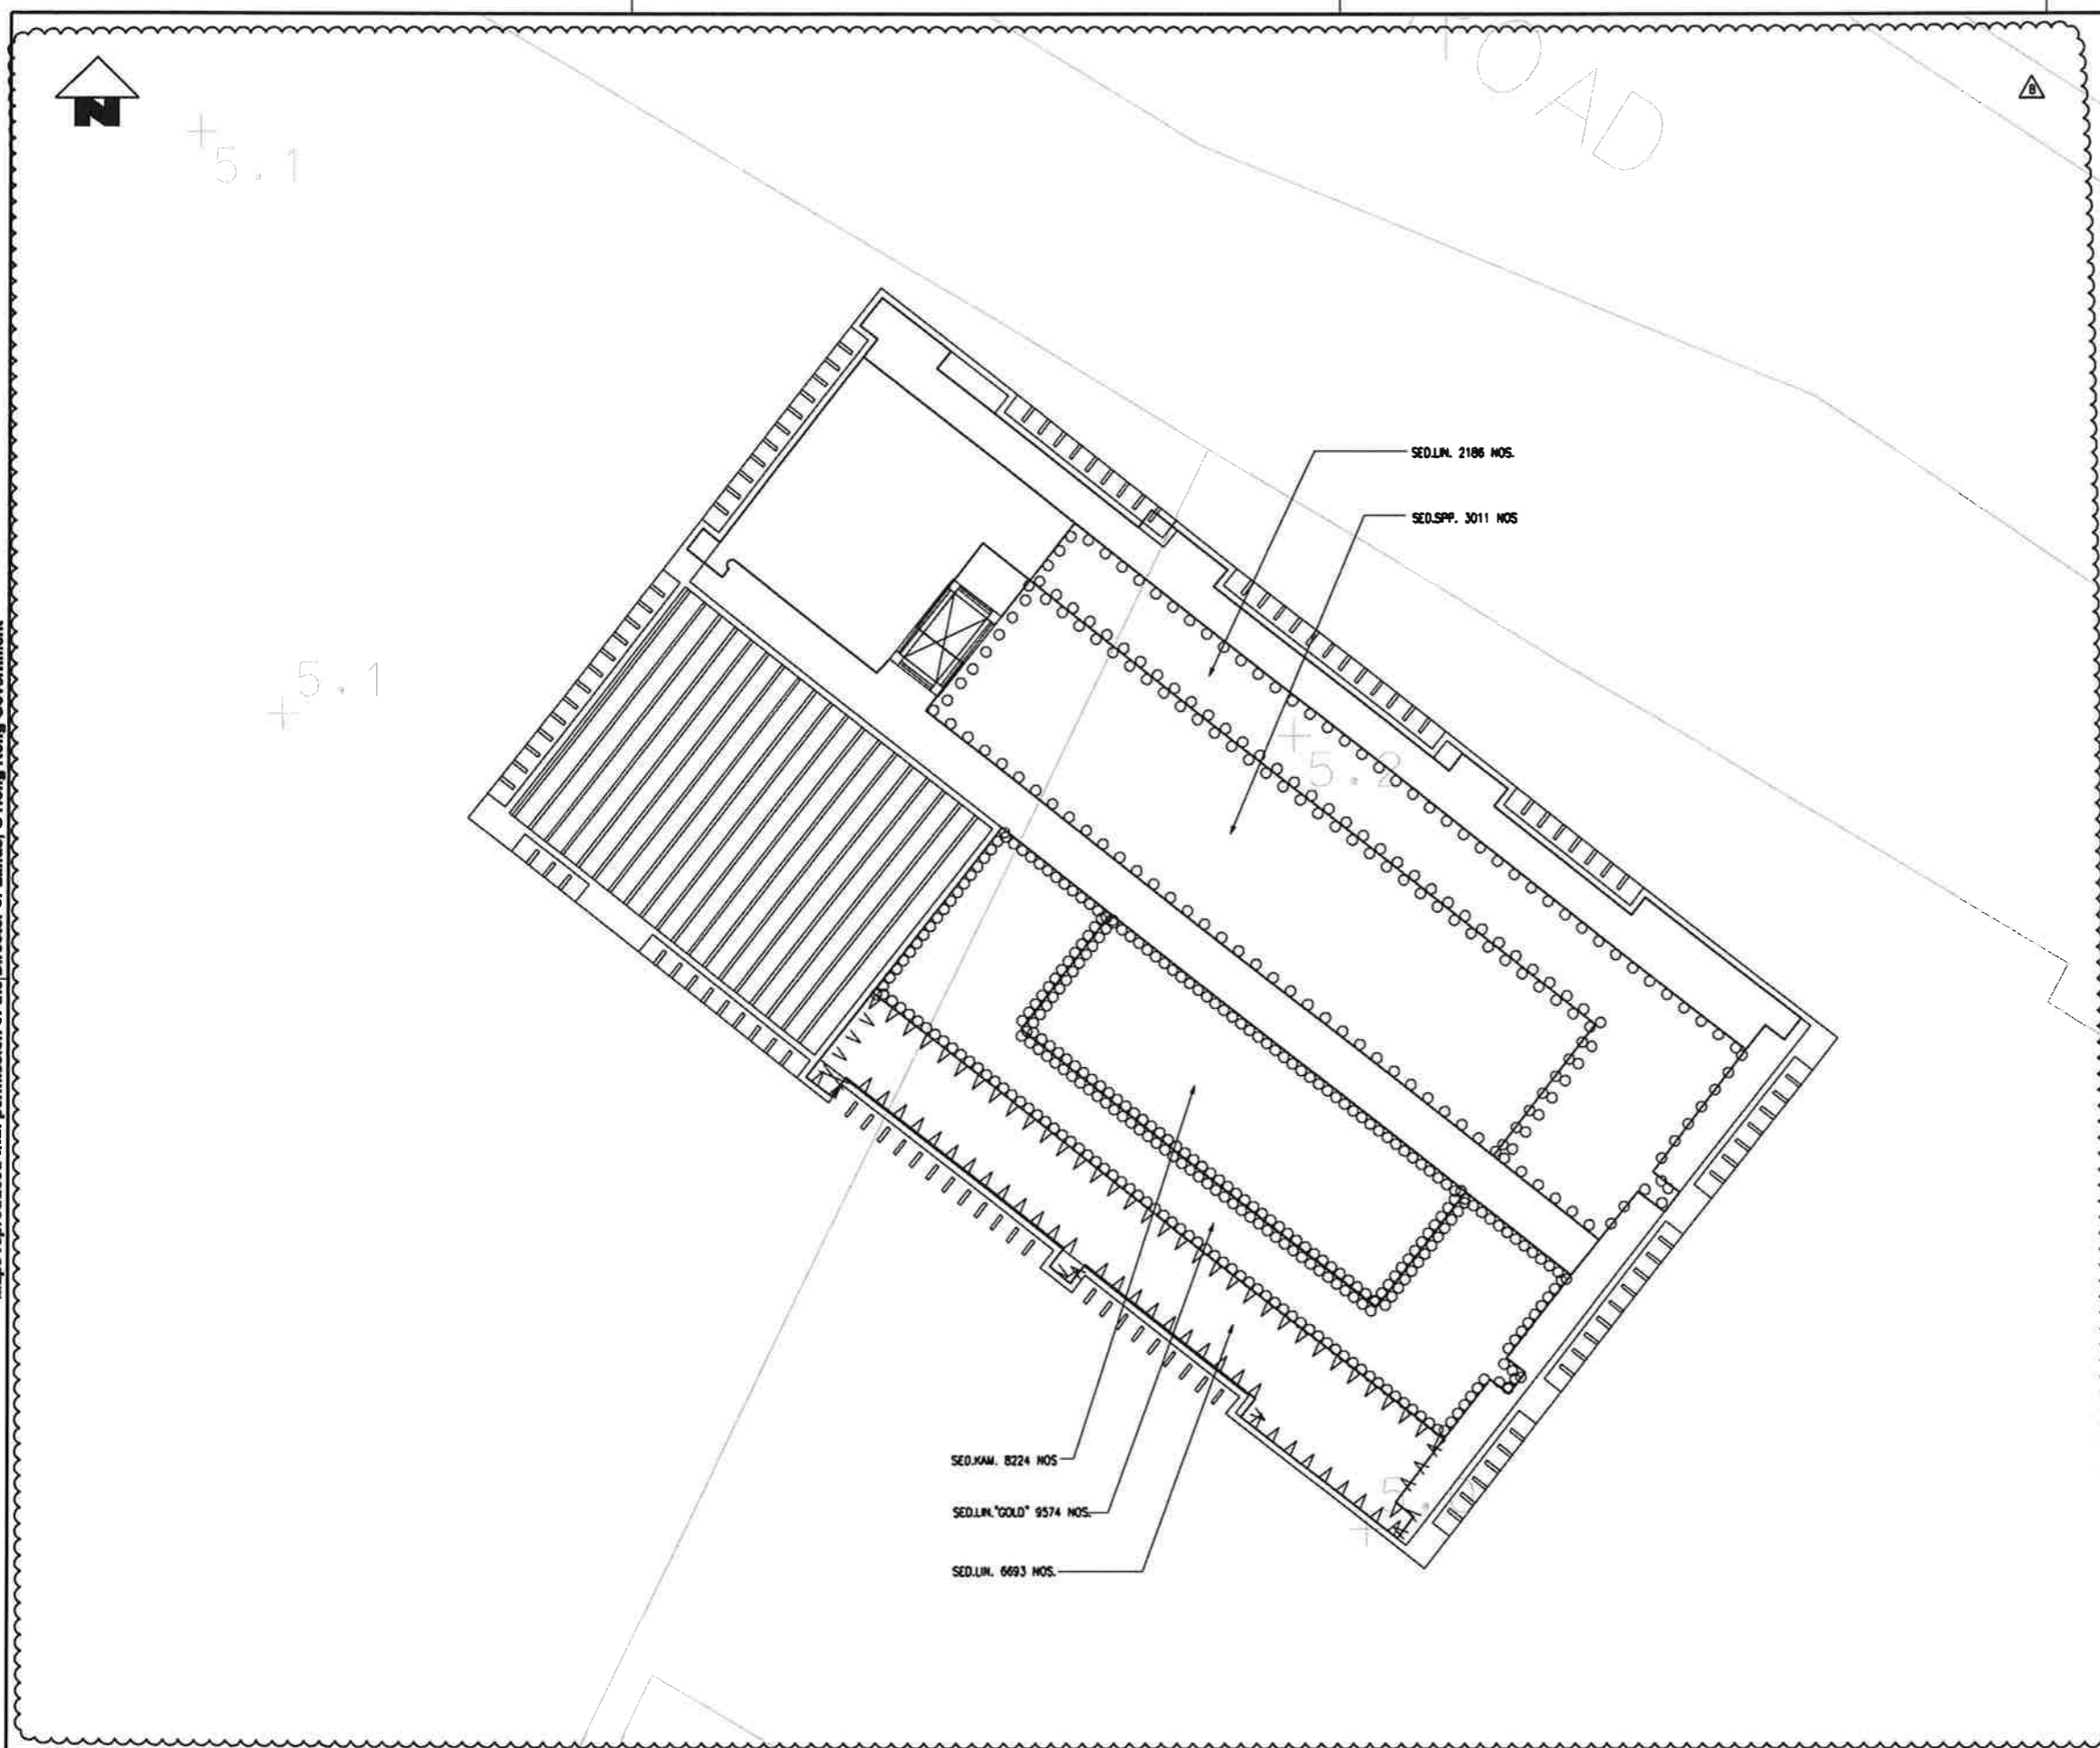

Type	Botanical Name	Chinese Name	Standard	Spacing	Remarks	Quantity
GROUND COVER						
SED.LIN.	SEDUM LINEARA	景天	150x100S	100	POTTED	18374
SED.LIN.'GOLD'	SEDUM LINEARA 'GOLD'	金邊景天	150x100S	100	POTTED	21700
SED.KAM.	SEDUM KAMTSCHATCUM	三七景天	150x100S	100	POTTED	8224

 

DRAWN		BEN			EXPRESS RAIL LINK	
DESIGNED		AC			ORIGINATOR	
CHECKED		KN			ATKINS Supported by Arup, TFP, Farrells, DLS Kenneth Ng	
APPROVED		TM			CAAD REF. 820.T.NCV.ATK.A58.845B.DGN	
DATE		27/APR/2009				
<small>DO NOT SCALE DRAWINGS. ALL DIMENSIONS SHALL BE VERIFIED ON SITE. © THE CORPORATION LIMITED 2009. ALL RIGHTS RESERVED. IN RESPECT OF THIS DRAWING / DOCUMENT IS OWNED BY THE CORPORATION OF THE HONG KONG SPECIAL ADMINISTRATIVE REGION. NO REPRODUCTION OF THE DRAWING / DOCUMENT OR ANY PART OF THE SAME IS PERMITTED WITHOUT THE PRIOR WRITTEN CONSENT OF THE MTR CORPORATION LIMITED.</small>						
REV	DESCRIPTION	BY	DATE	APPROVED	REV	DESCRIPTION
B	TENDER ADDENDUM NO.1	AC	30OCT09	TM		
A	TENDER ISSUE	AC	05OCT09	TM		

TITLE		
CONTRACT 820 TUNNELS & ASSOCIATED STRUCTURE (SOUTH) NAM CHEONG VENTILATION BUILDING (VB7) LANDSCAPE PLANTING PLAN - UPPER ROOF		
SCALE	DRAWING NO.	REV.
1 : 100 (A1)	820/T/NCV/ATK/A58/845	B




+5.1

+5.1


+5.2

ROAD

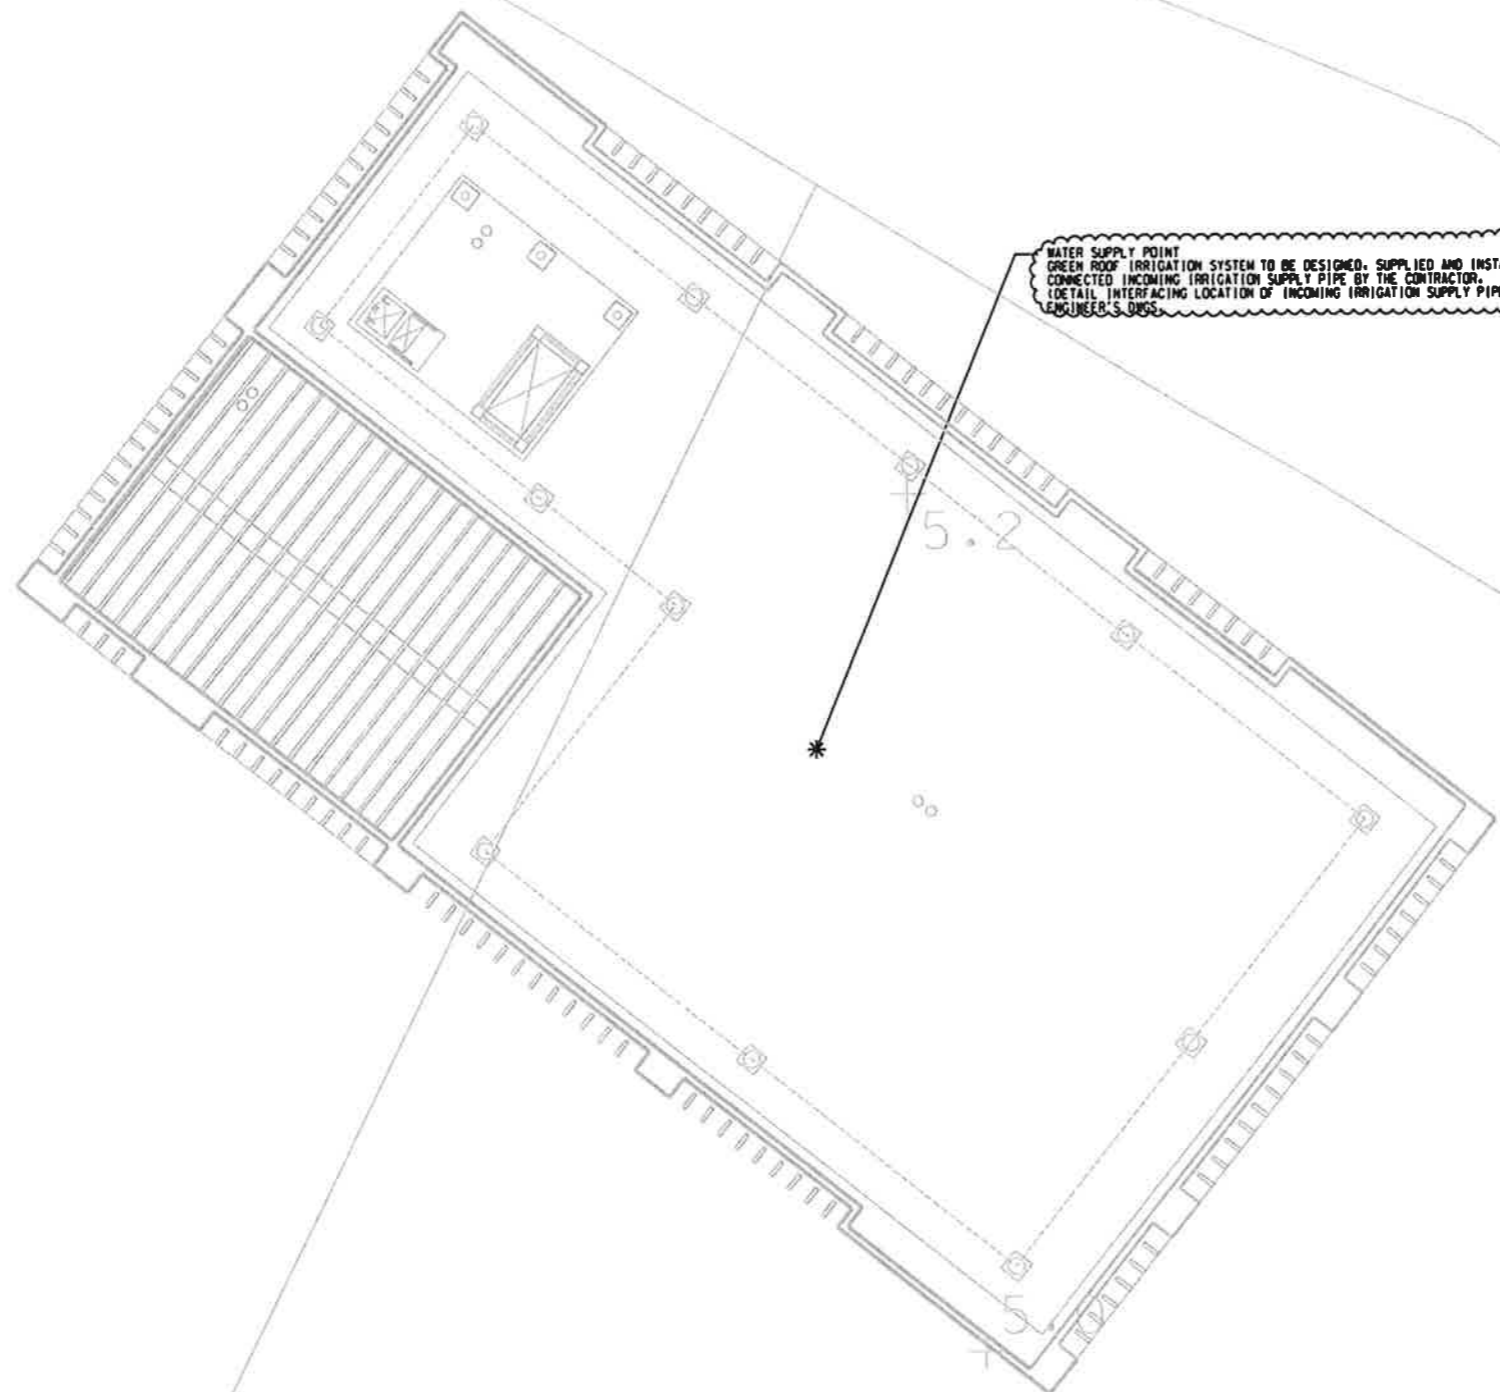


WATER SUPPLY POINT
GREEN ROOF IRRIGATION SYSTEM TO BE DESIGNED, SUPPLIED AND INSTALLED, AND FINAL CONNECTED INCOMING IRRIGATION SUPPLY PIPE BY THE CONTRACTOR.
DETAIL INTERFACING LOCATION OF INCOMING IRRIGATION SUPPLY PIPE. PLEASE REFER TO ENGINEER'S DWS.

NOTES:
FOR GENERAL NOTE, REFER TO DWG. NO. 820/T/NCV/ATK/A58/800
LEGEND:
FOR GENERAL LEGEND, REFER TO DWG. NO. 820/T/NCV/ATK/A58/801

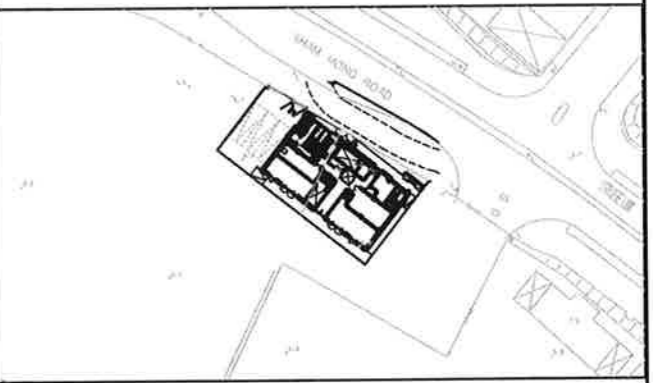

KEY LOCATION PLAN SCALE 1 : 1000

 NOTE:
GREEN ROOF IRRIGATION SYSTEM TO BE DESIGNED AND SUPPLIED BY SPECIALIST TO PARTICULAR SPECIFICATION. CONTRACTOR SHOULD SUBMIT THE DISTRIBUTION PIPE WORK LAYOUT (VERTICAL / HORIZONTAL PUMPING LINE DIAGRAM) FOR ENGINEER APPROVAL



REV	DESCRIPTION	BY	DATE	APPROVED
C1	ACP TENDER ADDENDUM NO. 2	TT	30NOV09	TM
B	TENDER ADDENDUM NO. 1	TT	30OCT09	TM
A	TENDER ISSUE	TT	05OCT09	TM

REV	DESCRIPTION	BY	DATE	APPROVED

DRAWN	BEN
DESIGNED	AC
CHECKED	KN
APPROVED	TM
DATE	27/APR/2009

MTR

EXPRESS RAIL LINK

ORIGINATOR

ATKINS Supported by Arup, TFP Farrells, DLS Kenneth Ng

CADD REF. 820_T_NCV_ATK_A58_846C1.DGN

TITLE

CONTRACT 820

MEI LAI ROAD TO HOI TING ROAD TUNNELS

MAN-CHEUNG VENTILATION BUILDING (VBT)

UTILITY PLAN - UPPER ROOF

SCALE 1 : 100 (A1)

DRAWING NO. 820/T/NCV/ATK/A58/846


REV. C1

DO NOT SCALE DRAWINGS. ALL DIMENSIONS SHALL BE VERIFIED ON SITE.
© THE CORPORATION LIMITED 2009. COPYRIGHT IN REPEAL OF THIS DRAWING / DOCUMENT IS OWNED BY THE CORPORATION LIMITED OF HONG KONG. NO REPRODUCTION OF THE DRAWING / DOCUMENT OR ANY PART BY WHATEVER MEANS IS PERMITTED WITHOUT THE PRIOR WRITTEN CONSENT OF THE CORPORATION LIMITED.




+5.1


+5.1

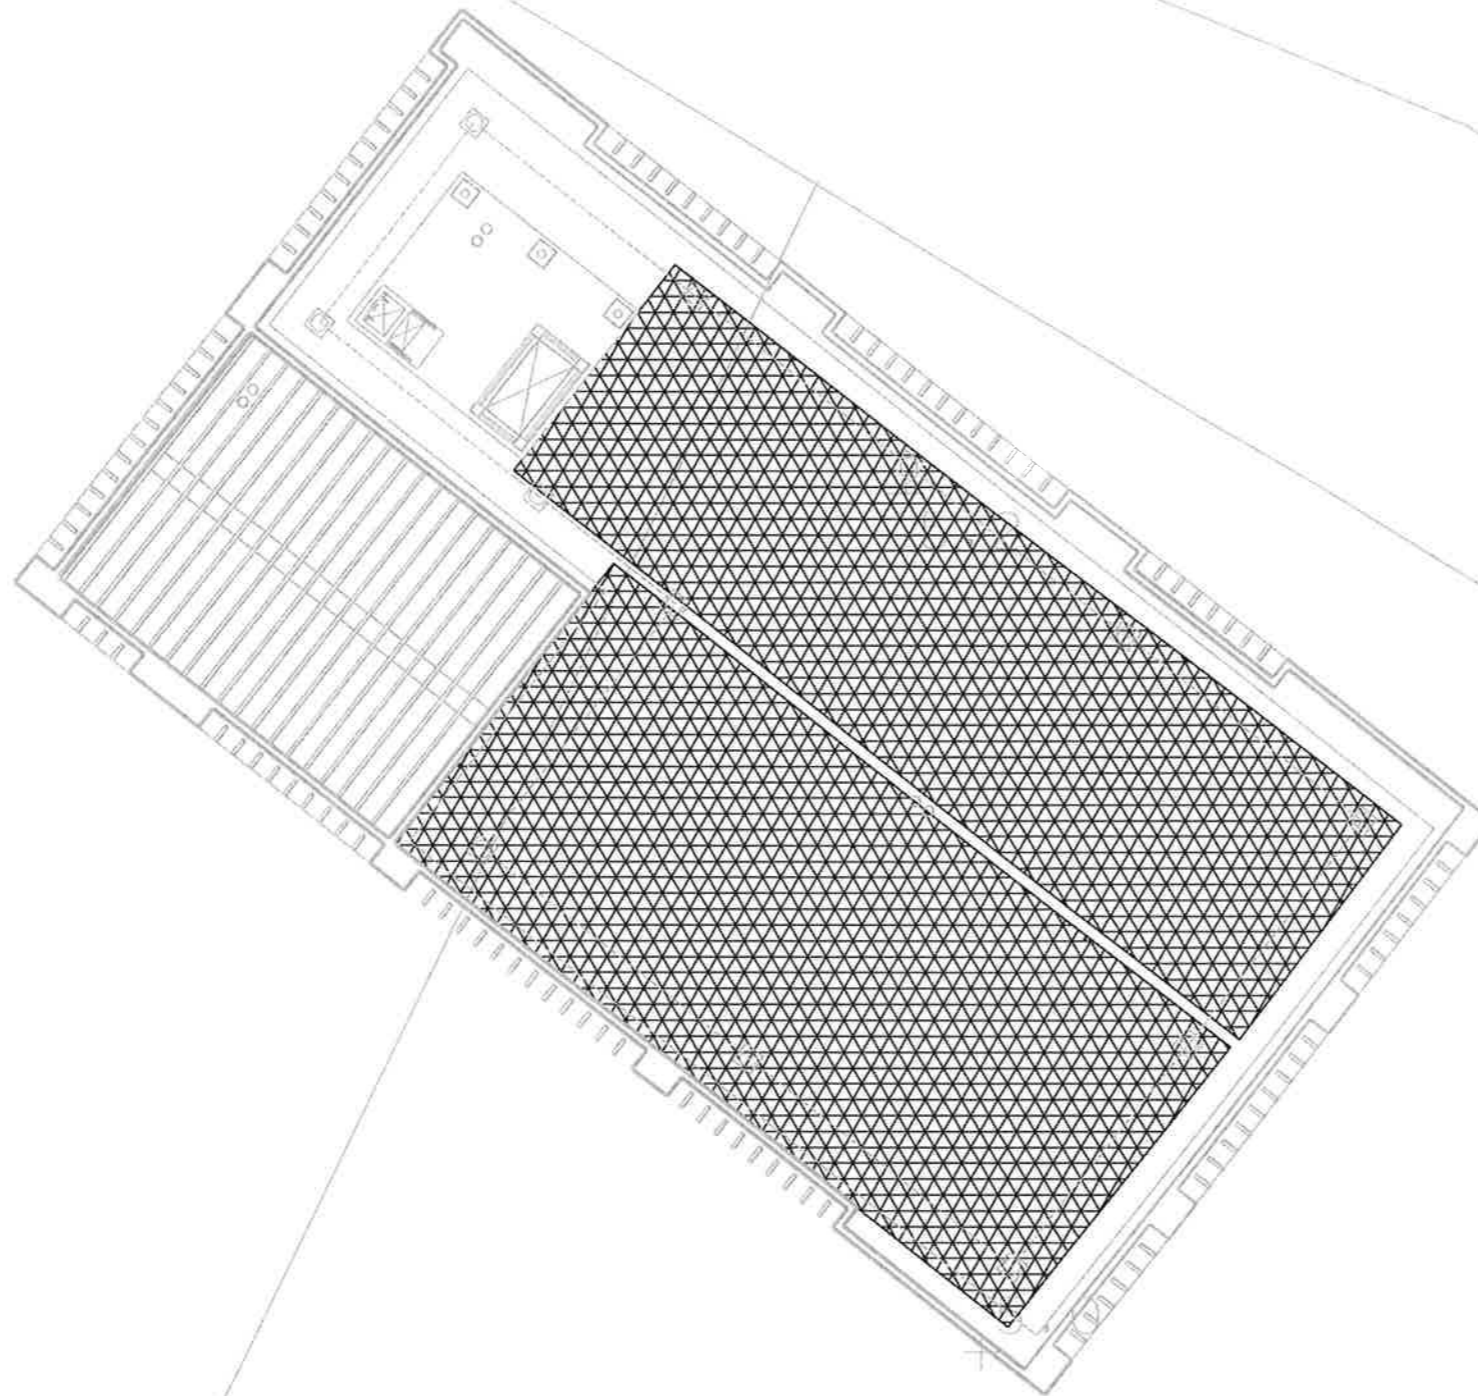


NOTES:
FOR GENERAL NOTE, REFER TO DWG. NO. 820/T/NCV/ATK/A58/800
LEGEND:
FOR GENERAL LEGEND, REFER TO DWG. NO. 820/T/NCV/ATK/A58/801

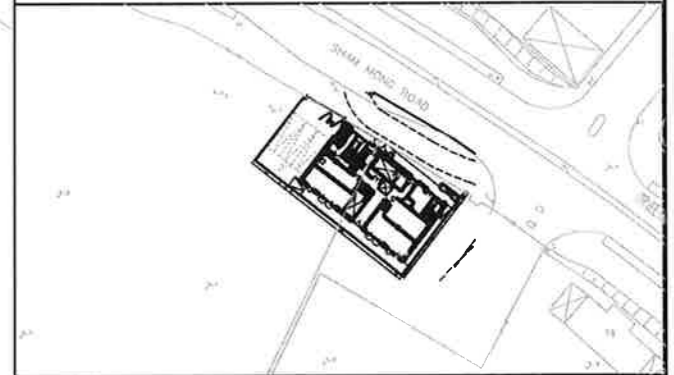


KEY LOCATION PLAN SCALE 1 : 1000

 


						DRAWN BEN DESIGNED AC CHECKED KN APPROVED TM				EXPRESS RAIL LINK					
				DATE 27/APR/2009		ORIGINATOR ATKINS		Supported by Arup, TFP, Farrells, DLS Kenneth Ng		TITLE CONTRACT 820 MEI LAI ROAD TO HOI TING ROAD TUNNELS RAIN CHECKING VENTILATION BOTTLING (VB7) SOILING PLAN - UPPER ROOF					
		C1 ACP TENDER ADDENDUM NO.2 B TENDER ADDENDUM NO.1 A TENDER ISSUE		TT 30NOV09 TM TT 30OCT09 TM TT 05OCT09 TM		DO NOT SCALE DRAWINGS. ALL DIMENSIONS SHALL BE READ OFF THIS DRAWING. REVISIONS / RECORDS IS OWNED BY THE MTR CORPORATION LIMITED 2009. ALL RIGHTS RESERVED. NO REPRODUCTION OF THIS DRAWING / RECORDS OR ANY PART OF THIS DRAWING IS PERMITTED WITHOUT THE PRIOR WRITTEN CONSENT OF THE MTR CORPORATION LIMITED.		CADD REF. 820_T_NCV_ATK_A58_847C1.DGN		SCALE 1 : 100 (A1)		DRAWING NO. 820/T/NCV/ATK/A58/847		REV. C1	

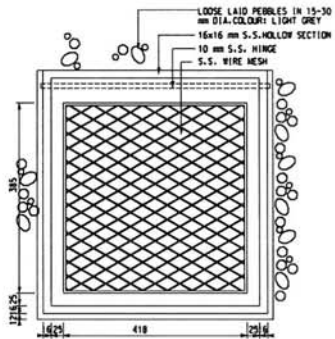


DETAIL OF TYPICAL DRAINAGE INSPECTION CHAMBER ①
SCALE 1 : 5

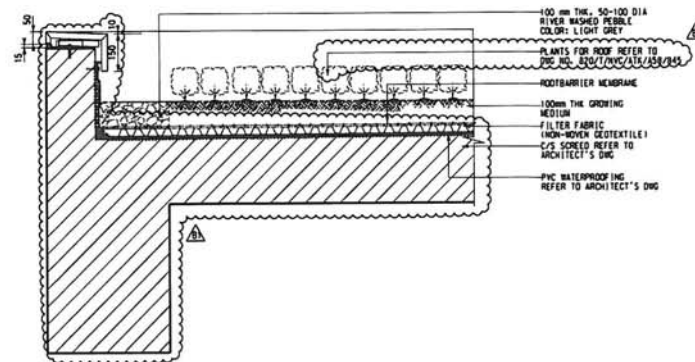

DETAIL OF PARAPET EDGE TREATMENT ③
SCALE 1 : 10

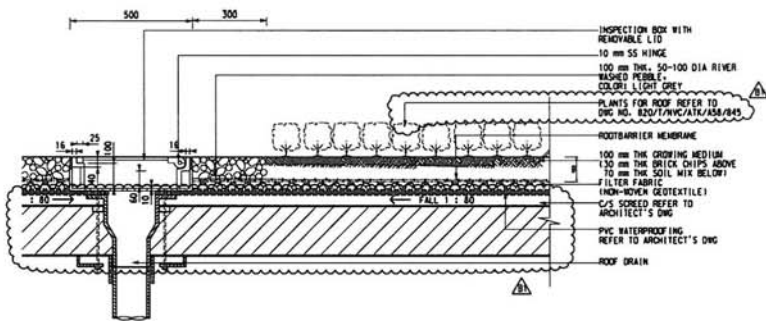

DETAIL OF TYPICAL DRAINAGE INSPECTION CHAMBER ②
SCALE 1 : 10

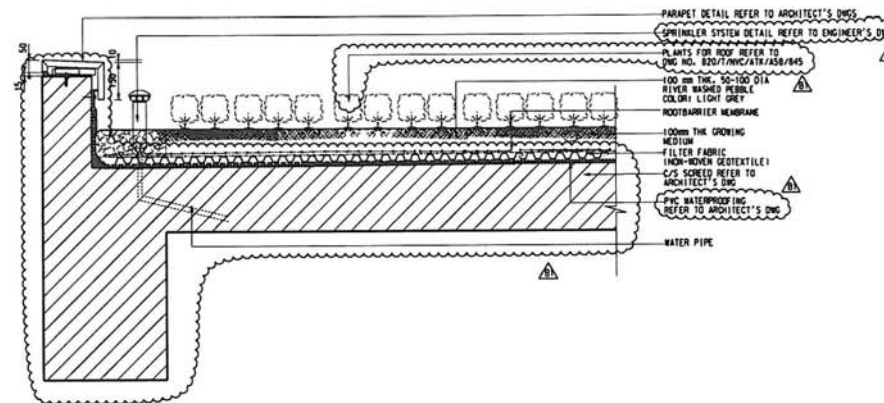

DETAIL OF TYPICAL PENETRATION OF ROOF-TOP UTILITIES ④
SCALE 1 : 10

DRAWN: BF		MTR		TITLE: CONTRACT 820	
DESIGNED: AC		EXPRESS RAIL LINK		MEI LAI ROAD TO HOI TING ROAD TUNNELS	
CHECKED: KN		ORIGINATOR: Atkins		ROAD CREDING VENTILATION BUILDING (VBT)	
APPROVED: TM		Supported by Arup, TFP, Farrelis, DLS, Kenneth Ng		LANDSCAPE DETAIL - UPPER ROOF DETAILS	
DATE: 29/MAY/2009		CADW. REF.: 820/T/NCV/ATK/A58/856B1.DGN		SCALE: AS SHOWN	
B1 ACP TENDER ADDENDUM NO.2 AC 30NOV09 TM		DRAWING NO. 820/T/NCV/ATK/A58/856		REV: B1	
A TENDER ISSUE AC 05OCT09 TM					
REV	DESCRIPTION	BY	DATE	APPROVED	REV