


FOR CONTINUATION SEE FIGURE NO. 6.2a

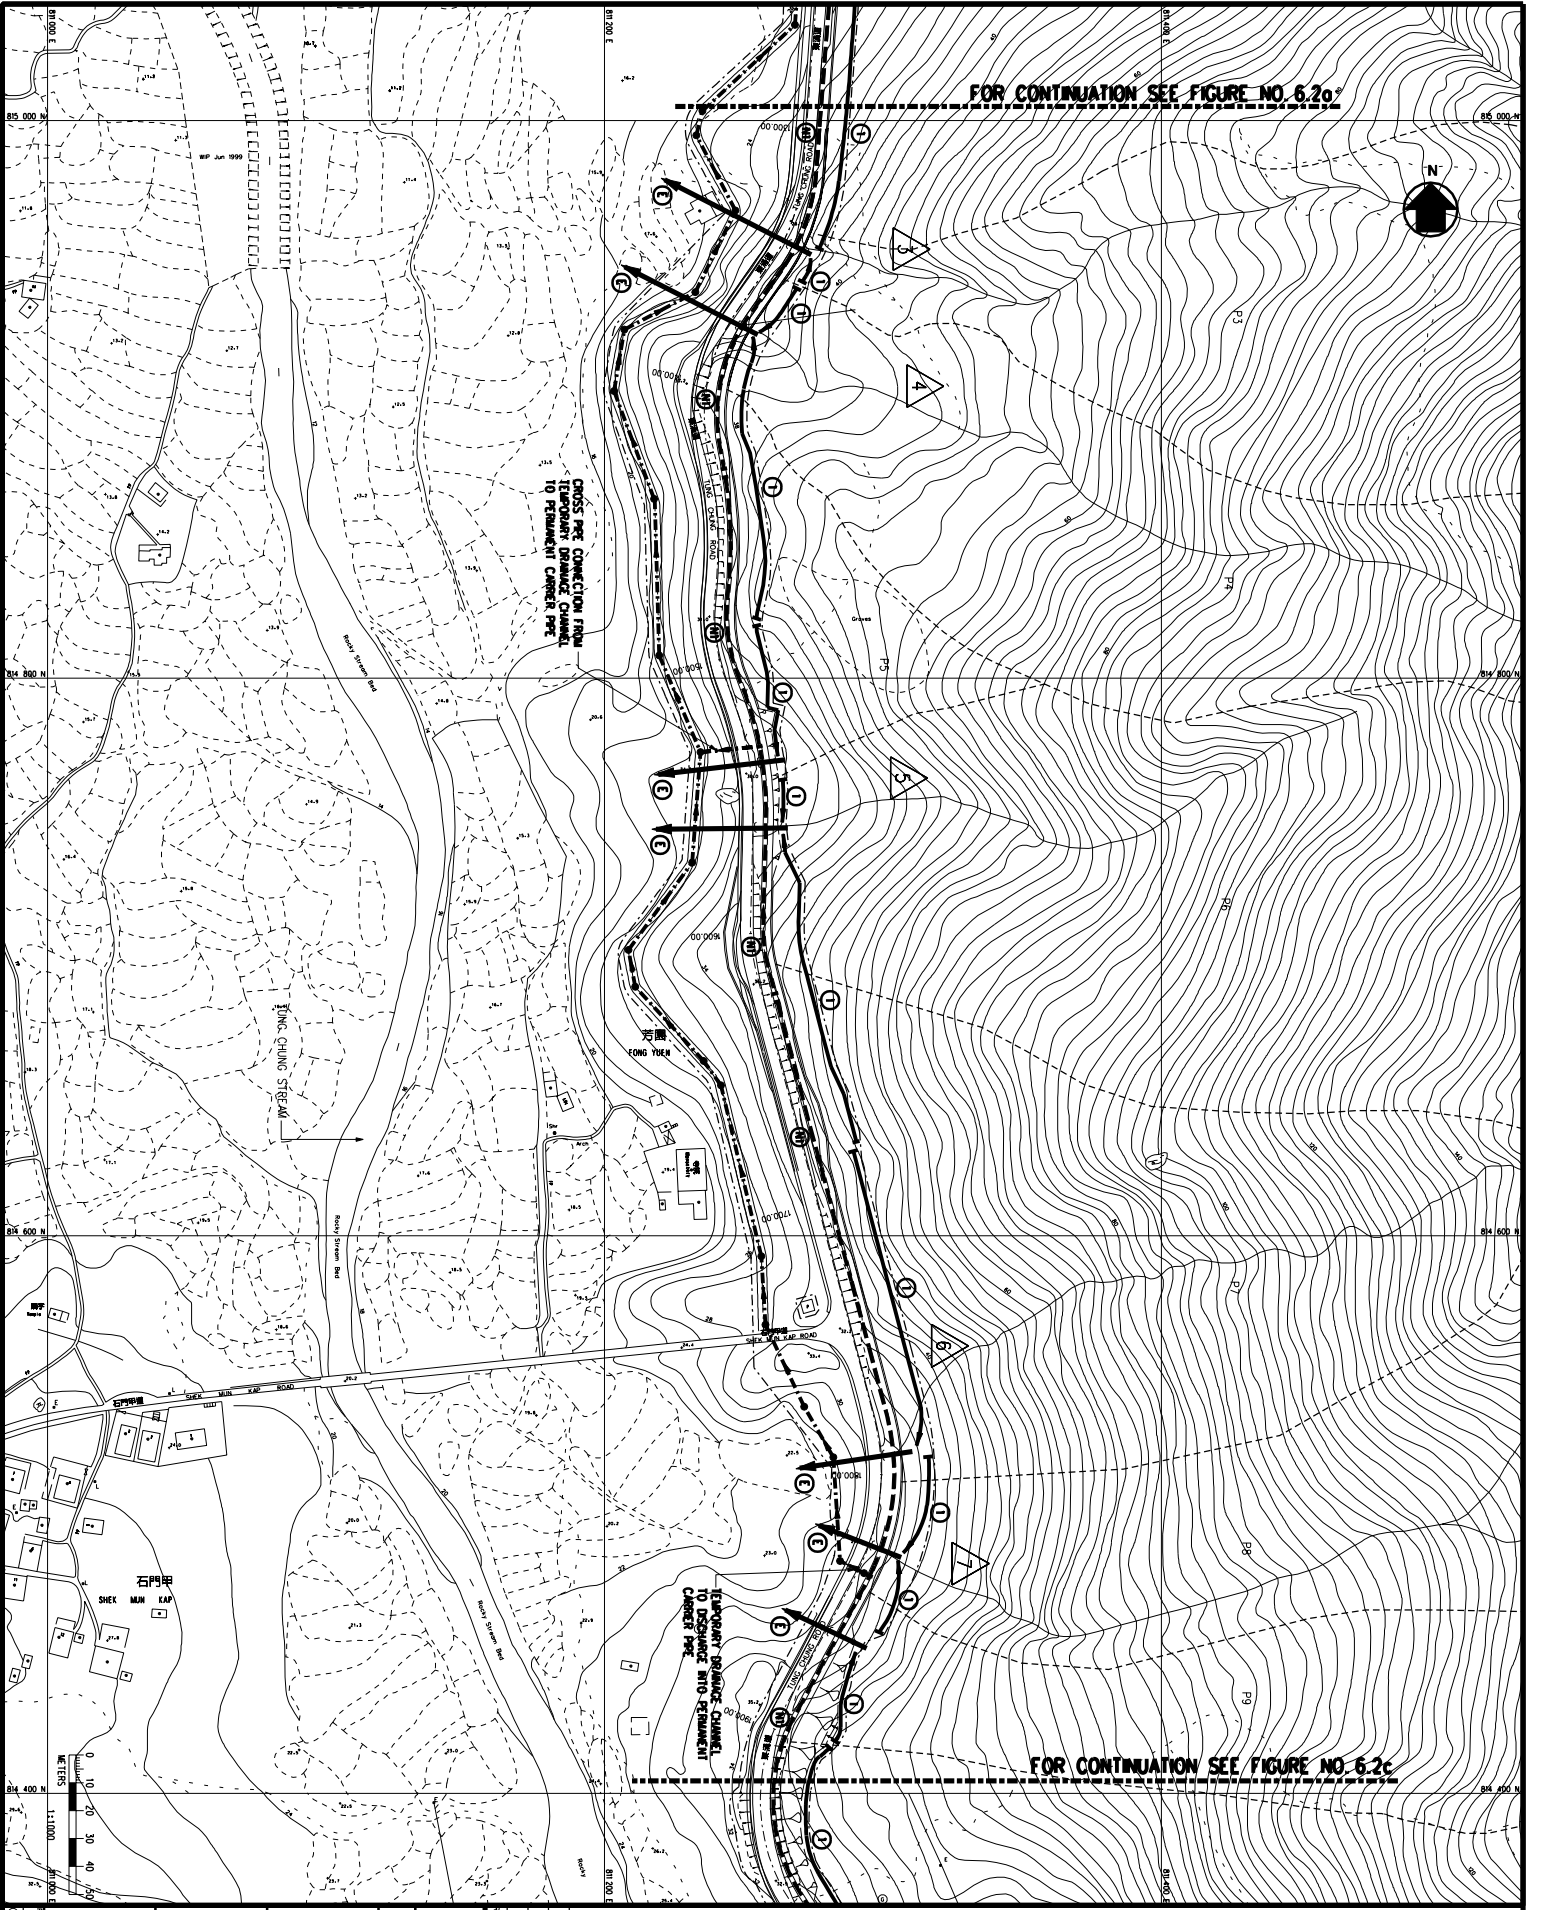

FOR CONTINUATION SEE FIGURE NO. 6.2c

<p>LEGEND</p> <ul style="list-style-type: none"> ① SUB-CATCHMENT BOUNDARIES ② WATER AND DRAINAGE CHANNELS (MIN. SIZE 300 WIDE x 100 DEEP) ③ TEMPORARY DRAINAGE CHANNEL IN EXISTING ROAD (MIN. ROAD WIDTH 3.0M) (MIN. SIZE 400 WIDE x 500 DEEP) ④ TEMPORARY DRAINAGE CHANNEL IN NEW ROAD (MIN. ROAD WIDTH 3.0M) (MIN. SIZE 400 WIDE x 500 DEEP) ⑤ CONSTRUCTION SITE DRAINAGE CHANNEL (MIN. SIZE 400 WIDE x 500 DEEP) ⑥ TEMPORARY CROSS ROAD DRAIN ⑦ EXISTING CROSS ROAD DRAIN ⑧ TEMPORARY CARRIAGE PPE ALONG EXISTING ROAD (MIN. SIZE 3.75M) ⑨ TEMPORARY CROSS PPE ■ SETTLING TANK ■ SETTLING TANK / OIL INTERCEPTOR 										
<p>TITLE</p> <p>TEMPORARY DRAINAGE LAYOUT PLAN</p>										
<p>PROJECT</p> <p>IMPROVEMENT TO TUNG CHING ROAD BETWEEN LUNG TSENG TAU AND CHEUNG SHA INVESTIGATION AND PRELIMINARY DESIGN ASSIGNMENT</p>										
<p>CLIENT</p> <p>THE GOVERNMENT OF THE HONG KONG SPECIAL ADMINISTRATIVE REGION</p>										
<p>DESIGNER</p> <p>MOUCHEL ASIA LIMITED</p>										
<p>DATE</p> <p>12/2001</p>										
<p>PROJECT NO.</p> <p>CE 13/2001</p>										
<p>REVISIONS</p> <table border="1"> <tr> <th>NO.</th> <th>DESCRIPTION</th> <th>DATE</th> </tr> <tr> <td>1</td> <td>ISSUED FOR PRELIMINARY DESIGN</td> <td>12/2001</td> </tr> <tr> <td>2</td> <td>ISSUED FOR PRELIMINARY DESIGN</td> <td>12/2001</td> </tr> </table>		NO.	DESCRIPTION	DATE	1	ISSUED FOR PRELIMINARY DESIGN	12/2001	2	ISSUED FOR PRELIMINARY DESIGN	12/2001
NO.	DESCRIPTION	DATE								
1	ISSUED FOR PRELIMINARY DESIGN	12/2001								
2	ISSUED FOR PRELIMINARY DESIGN	12/2001								
<p>APPROVED</p> <p>BY: [Signature] DATE: [Date]</p>										
<p>SCALE</p> <p>1:1000</p>										
<p>PROJECT NO.</p> <p>CE 13/2001</p>										
<p>CLIENT</p> <p>THE GOVERNMENT OF THE HONG KONG SPECIAL ADMINISTRATIVE REGION</p>										
<p>DESIGNER</p> <p>MOUCHEL ASIA LIMITED</p>										
<p>DATE</p> <p>12/2001</p>										
<p>PROJECT NO.</p> <p>CE 13/2001</p>										
<p>SCALE</p> <p>1:1000</p>										
<p>PROJECT NO.</p> <p>CE 13/2001</p>										

Mouchel
Mouchel Asia Limited
Consulting Engineers
高錕亞洲顧問工程公司

PROJECT NO. CE 13/2001
SHEET 2 OF 10

DATE: 12/2001
SCALE: 1:1000