


Plot Date: 1/30/2007

CAD Filename: p:\drain\water\drainage\382486-0201\vela\fig 4.dgn

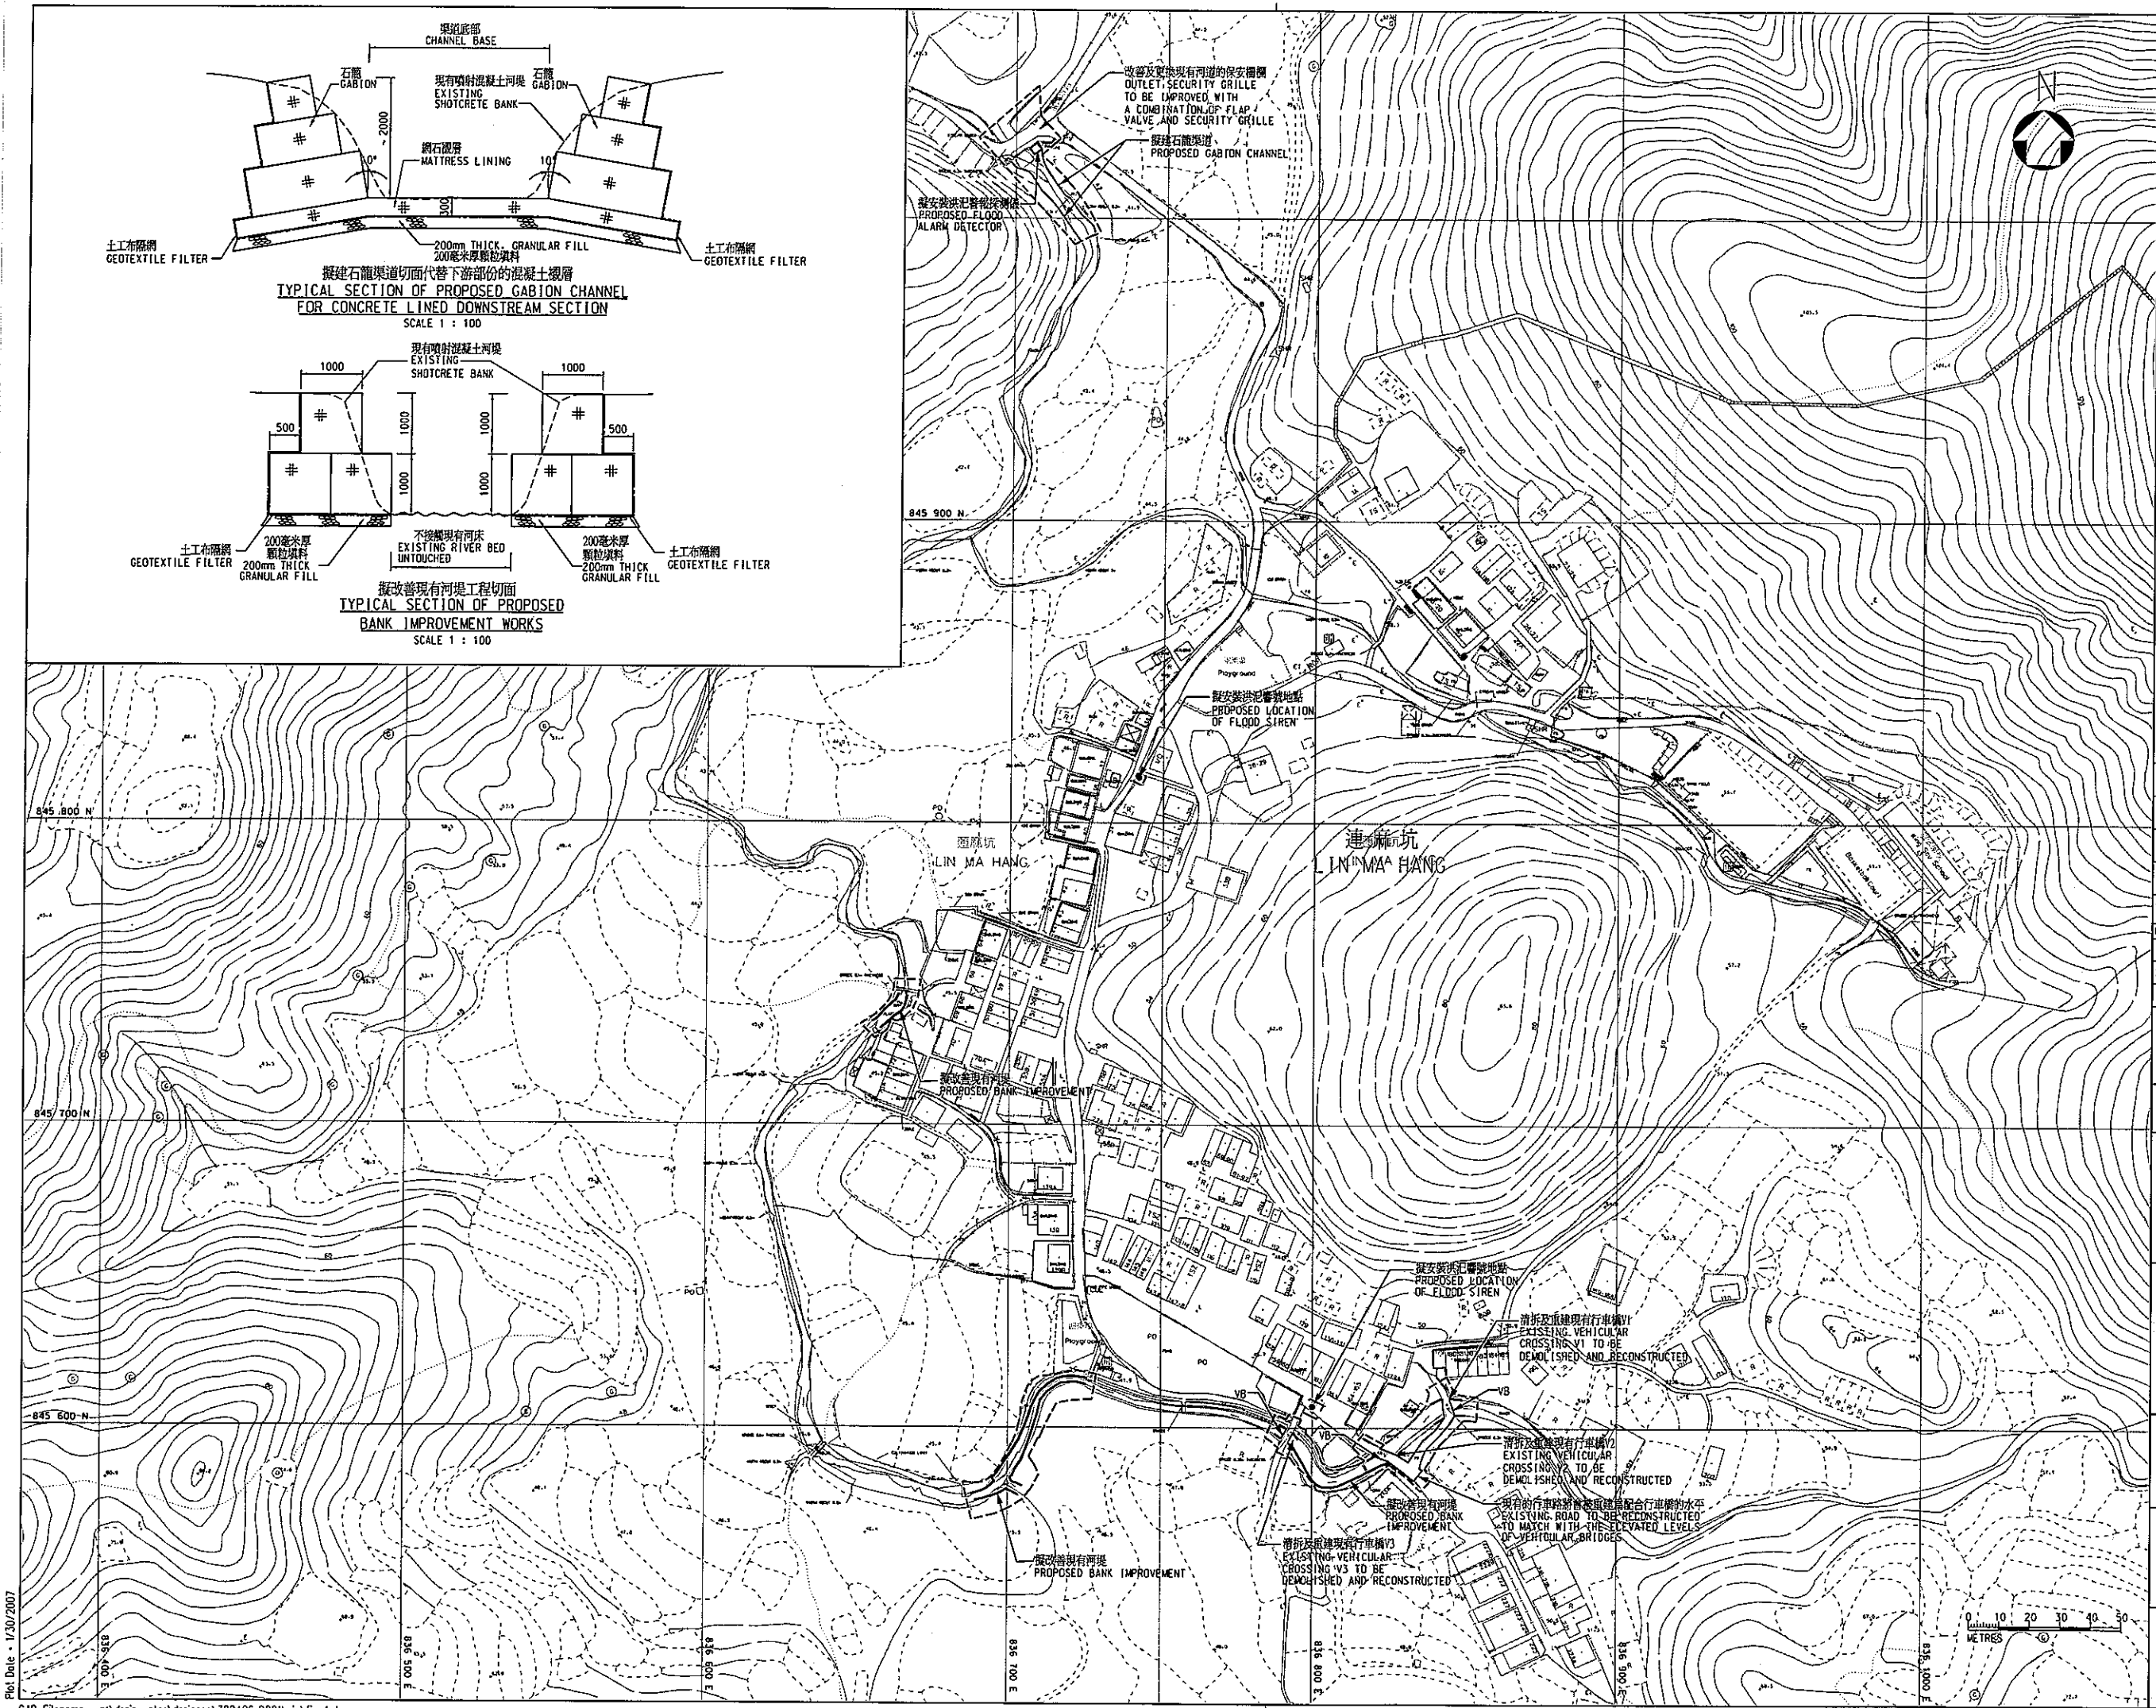

Copyright by Black & Veatch Hong Kong Limited

- 注 NOTES:
- 所有水不以米為單位，並在香港主水平基準上。ALL LEVELS ARE IN METRES ABOVE PRINCIPAL DATUM (mPD).
  - 除特別說明外，全部尺寸以毫米為單位。ALL DIMENSIONS ARE IN MILLIMETRES UNLESS OTHERWISE STATED.
  - 洪水意外將會直接由自動報警系統向香港警務處、消防處、民政事務總署和村代表報告。AUTOMATIC DIALLING SYSTEM IS TO BE PROVIDED TO DIRECTLY REPORT FLOODING INCIDENT TO HKP, FSD, HAD AND VILLAGE REPRESENTATIVES.
  - 擬建的安全上回閘機將會由香港警務處和渠務署共同決定。THE PROPOSED TYPES OF SECURITY FLAP VALVE IS TO BE AGREED WITH HKP AND OSD.

- 圖例 LEGEND:
- 地盤界線 SITE BOUNDARY
  - 擬安裝洪水警報探測器 PROPOSED FLOOD ALARM DETECTOR
  - 擬安裝洪水警報 PROPOSED FLOOD SIREN
  - 行車橋將會被重建 TO BE REPROVIDED
  - 擬建渠道 PROPOSED CHANNEL

E	05/06	BOUNDARY REVISED	CHH
D	11/05	WORKS AND BOUNDARY REVISED	CHH
C	08/05	NOTES AND WORK EXTENT UPDATED	CHH
B	09/04	NOTES & LEGEND ADDED	HMC
A	08/04	ISSUE FOR PRELIMINARY REPORT	HMC

Revision	Date	Description		Initial
	Designed	Checked	Drawn	Checked
Initial	ZL	MC	LHS	PKL
Date	12/05	12/06	12/06	12/06
Approved				

協議編號 Agreement no. CE 6/2002 (DS)

工程項目名稱 Contract title  
新界北部雨水排放系統改善計劃 - C部分  
研究、設計及建造  
DRAINAGE IMPROVEMENT IN NORTHERN NEW TERRITORIES - PACKAGE C  
INVESTIGATION, DESIGN AND CONSTRUCTION

圖則名稱 Figure title  
連麻坑建議改善工程規劃設計圖  
GENERAL ARRANGEMENT FOR PROPOSED IMPROVEMENT WORKS AT LIN MA HANG (LMH01)

圖則編號 Figure no. 4 比例 Scale 1:2000 (A3)

香港特別行政區政府渠務署  
THE GOVERNMENT OF THE HONG KONG  
SPECIAL ADMINISTRATIVE REGION  
DRAINAGE SERVICES DEPARTMENT

BLACK & VEATCH HONG KONG LIMITED  
博威工程顧問有限公司