




LEVEL 1 (+5.00) FLOOR PLAN



LEVEL 2 (+13.00) FLOOR PLAN

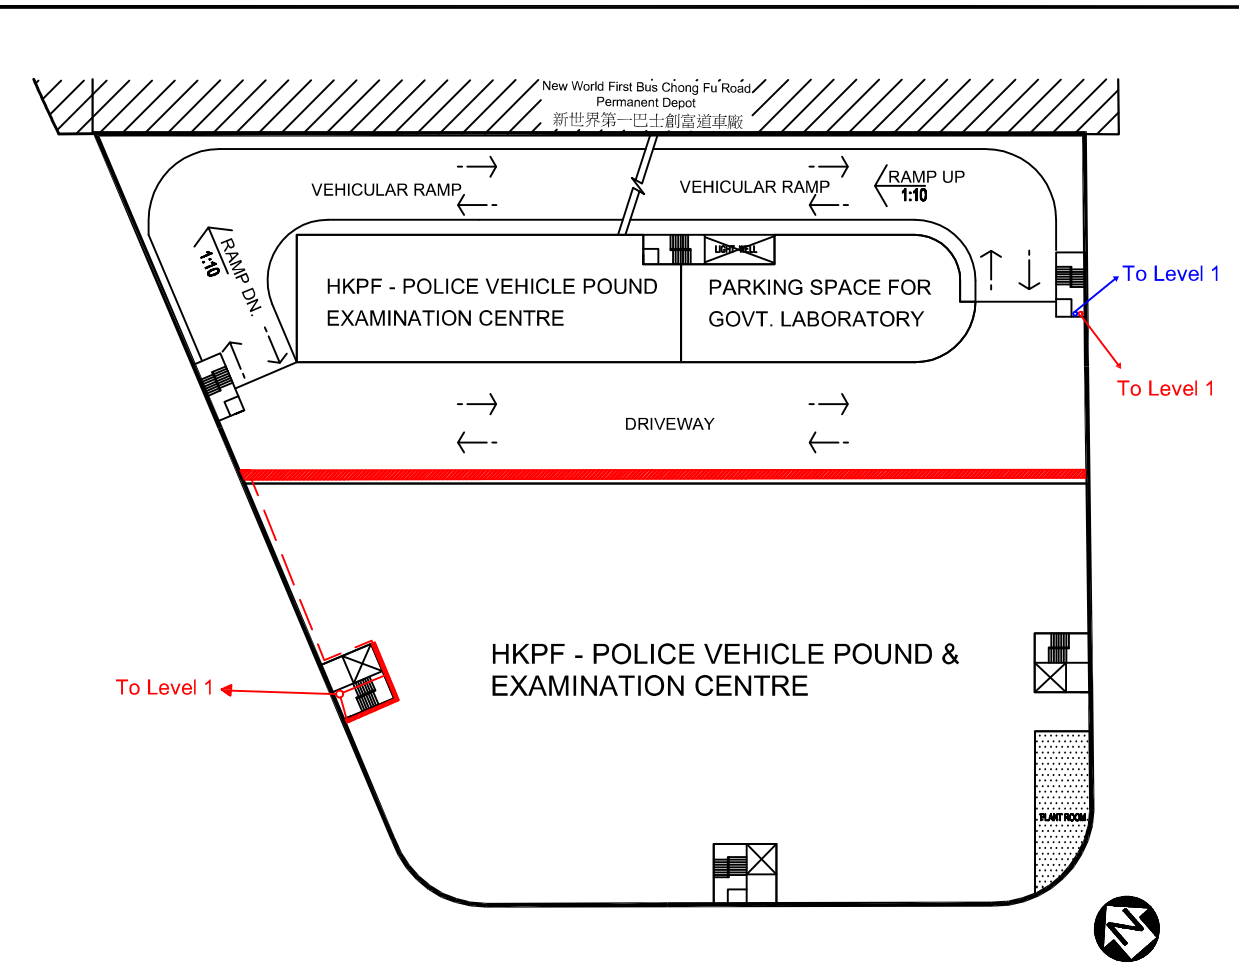

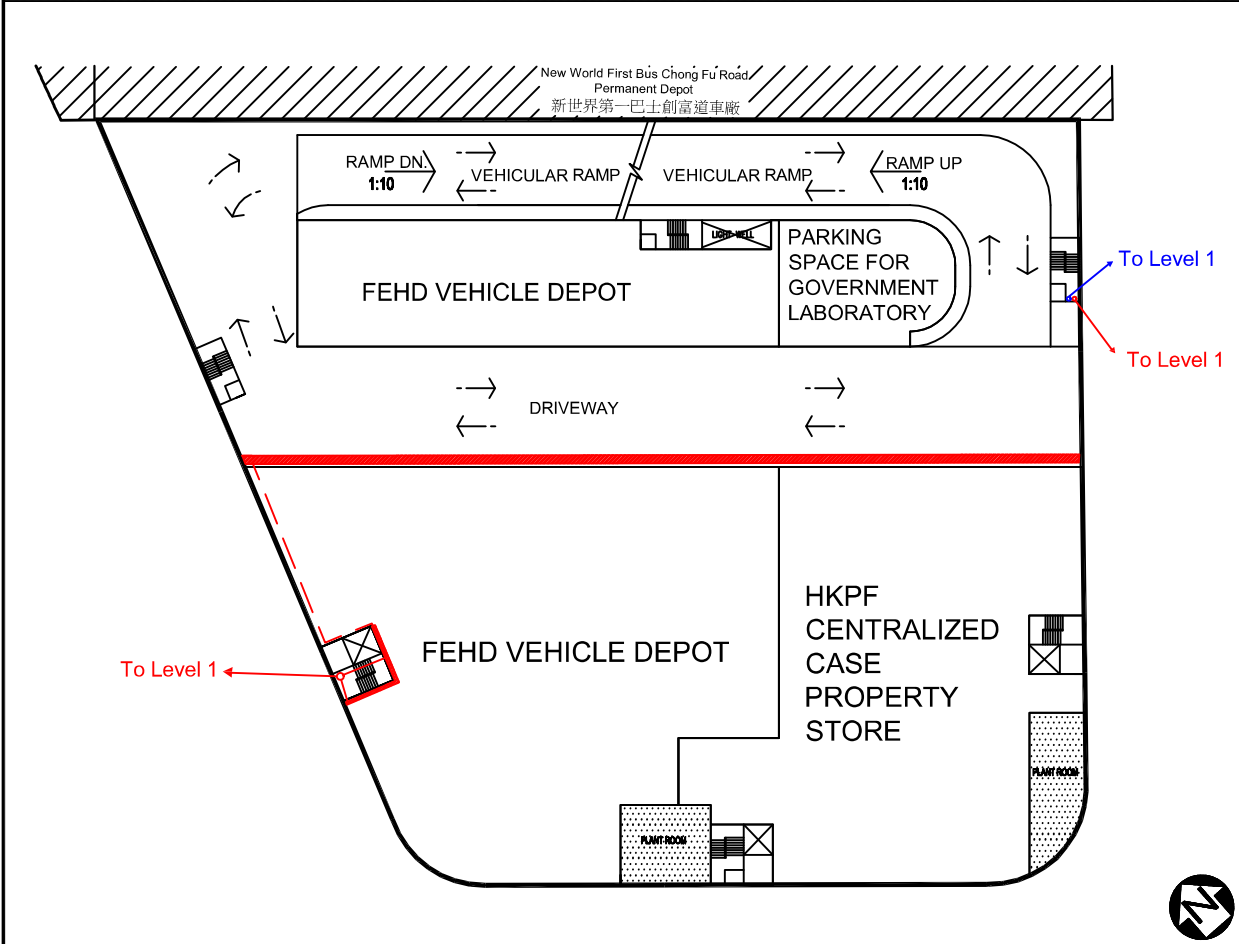

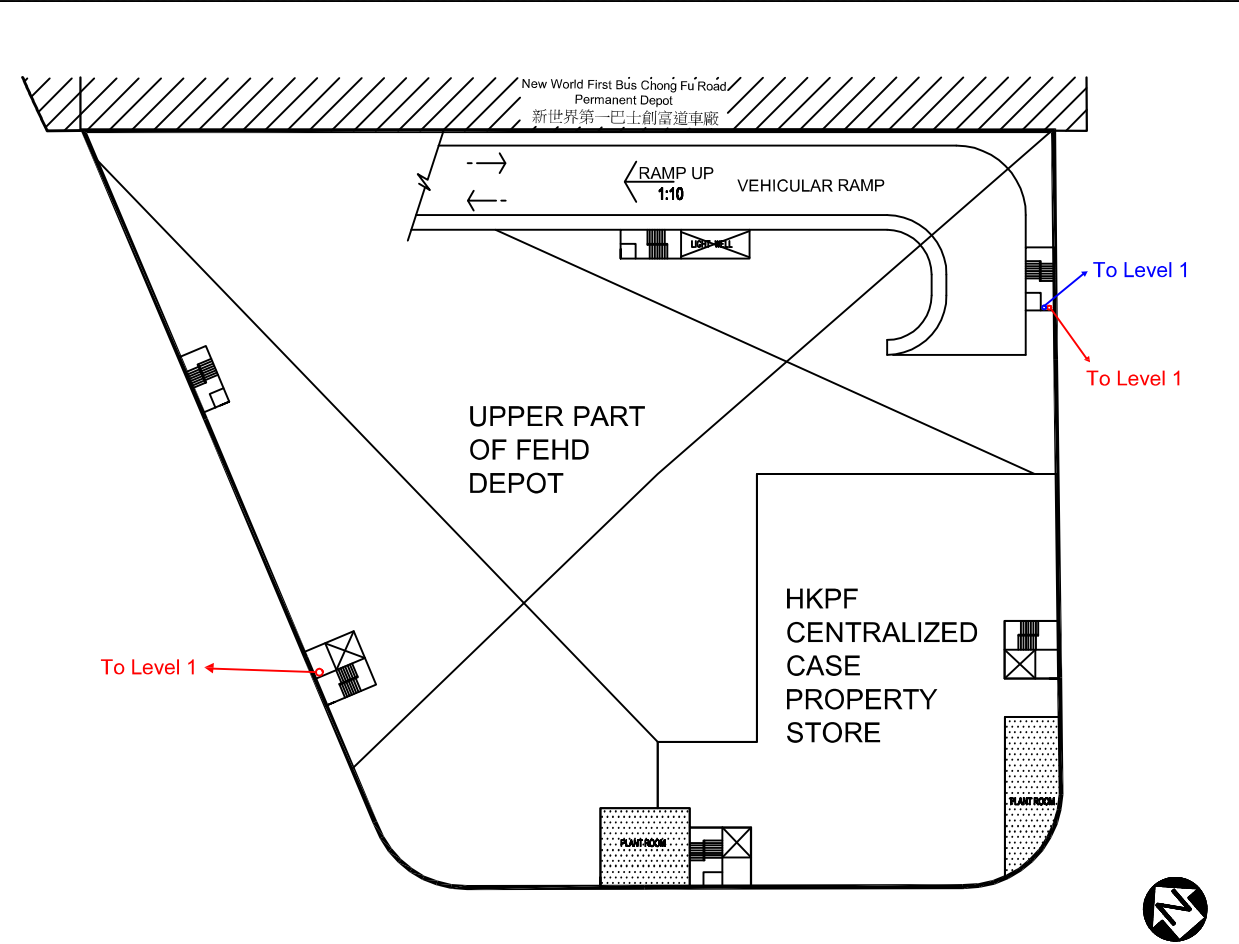


LEVEL 3 (+19.20) FLOOR PLAN




LEVEL 3M (+23.05) FLOOR PLAN

NOTES :

-  Workshop Drainage
-  Stormwater Drainage
-  Petrol Interceptor
-  Connection Pipe
-  Silt Trap

Consultant

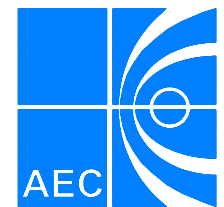

Allied Environmental Consultants Limited  
ACOUSTICIANS & ENVIRONMENTAL ENGINEERS

Project No. : 1158


File Name :

Project :  
Chai Wan Government Complex  
and Vehicle Depot


Drawing Title :  
Preliminary Layout for Drainage System

|                             |                      |
|-----------------------------|----------------------|
| Drawing No :<br>Figure 6.3a | Revision :<br>5      |
| Scale :<br>NTS              | Date :<br>April 2015 |


DO NOT SCALE OFF DRAWING. THIS DRAWING IS NOT FOR CONSTRUCTION PURPOSES UNLESS EXPRESSLY STATED. ALL RIGHTS RESERVED AND REPRODUCTION IN ANY FORM MUST BE APPROVED BY ALLIED ENVIRONMENTAL CONSULTANTS LIMITED.

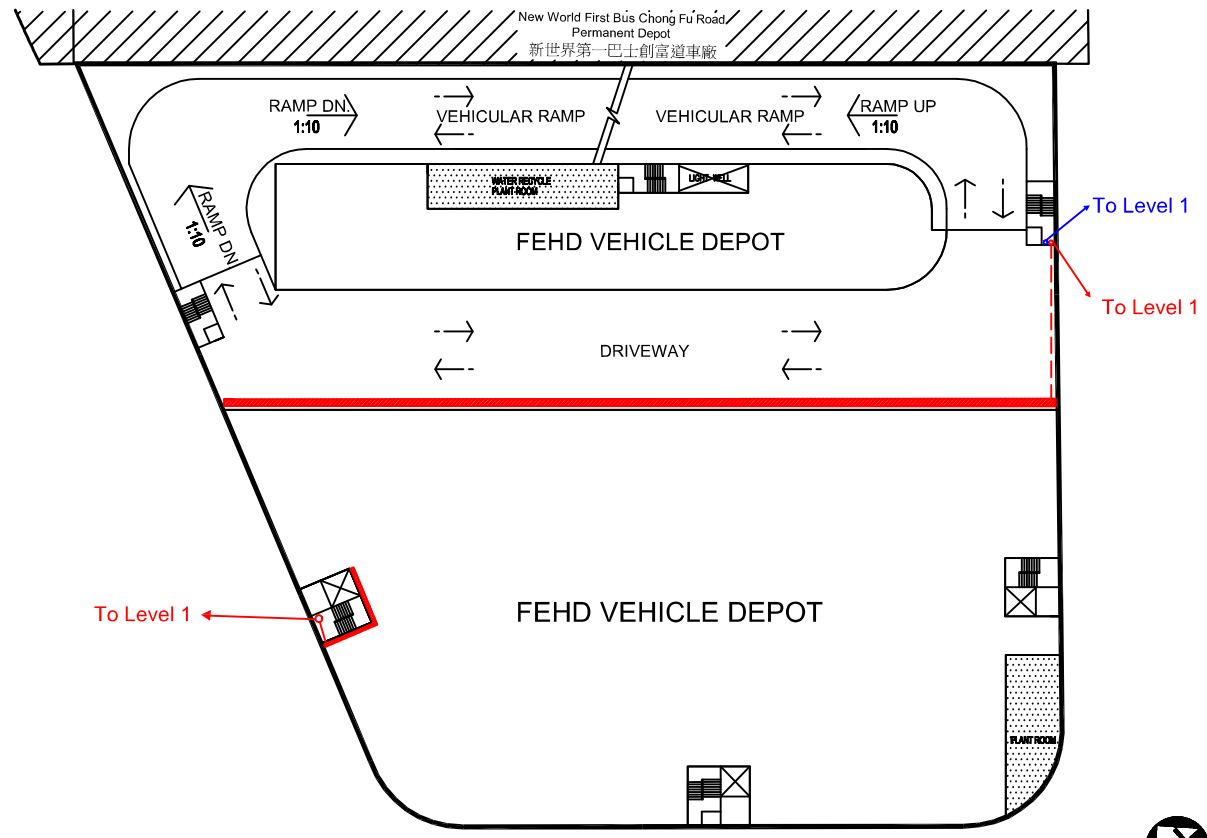


LEVEL 4 (+26.90) FLOOR PLAN

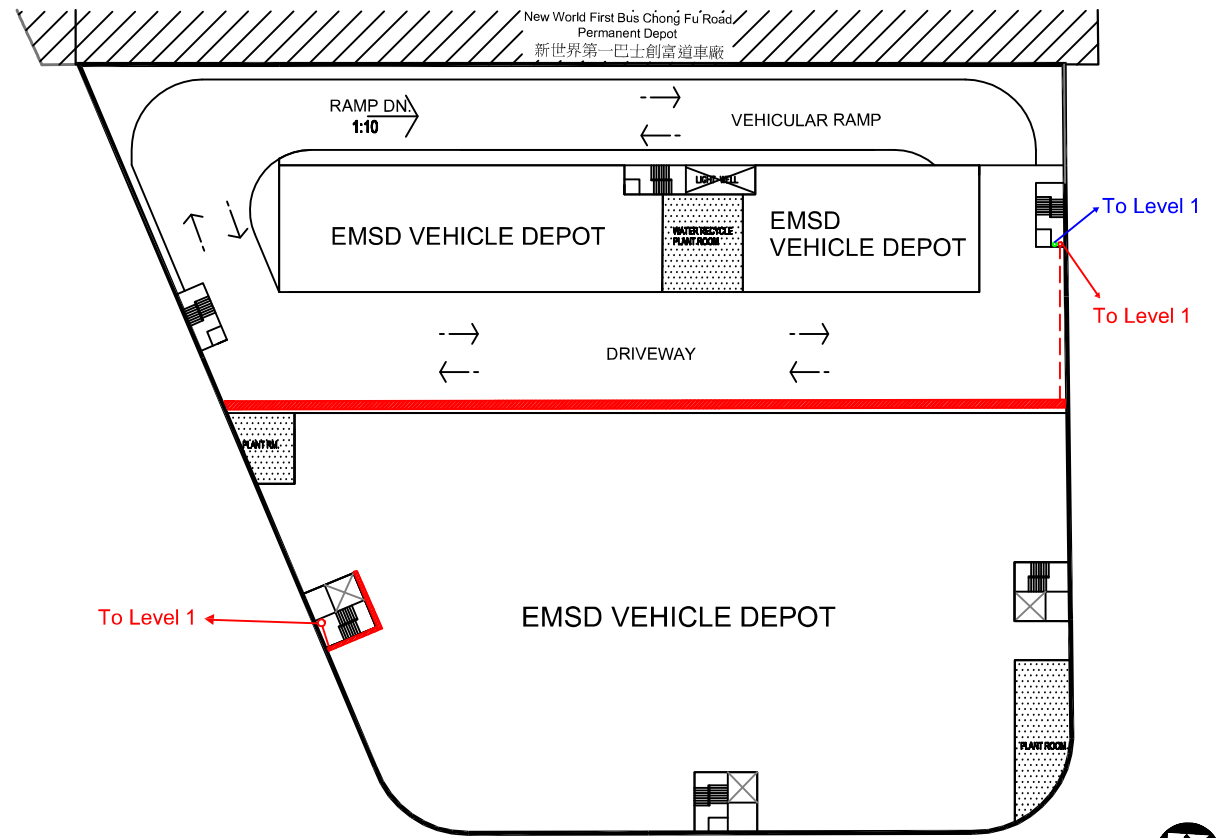

LEVEL 5 (+33.10) FLOOR PLAN

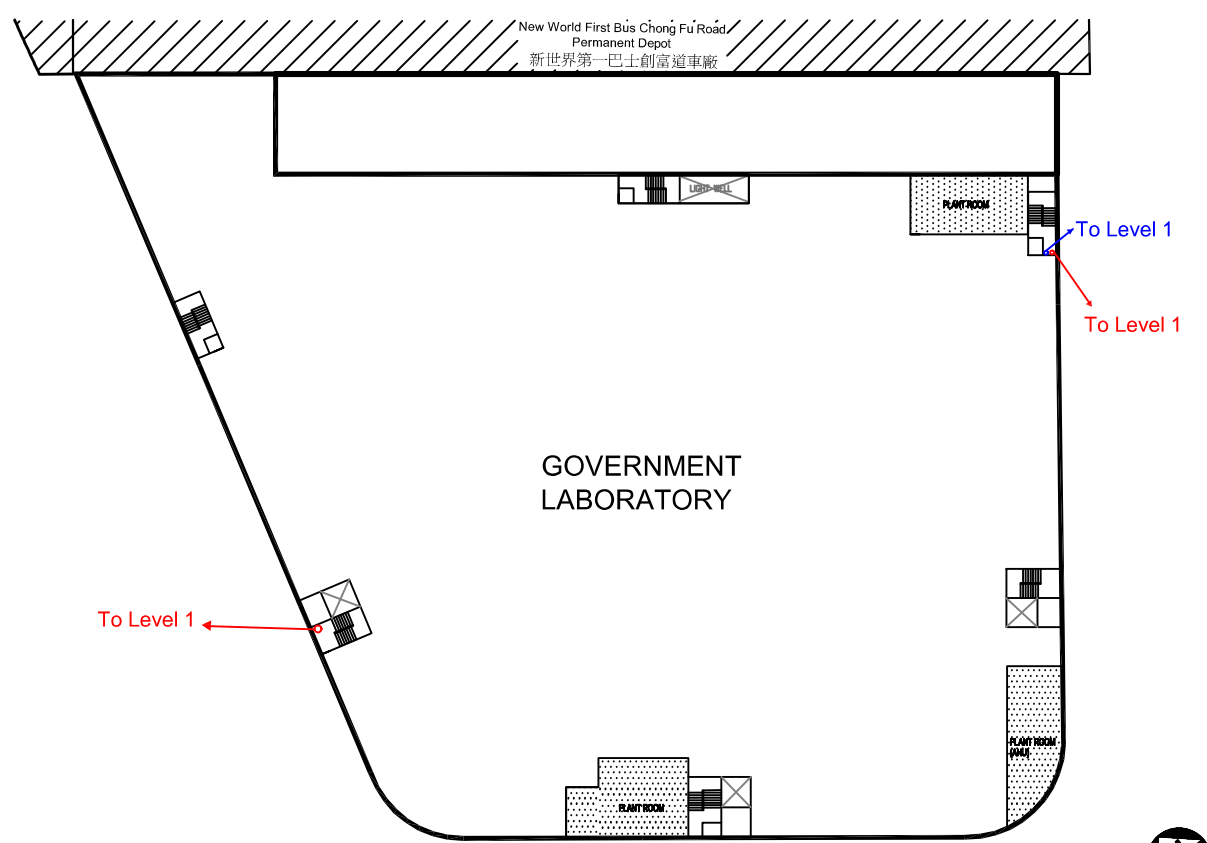

LEVEL 6 (+40.30) FLOOR PLAN

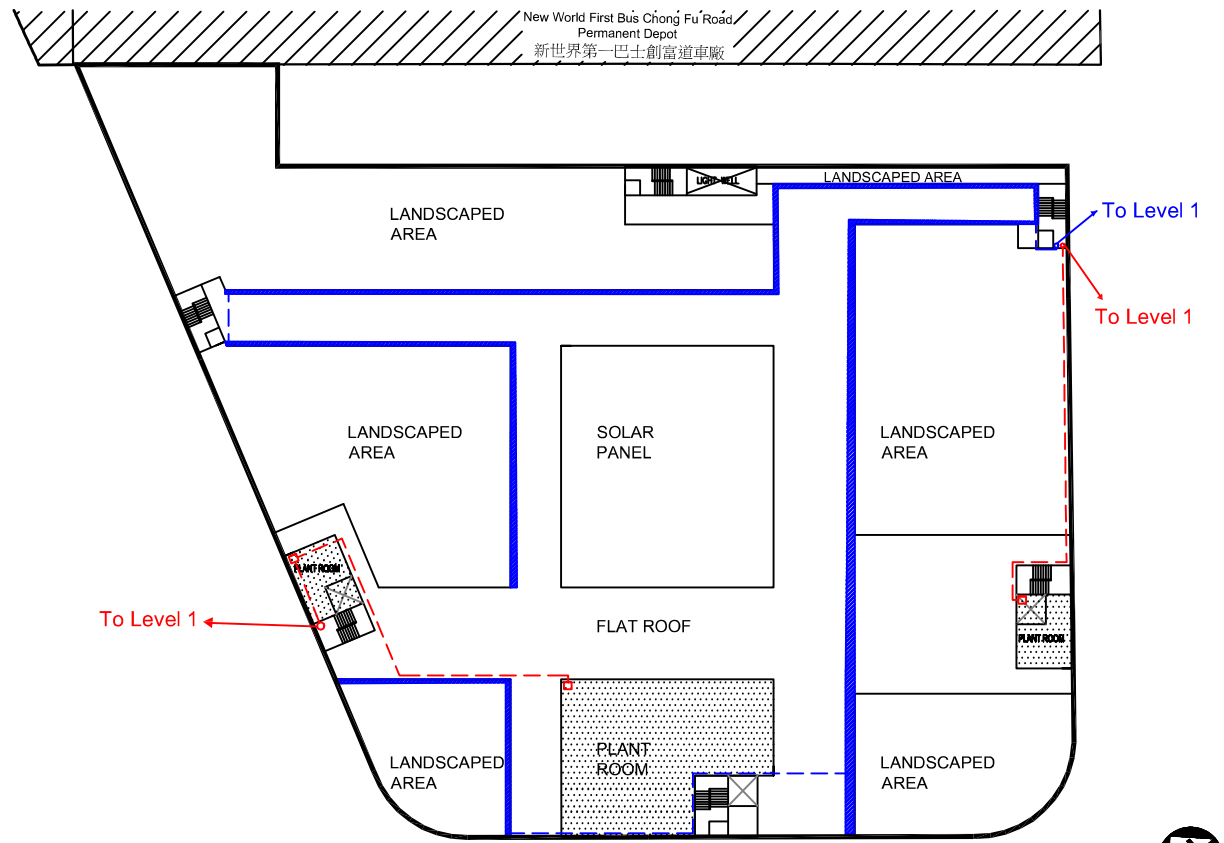

ROOF PLAN (+45.00)

- NOTES :
- Workshop Drainage
  - Stormwater Drainage
  - Petrol Interceptor
  - Connection Pipe
  - Silt Trap

Consultant



**Allied Environmental Consultants Limited**  
ACOUSTICIANS & ENVIRONMENTAL ENGINEERS

Project No. : 1158

File Name :

Project :  
Chai Wan Government Complex  
and Vehicle Depot

Drawing Title :  
Preliminary Layout for Drainage System

Drawing No : Figure 6.3b      Revision : 5

Scale : NTS      Date : April 2015

DO NOT SCALE OFF DRAWING. THIS DRAWING IS NOT FOR CONSTRUCTION PURPOSES UNLESS EXPRESSLY STATED. ALL RIGHTS RESERVED AND REPRODUCTION IN ANY FORM MUST BE APPROVED BY ALLIED ENVIRONMENTAL CONSULTANTS LIMITED.