

LEGEND:
 ——— MAIN SEWAGE PROCESS
 - - - - - SLUDGE & WASTES
 - - - - - BIO GAS

ISSUE/REVISION

NO.	DATE	DESCRIPTION	CHK

STATUS

SCALE
 A1 N.T.S.
DIMENSION UNIT
 METRES


KEY PLAN

PROJECT NO.
 60505476
CONTRACT NO.
 CE 3/2015 (DS)

SHEET TITLE
 PROCESS FLOW DIAGRAM OF SLUDGE STREAM

SHEET NUMBER
 60502456/EIA/APPENDIX 11.2

Pld File by: SongYN 1/10/2019
 PATH: E:\projects\605476\DRAWING\REPORT\EIA\EA 738.dgn
 Project Management Initials: Designer: Checked: Approved: ISO A1 594mm x 841mm

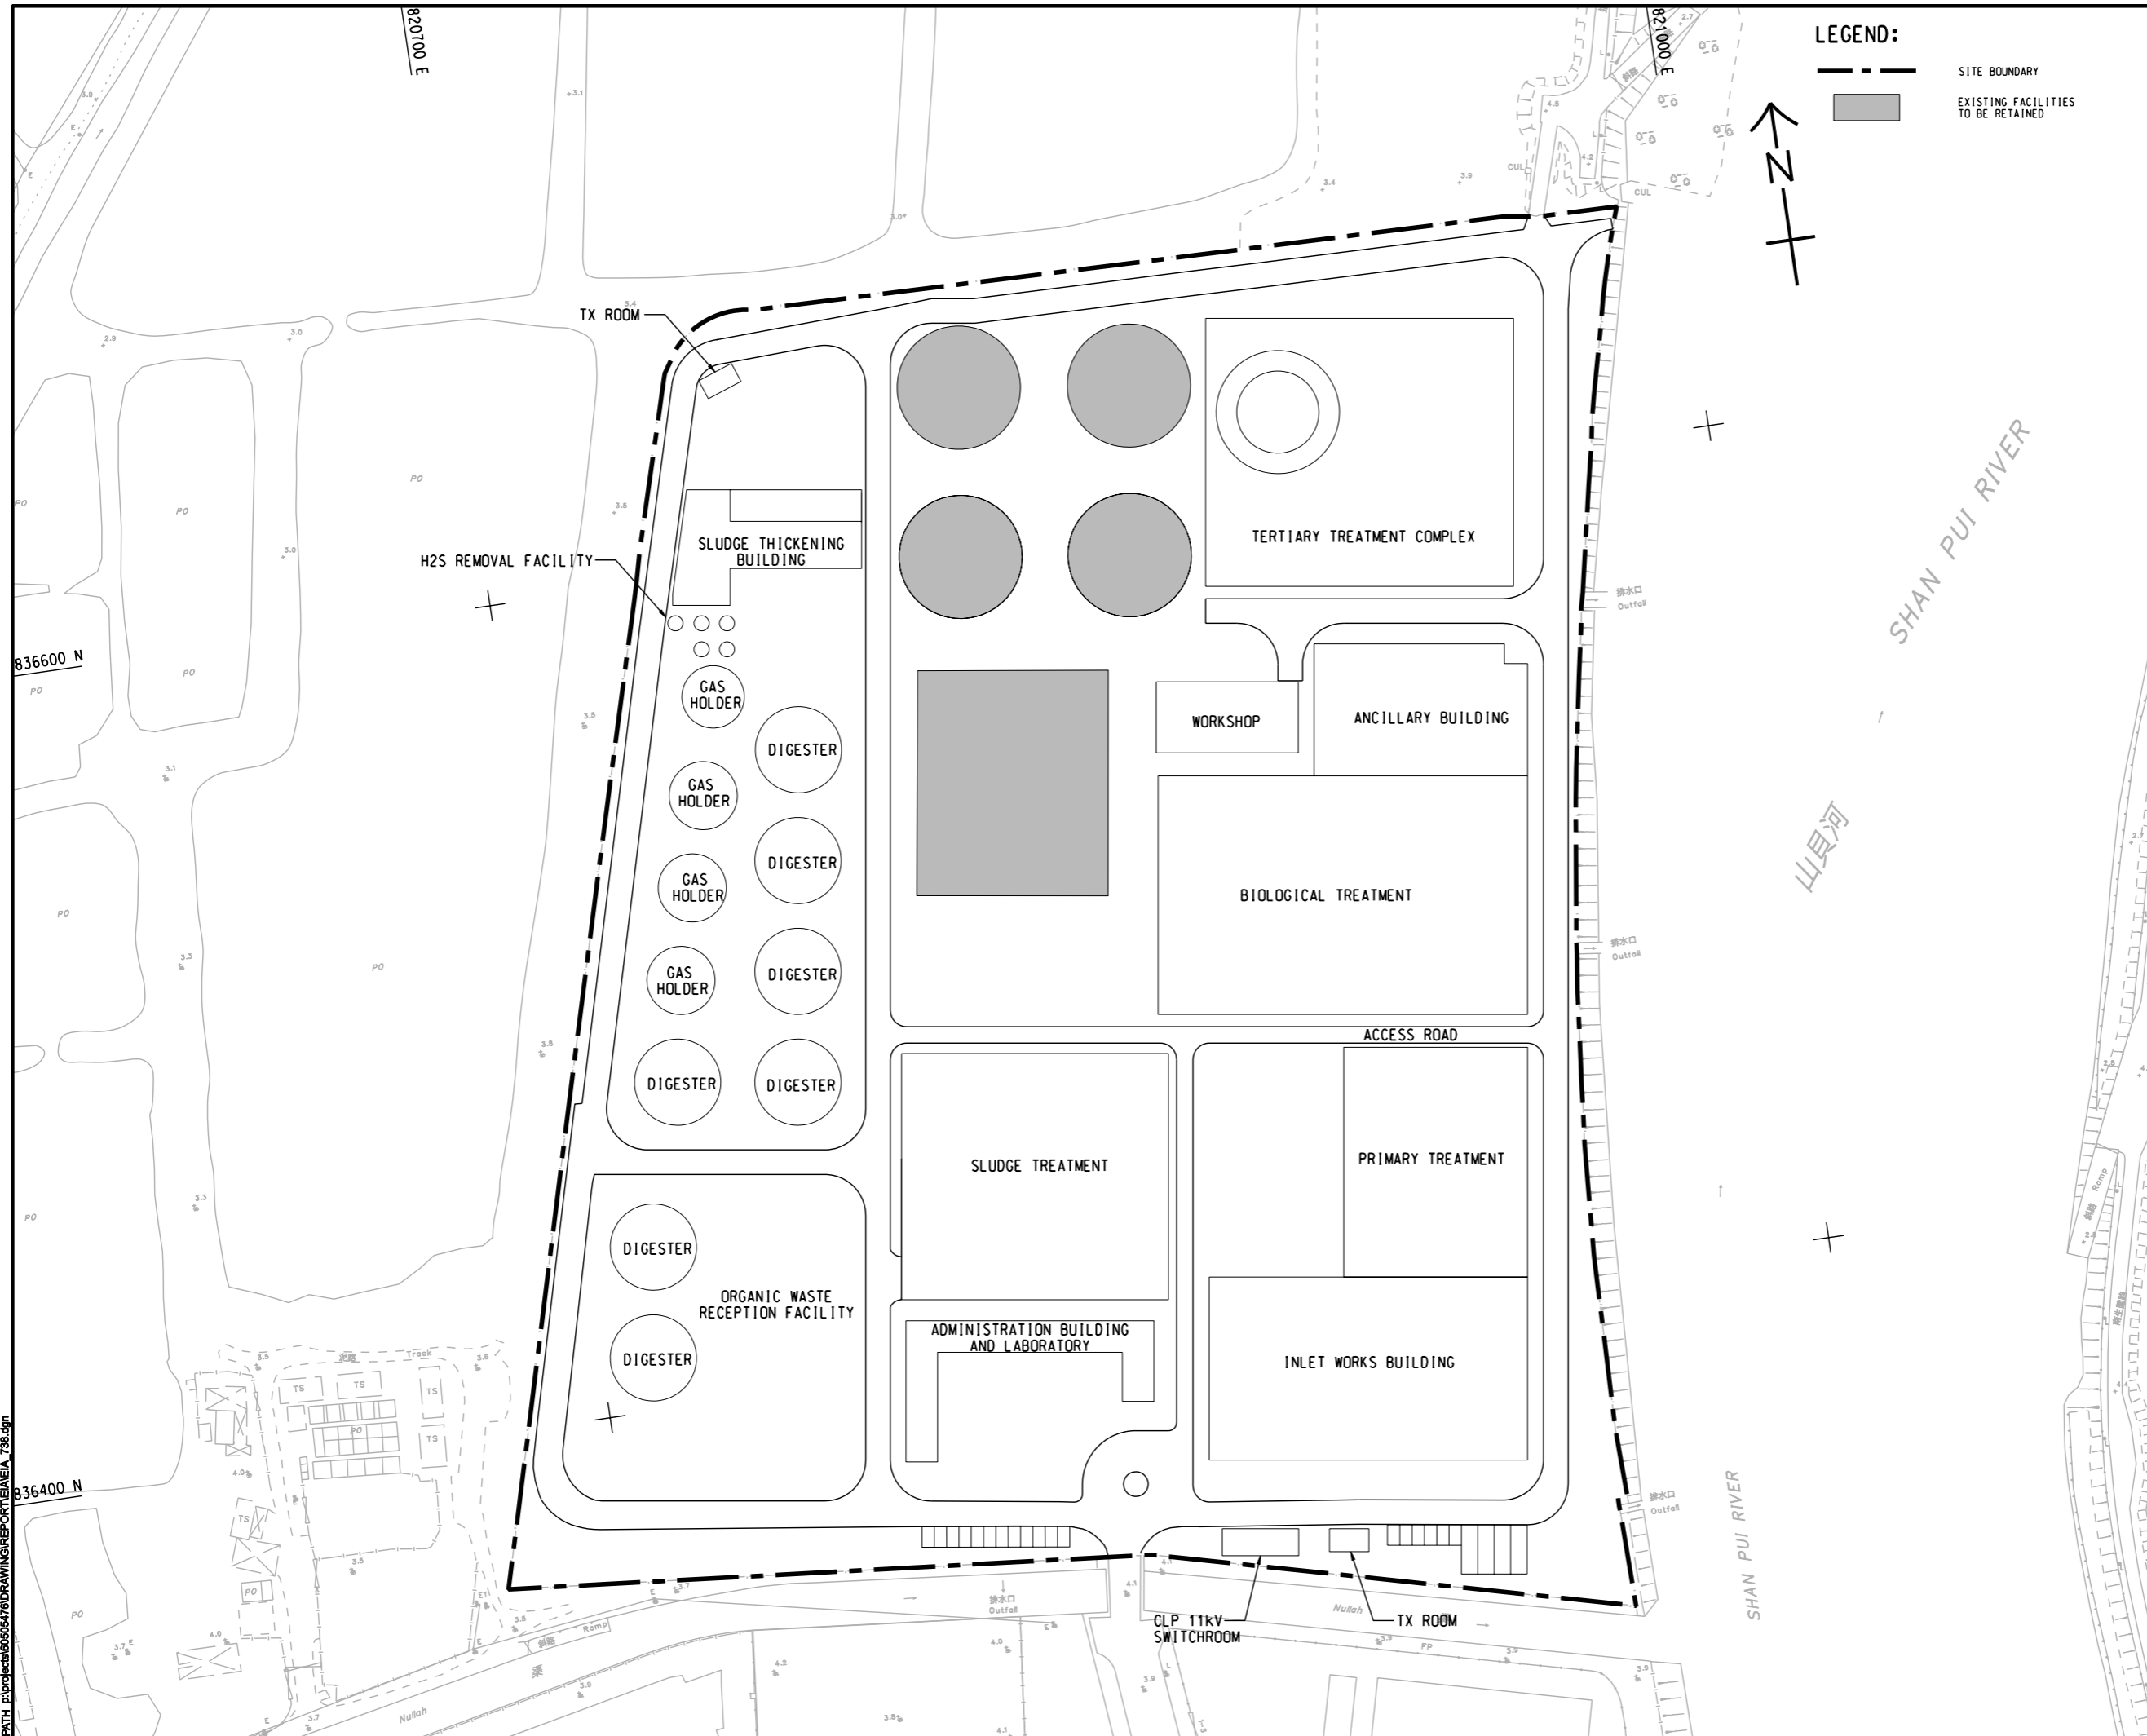

LEGEND:
 - - - - - SITE BOUNDARY
 ■ EXISTING FACILITIES TO BE RETAINED



AECOM

PROJECT
 項目
YUEN LONG EFFLUENT POLISHING PLANT - INVESTIGATION, DESIGN AND CONSTRUCTION

CLIENT
 業主
 渠務署
 Drainage Services Department

CONSULTANT
 工程顧問公司
 AECOM Asia Company Ltd.
 www.aecom.com

SUB-CONSULTANTS
 分門工程顧問公司

ISSUE/REVISION
 修訂

I/R	DATE	DESCRIPTION	CHK.
修訂	日期	內容描述	核實

STATUS
 階段

SCALE
 比例
 A1 1:750

DIMENSION UNIT
 尺寸單位
 METRES

KEY PLAN
 索引圖

PROJECT NO.
 項目編號
 60505476


CONTRACT NO.
 合約編號
 CE 3/2015 (DS)

SHEET TITLE
 圖名
 PROCESS LAYOUT OF YLEPP PHASE 1

SHEET NUMBER
 圖號
 60505476/EIA/APPENDIX 11.2A

This drawing has been prepared for the use of AECOM's client. It may not be used, modified, reproduced or relied upon by third parties, except as agreed by AECOM in writing. AECOM accepts no responsibility, and denies any liability whatsoever, to any party for uses or reliance on this drawing without AECOM's express written consent. Do not scale this document. All measurements must be obtained from the stated dimensions.

Pld File by: ZENGFX 2019/1/18
 PATH: P:\PROJECTS\38065476\DRAWING\REPORT\EIA\EA_739.dgn
 Project Management Initials: Designer: Checked: Approved: ISO A1 594mm x 841mm

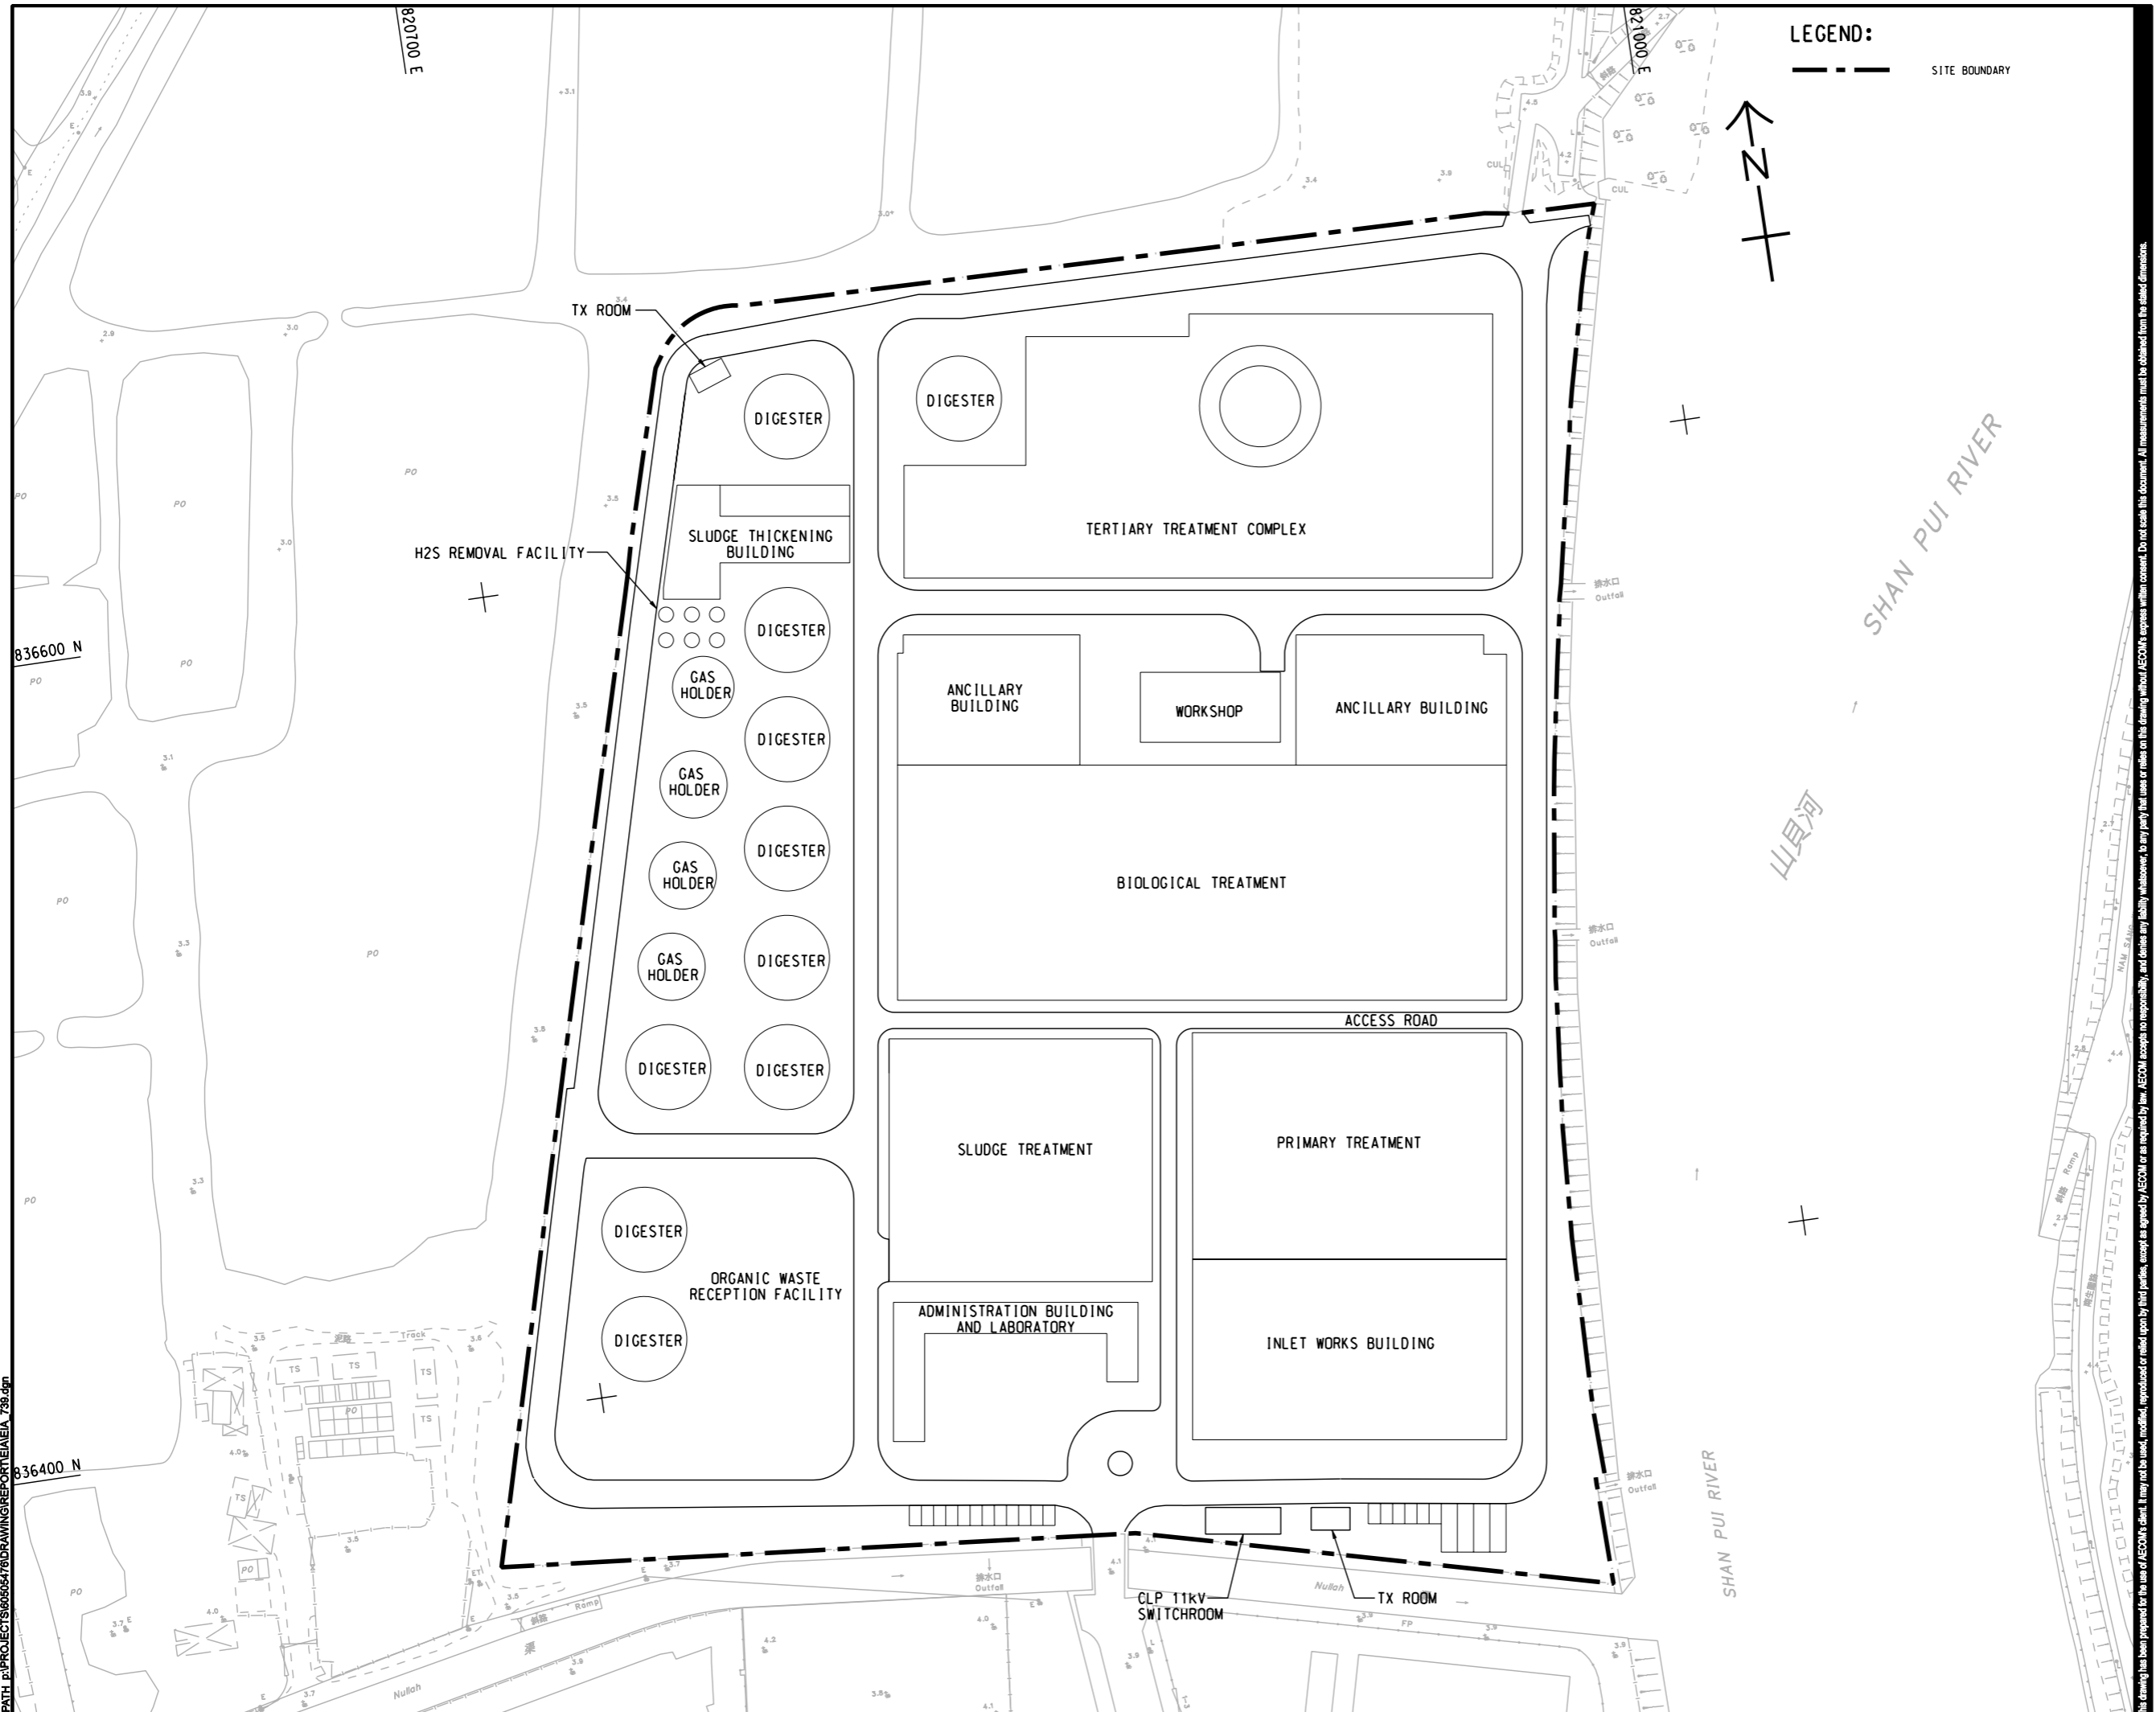

LEGEND:
 - - - - - SITE BOUNDARY

AECOM
PROJECT
YUEN LONG EFFLUENT POLISHING PLANT - INVESTIGATION, DESIGN AND CONSTRUCTION

CLIENT
 渠務署
Drainage Services Department

CONSULTANT
 AECOM Asia Company Ltd.
 www.aecom.com

SUB-CONSULTANTS
 分判工程顧問公司

ISSUE/REVISION
 修訂

I/R	DATE	DESCRIPTION	CHK.
修訂	日期	內容描述	校核

STATUS
 階段

SCALE
 比例
 A1 1:750

DIMENSION UNIT
 尺寸單位
 METRES

KEY PLAN
 索引圖

PROJECT NO.
 項目編號
 60505476

CONTRACT NO.
 合約編號
 CE 3/2015 (DS)

SHEET TITLE
 圖名
 PROCESS LAYOUT OF YLEPP PHASE 2

SHEET NUMBER
 圖號
 60505476/EIA/APPENDIX 11.2B

This drawing has been prepared for the use of AECOM's client. It may not be used, modified, reproduced or relied upon by third parties, except as agreed by AECOM in writing. AECOM accepts no responsibility, and denies any liability whatsoever, to any party that uses or relies on this drawing without AECOM's express written consent. Do not scale this document. All measurements must be obtained from the stated dimensions.